





PERSPECTIVE





PERSPECTIVE

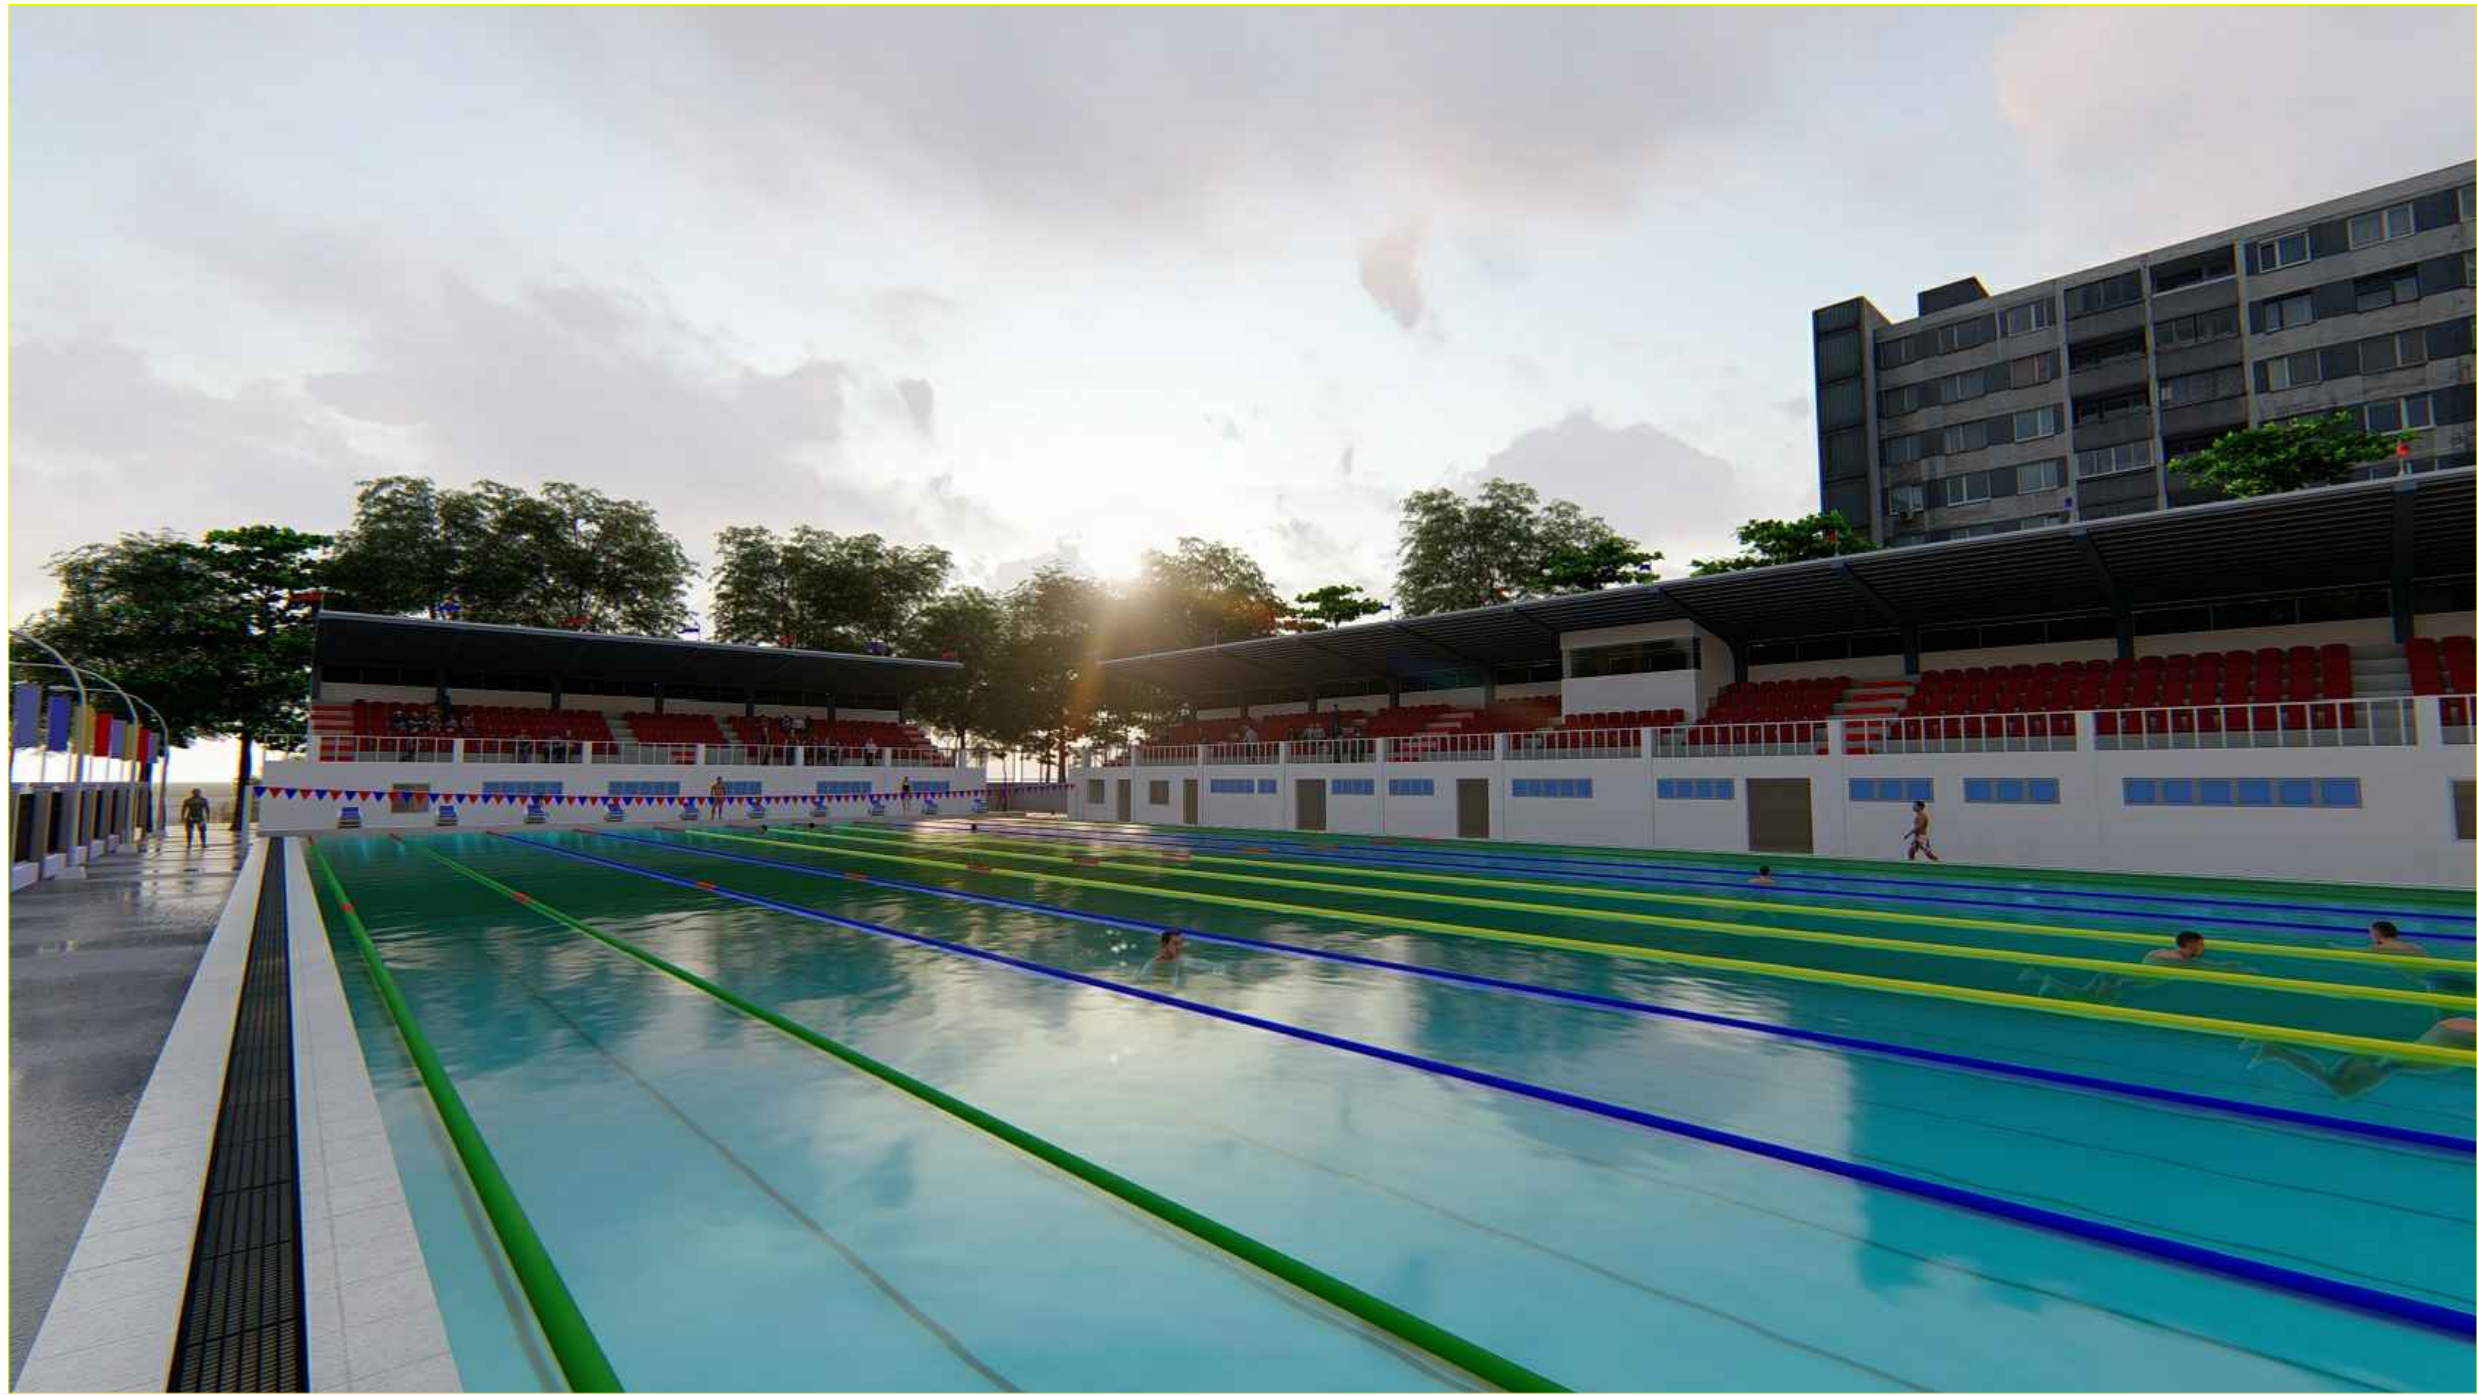

 PERSPECTIVE

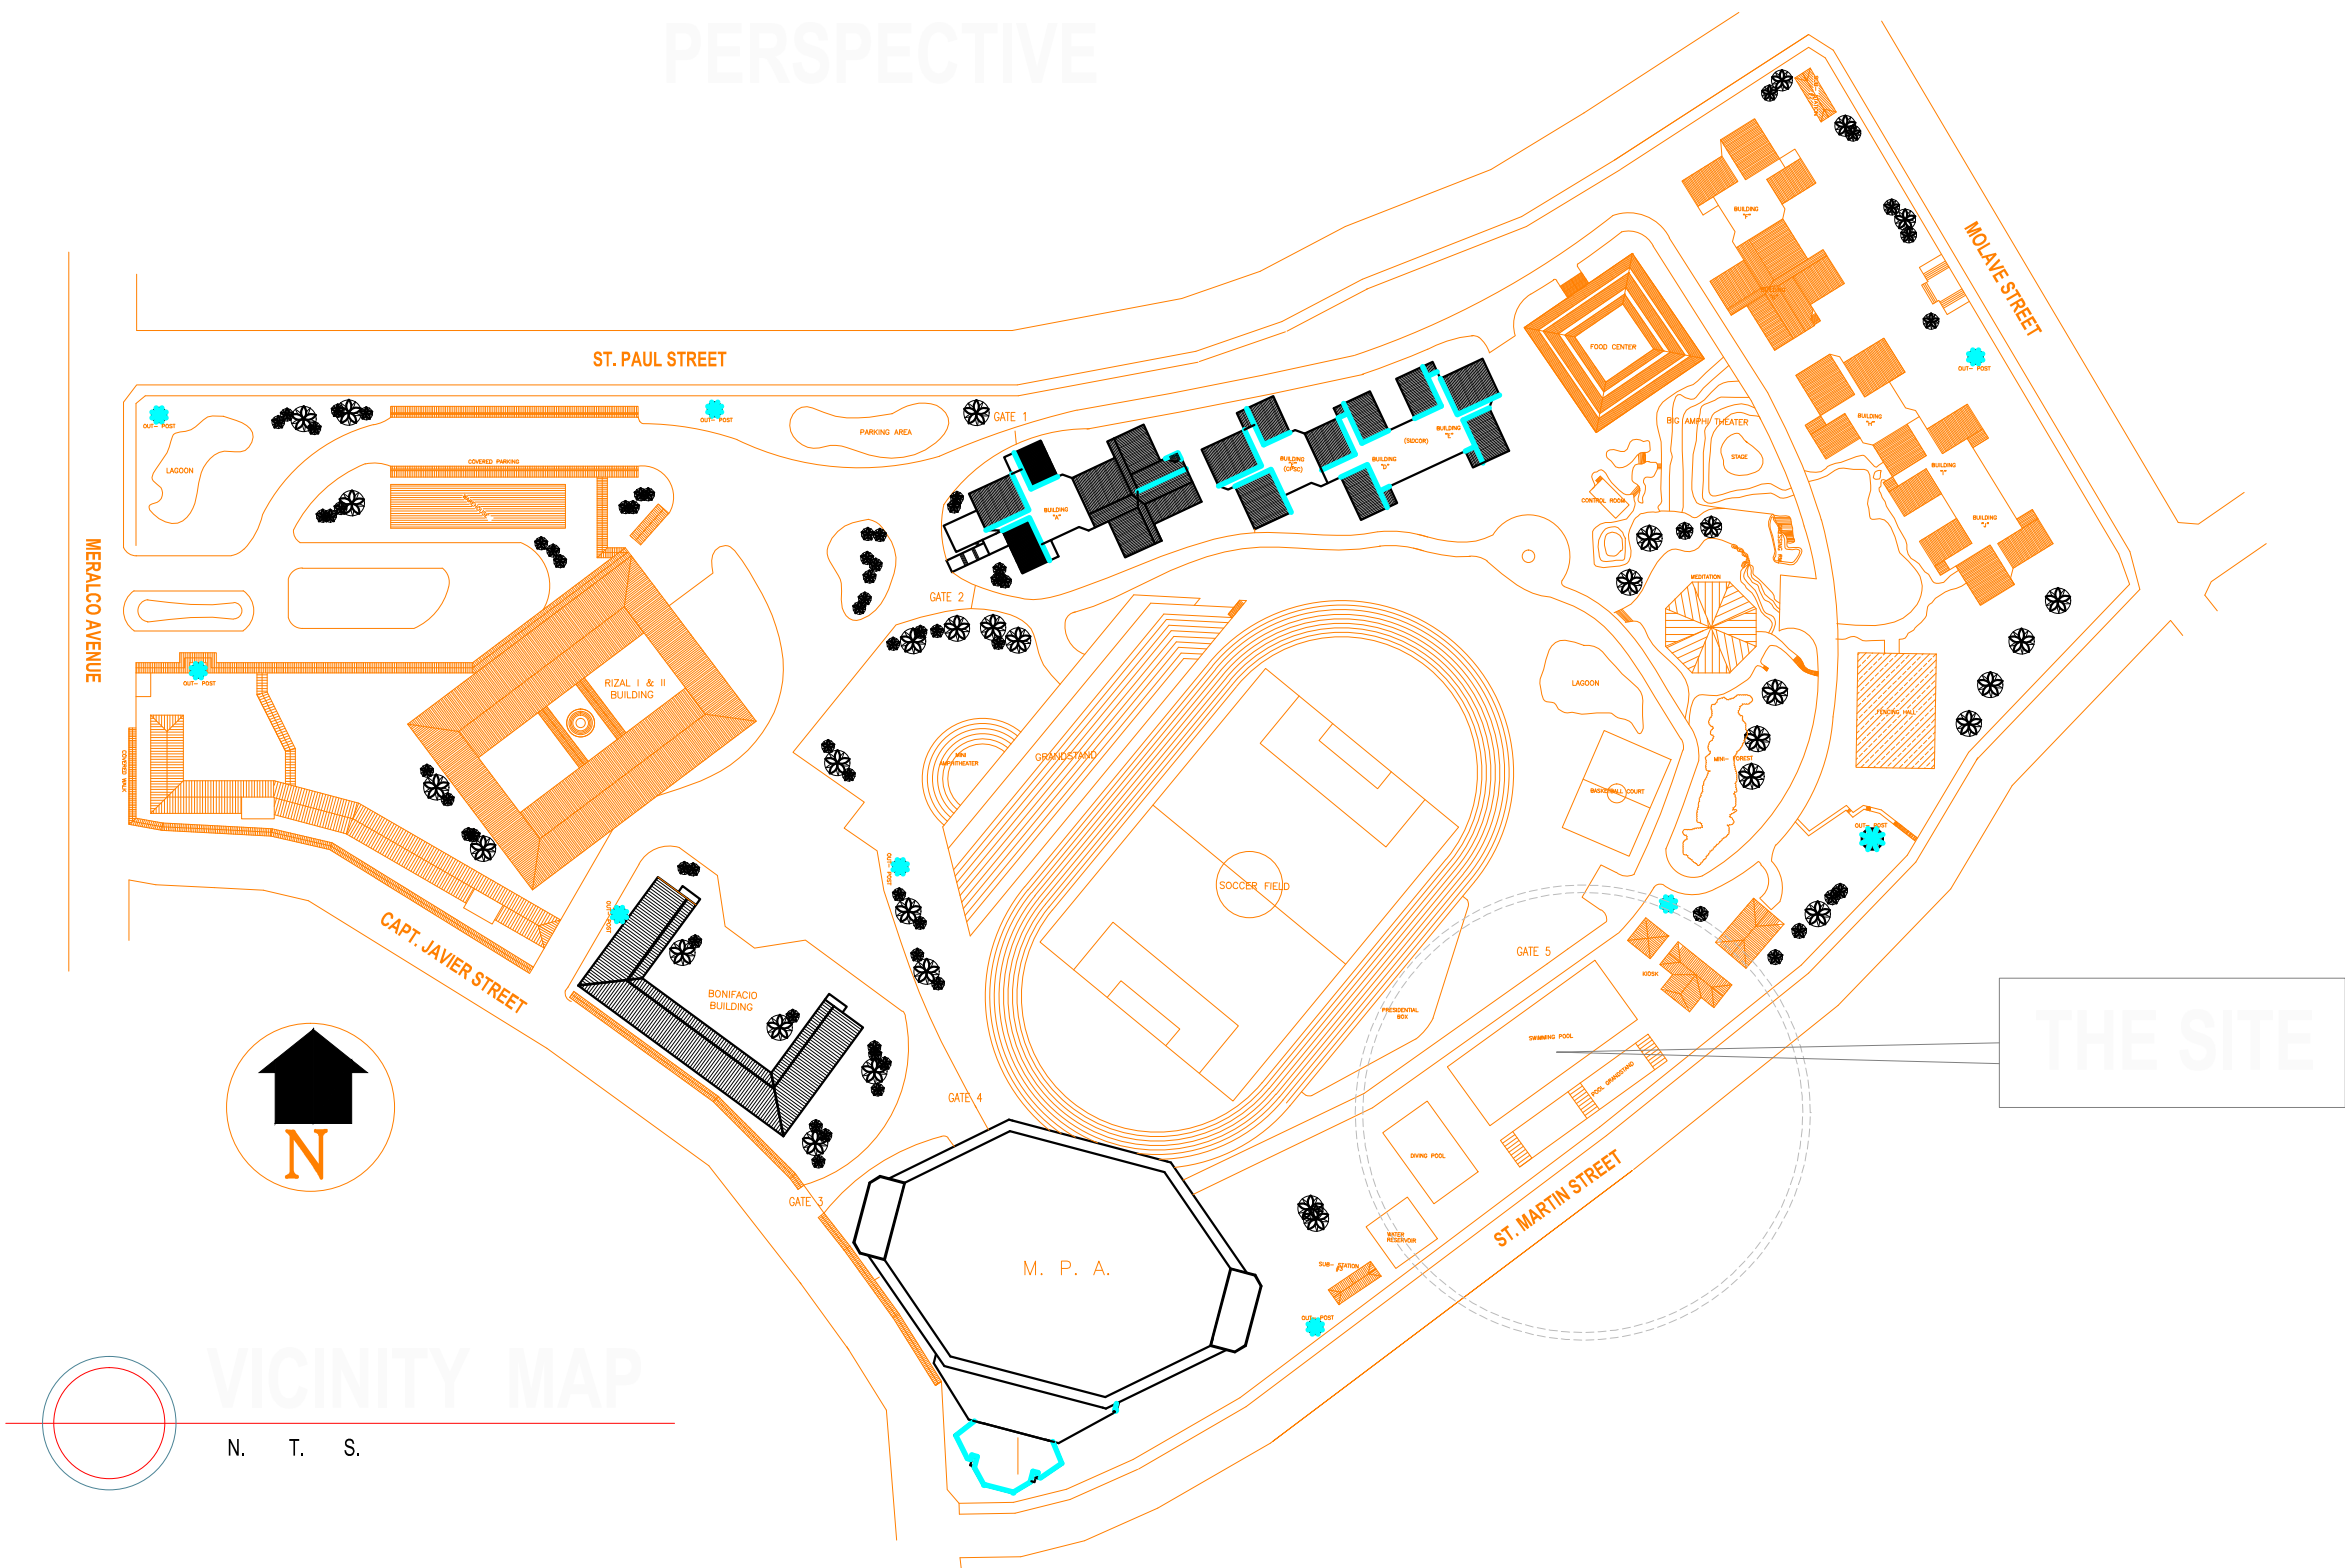


OWNER	PROJECT TITLE :	SUBMITTED BY :	RECOMMENDING APPROVAL :	APPROVED BY :	SHEET CONTENTS :	DESIGN BY :	SHEET NO :
 PHILIPPINE SPORTS COMMISSION RMSC, PABLO OCAMPO SR. ST., MALATE, MANILA	UPGRADING OF SWIMMING POOL, DIVING POOL, AND CONSTRUCTION OF NEW BLEACHERS, WARM UP POOL AND JACUZZI LOCATION: PHILSPORTS, ULTRA, MERALCO AVE., PASIG CITY	ENGR. PEDRO I. PINEDA JR. HEAD - ENGINEERING UNIT	DIR. MERLITA R. IBAY DEPUTY EXECUTIVE DIRECTOR	HON. WILLIAM I. RAMIREZ CHAIRMAN	AS SHOWN	DESIGN BY :	A 1
						DRAWN BY :	
						CHECKED BY :	
						DATE :	
						APPROVED BY :	

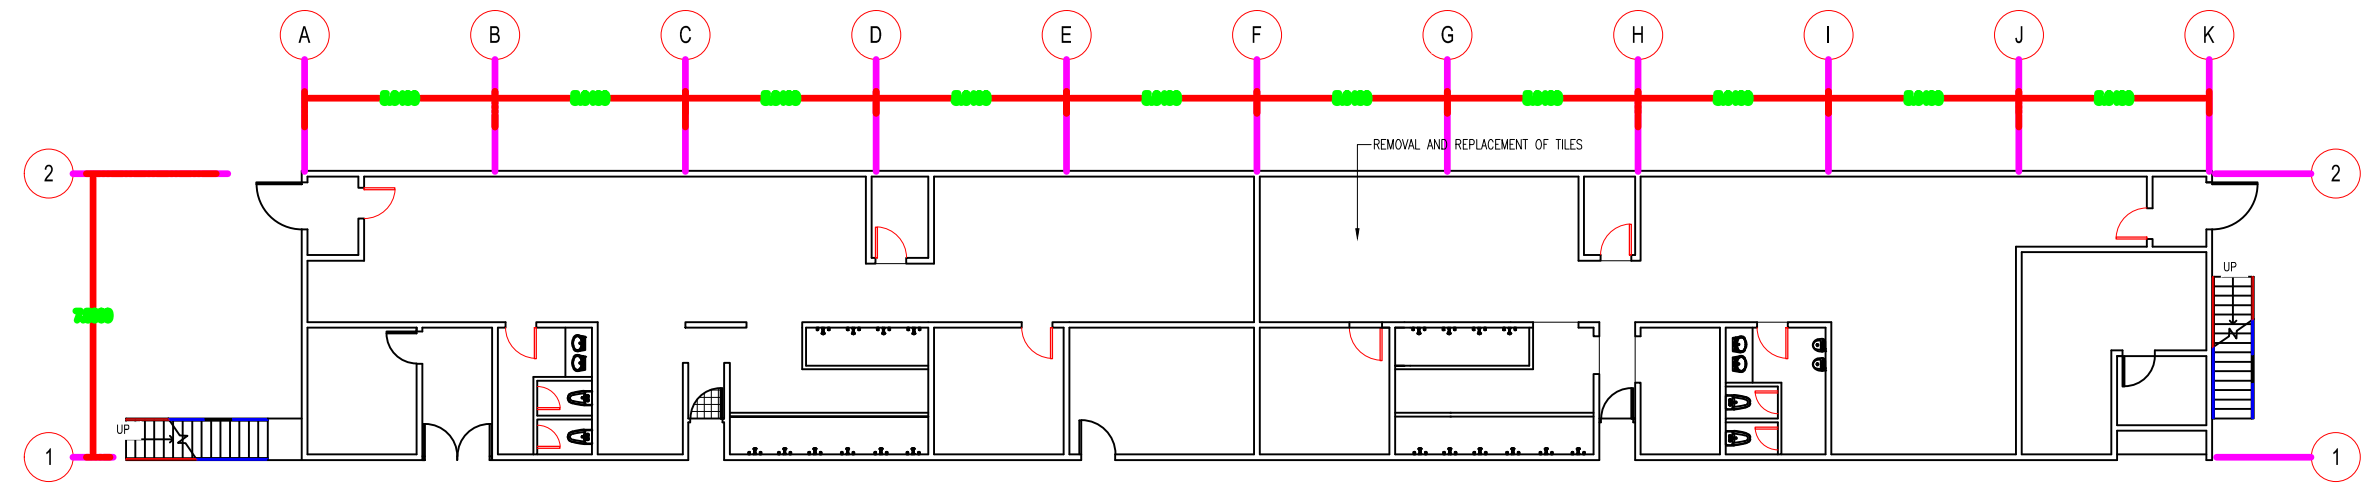

EXISTING GROUND FLOOR PLAN


SCALE 1 : 100 MTS.

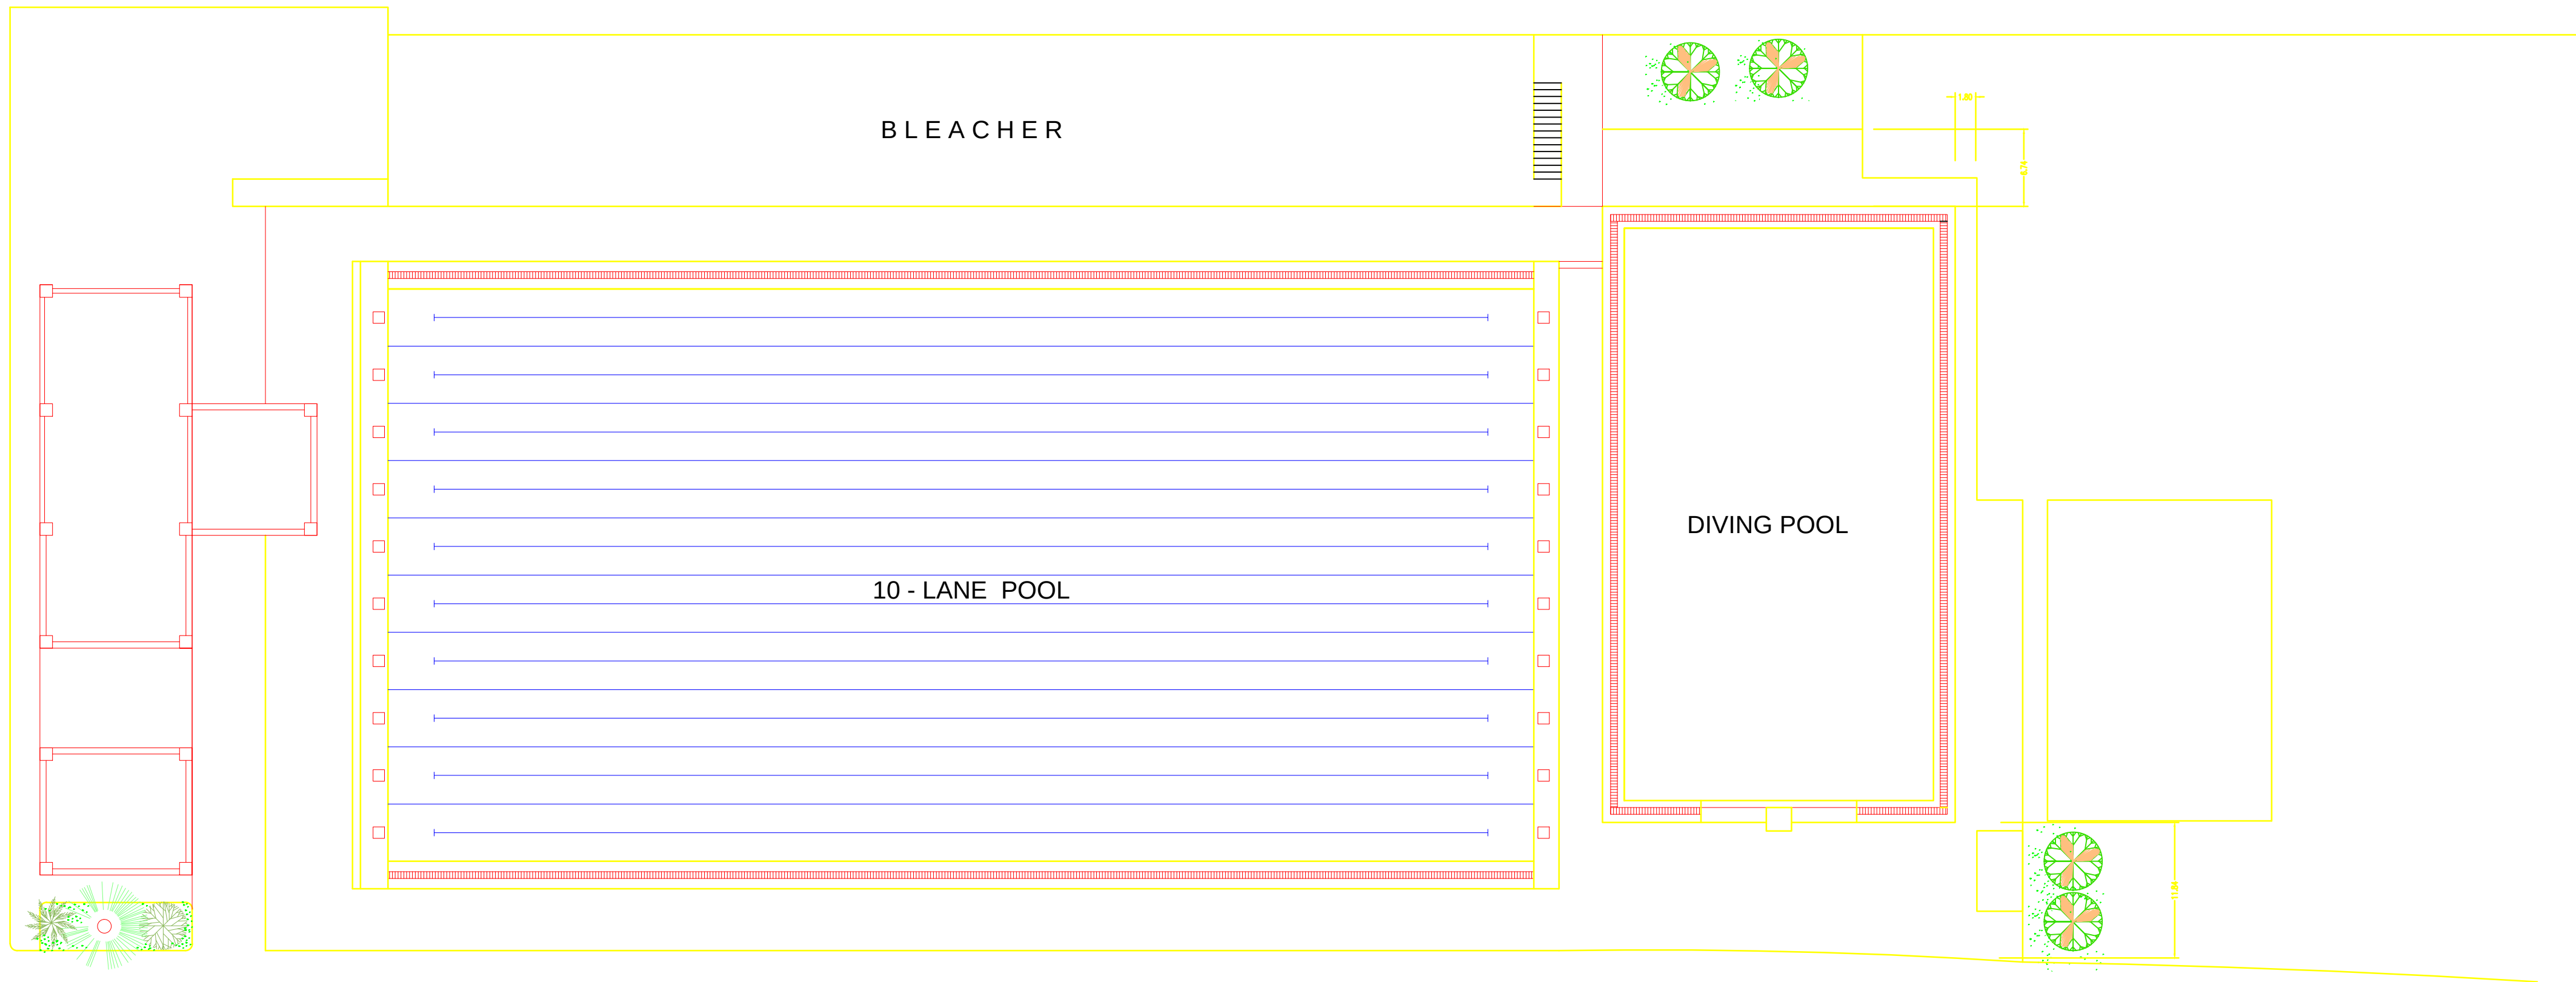



EXISTING BLEACHERS FLOOR PLAN

SCALE 1 : 100 MTS.

OWNER	PROJECT TITLE :	SUBMITTED BY :	RECOMMENDING APPROVAL :	APPROVED BY :	SHEET CONTENTS :	DESIGN BY :		SHEET NO :
 PHILIPPINE SPORTS COMMISSION RMSG, PABLO OCAMPO SR. ST., MALATE, MANILA	UPGRADING OF SWIMMING POOL, DIVING POOL, AND CONSTRUCTION OF NEW BLEACHERS, WARM UP POOL AND JACUZZI LOCATION: PHILSPORTS, ULTRA, MERALCO AVE., PASIG CITY	ENGR. PEDRO I. PINEDA JR. HEAD - ENGINEERING UNIT	DIR. MERLITA R. IBAY DEPUTY EXECUTIVE DIRECTOR	HON. WILLIAM I. RAMIREZ CHAIRMAN	AS SHOWN	DRAWN BY :		A 2
						CHECKED BY :		
						DATE :		
						APPROVED BY :		

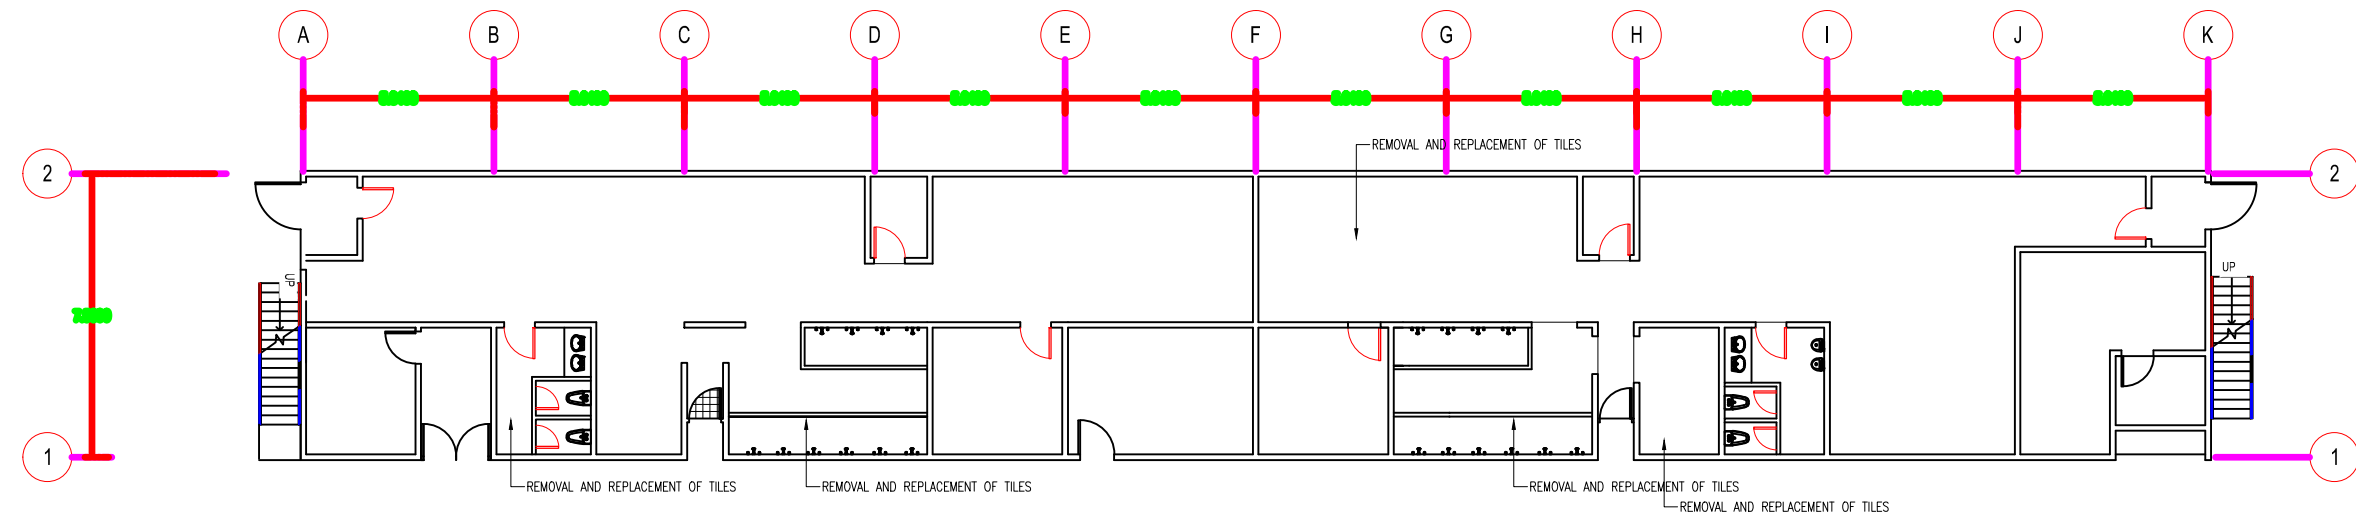


PROPOSED GROUND FLOOR PLAN
SCALE 1:100 MTS.

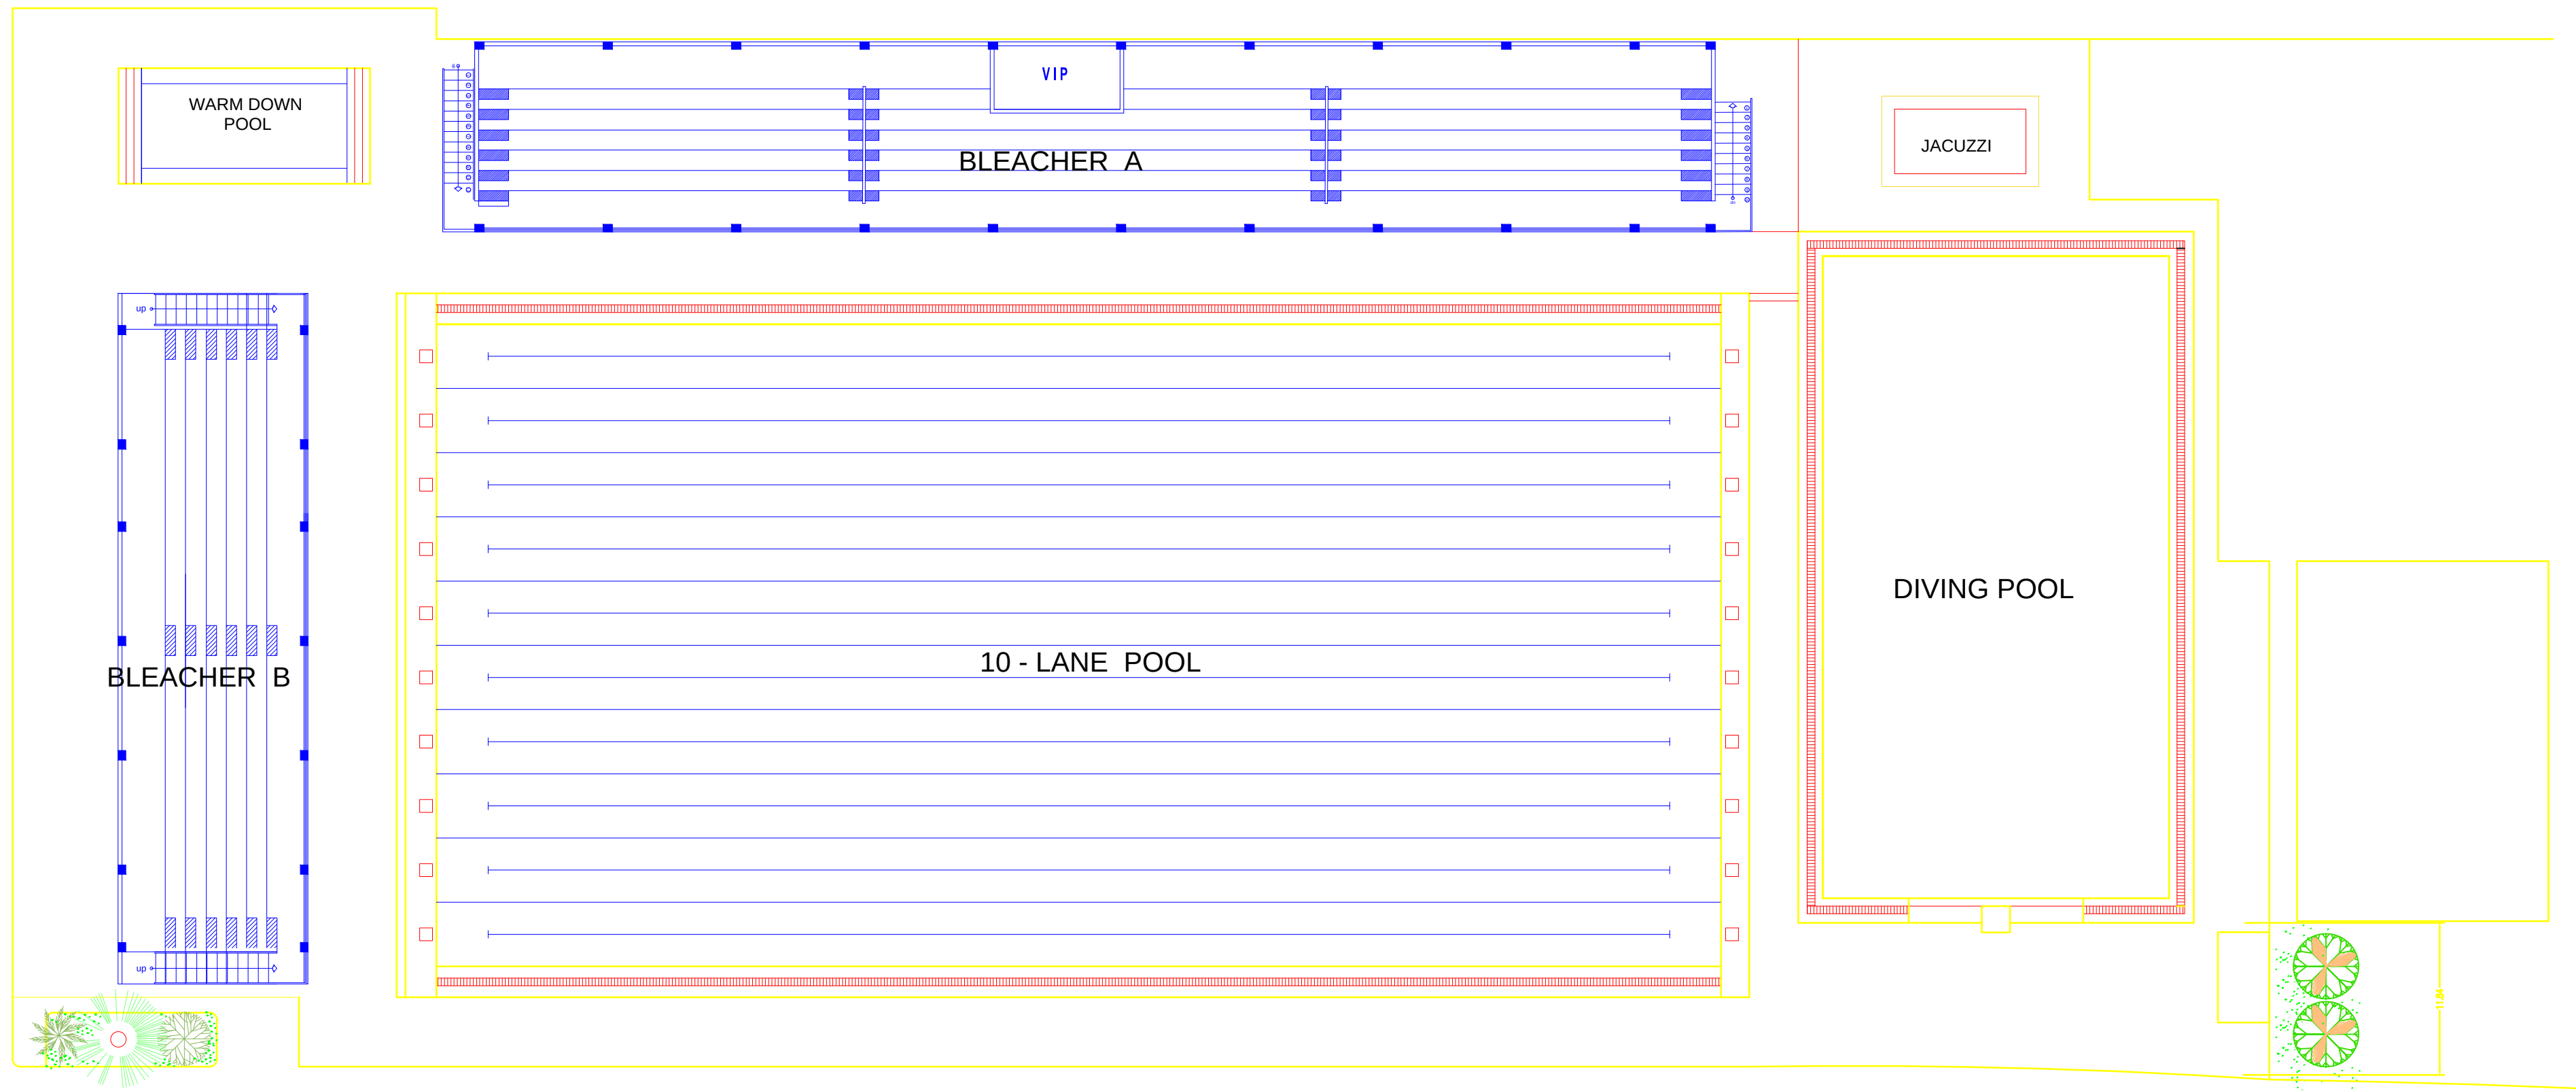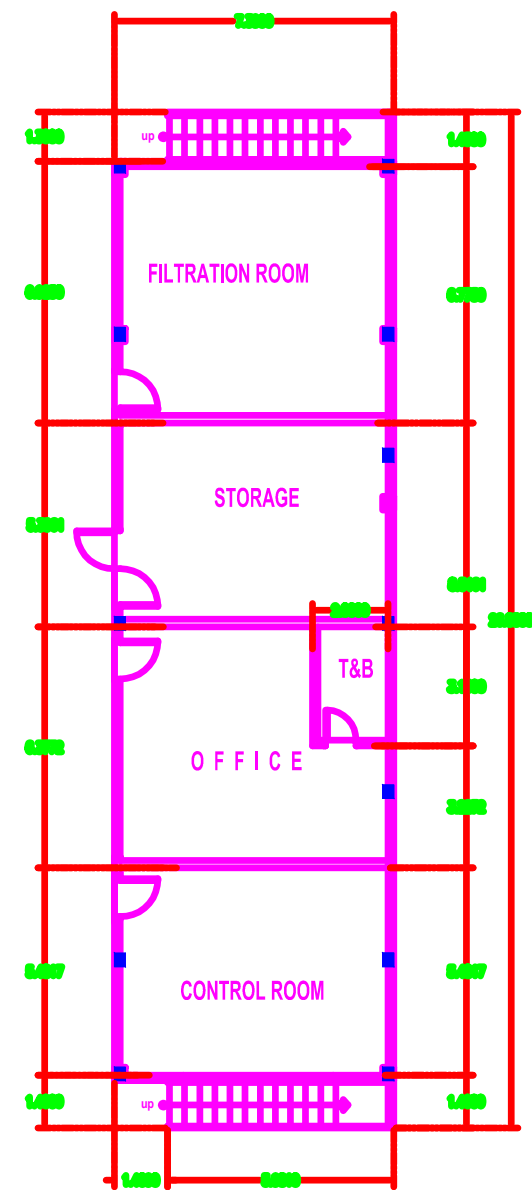


PROPOSED BLEACHERS FLOOR PLAN
SCALE 1:100 MTS.

PROPOSED GROUND FLOOR PLAN
SCALE 1:100 MTS.


OWNER	PROJECT TITLE :	SUBMITTED BY :	RECOMMENDING APPROVAL :	APPROVED BY :	SHEET CONTENTS :	DESIGN BY :		SHEET NO :
PHILIPPINE SPORTS COMMISSION RMSC, PABLO OCAMPO SR. ST., MALATE, MANILA	UPGRADING OF SWIMMING POOL, DIVING POOL, AND CONSTRUCTION OF NEW BLEACHERS, WARM UP POOL AND JACUZZI LOCATION: PHILSPORTS, ULTRA, MERALCO AVE., PASIG CITY	ENGR. PEDRO I. PINEDA JR. HEAD - ENGINEERING UNIT	DIR. MERLITA R. IBAY DEPUTY EXECUTIVE DIRECTOR	HON. WILLIAM I. RAMIREZ CHAIRMAN	AS SHOWN	DRAWN BY :		A 3
						CHECKED BY :		
						DATE :		
						APPROVED BY :		

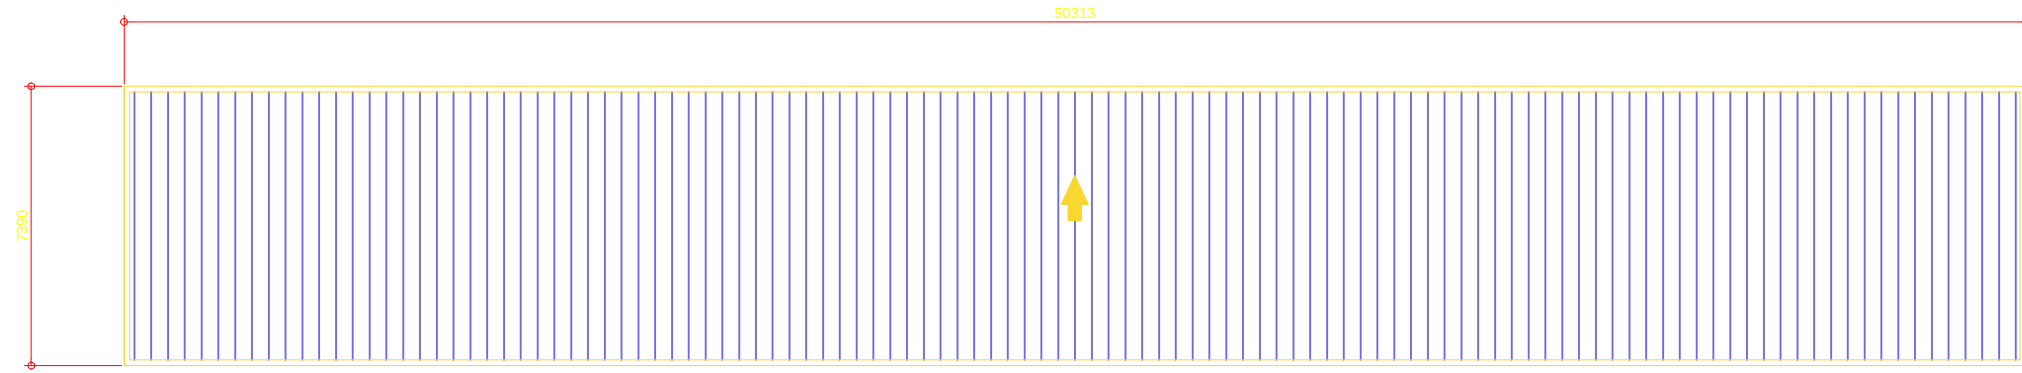


SCALE 1:100 MTS.

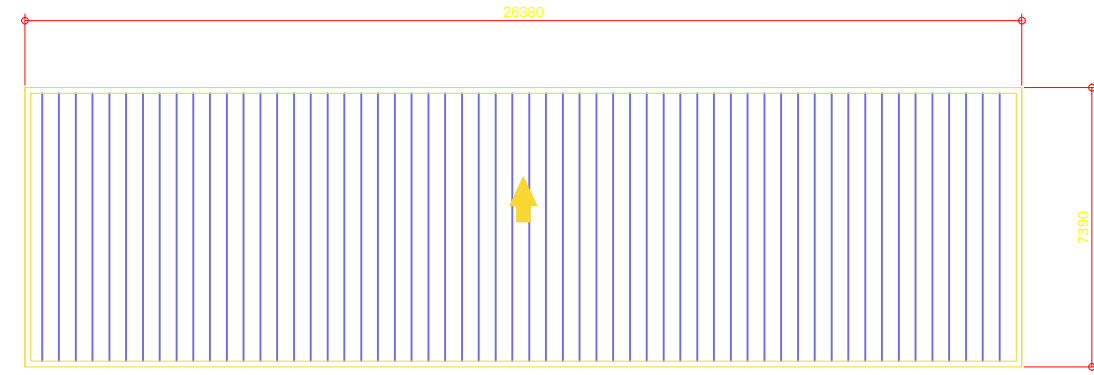


SCALE 1:100 MTS.

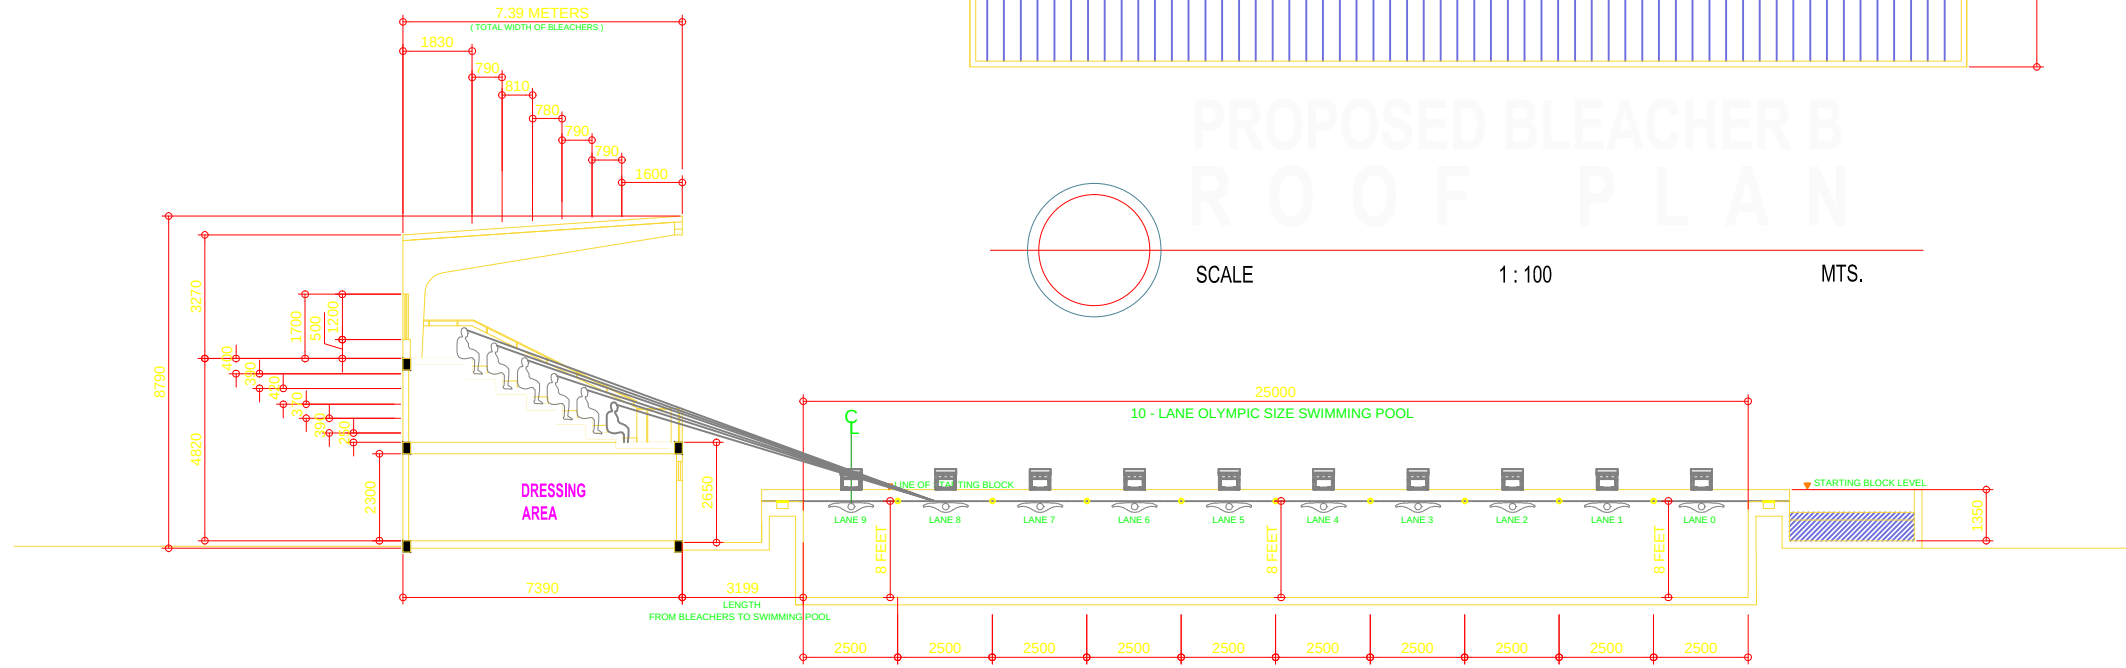


SCALE 1:100 MTS.

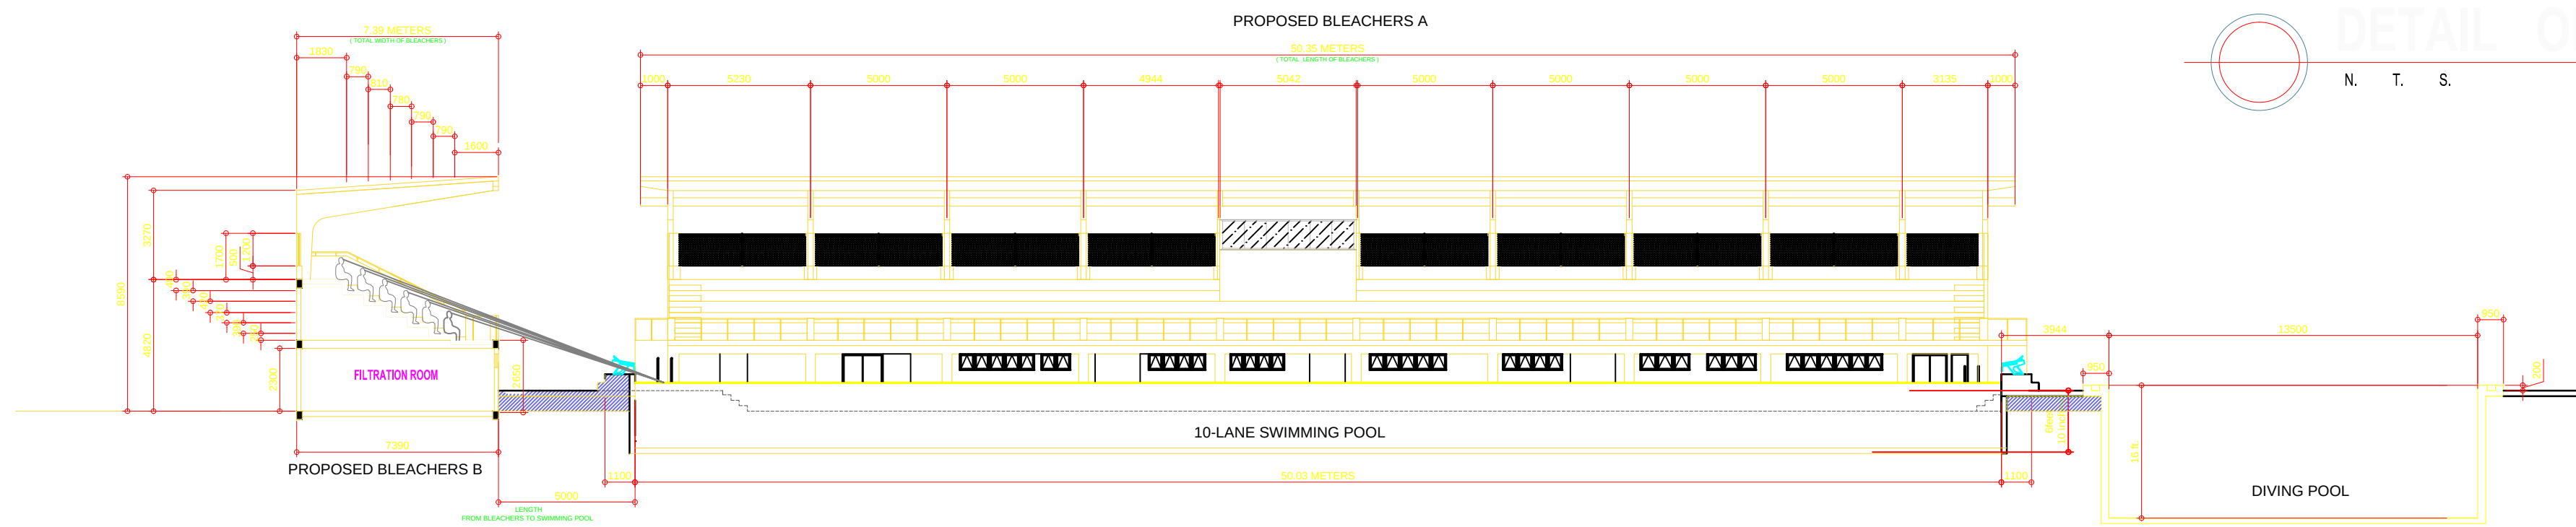


SCALE 1:100 MTS.

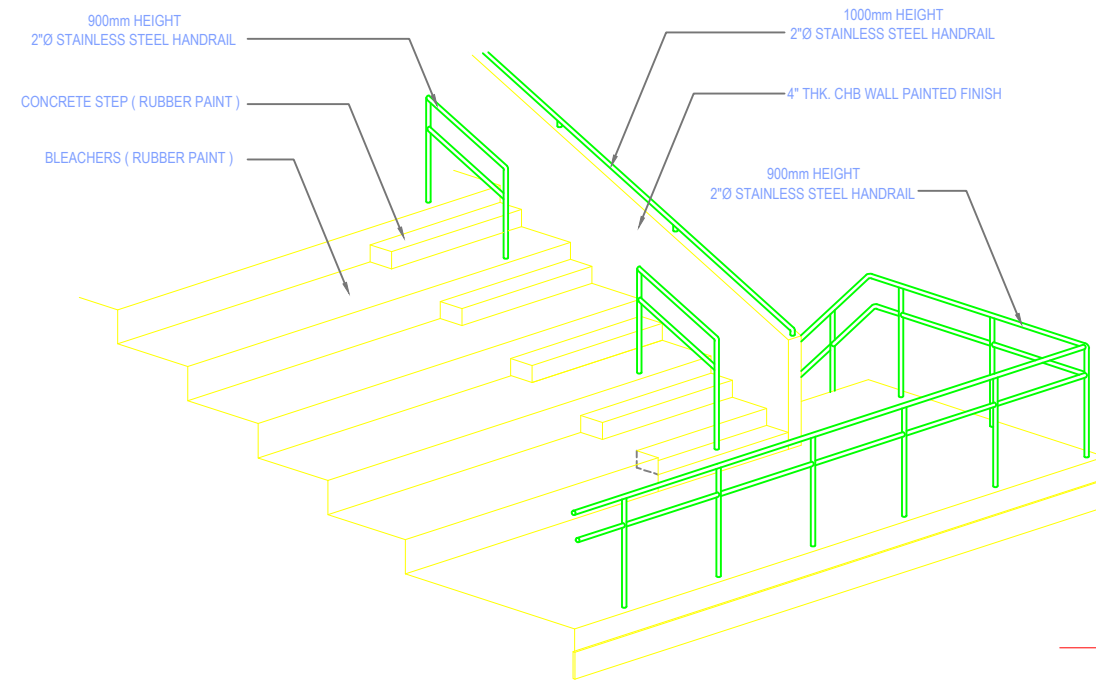


ISOMETRIC VIEW OF BLEACHERS

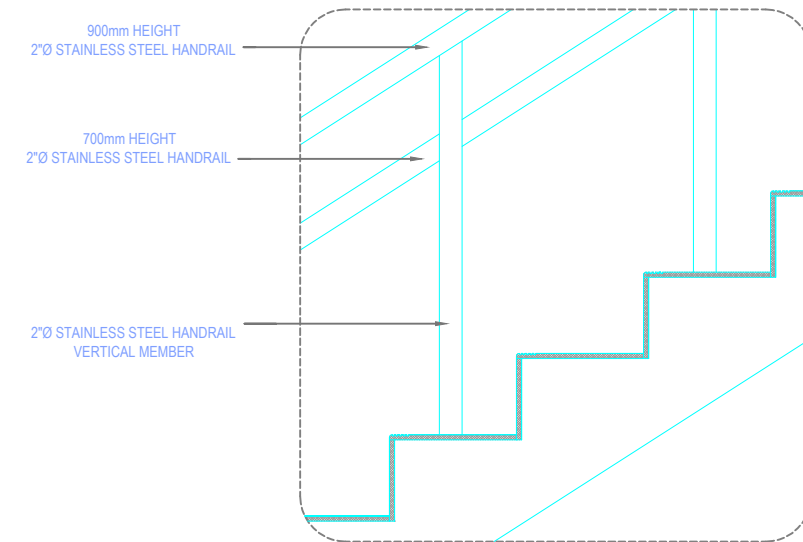

DETAIL OF RAILING

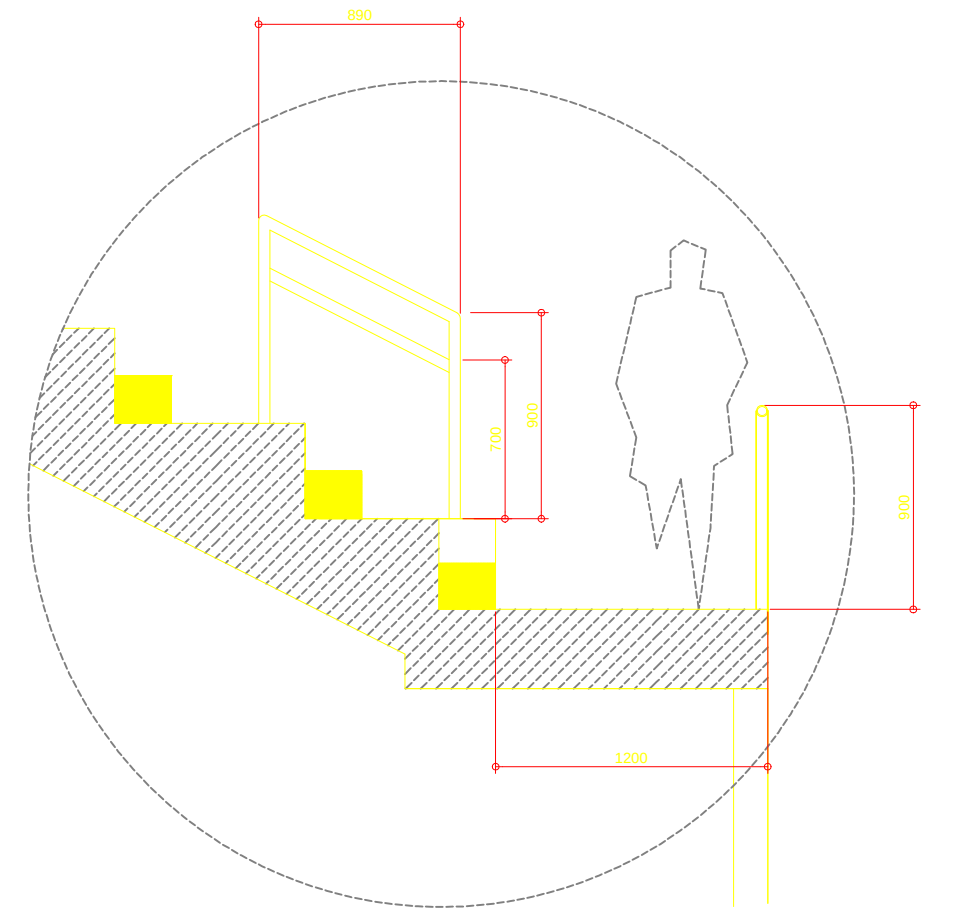



DETAIL OF RAILING @ BLEACHERS STEP


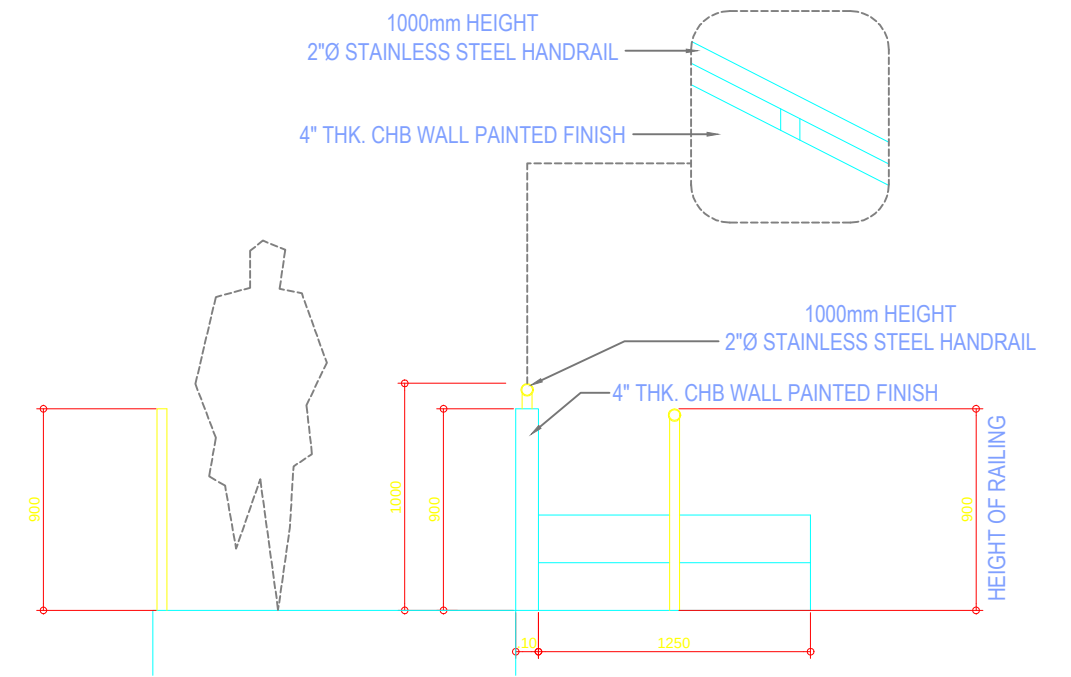


AREA OF BLEACHERS RAILING

OWNER	PROJECT TITLE :	SUBMITTED BY :	RECOMMENDING APPROVAL :	APPROVED BY :	SHEET CONTENTS :	DESIGN BY :		SHEET NO :
PHILIPPINE SPORTS COMMISSION RMSC, PABLO OCAMPO SR. ST., MALATE, MANILA	UPGRADING OF SWIMMING POOL, DIVING POOL, AND CONSTRUCTION OF NEW BLEACHERS, WARM UP POOL AND JACUZZI LOCATION: PHILSPORTS, ULTRA, MERALCO AVE., PASIG CITY	ENGR. PEDRO I. PINEDA JR. HEAD - ENGINEERING UNIT	DIR. MERLITA R. IBAY DEPUTY EXECUTIVE DIRECTOR	HON. WILLIAM I. RAMIREZ CHAIRMAN	AS SHOWN	DRAWN BY :		A 4
						CHECKED BY :		
						DATE :		
						APPROVED BY :		

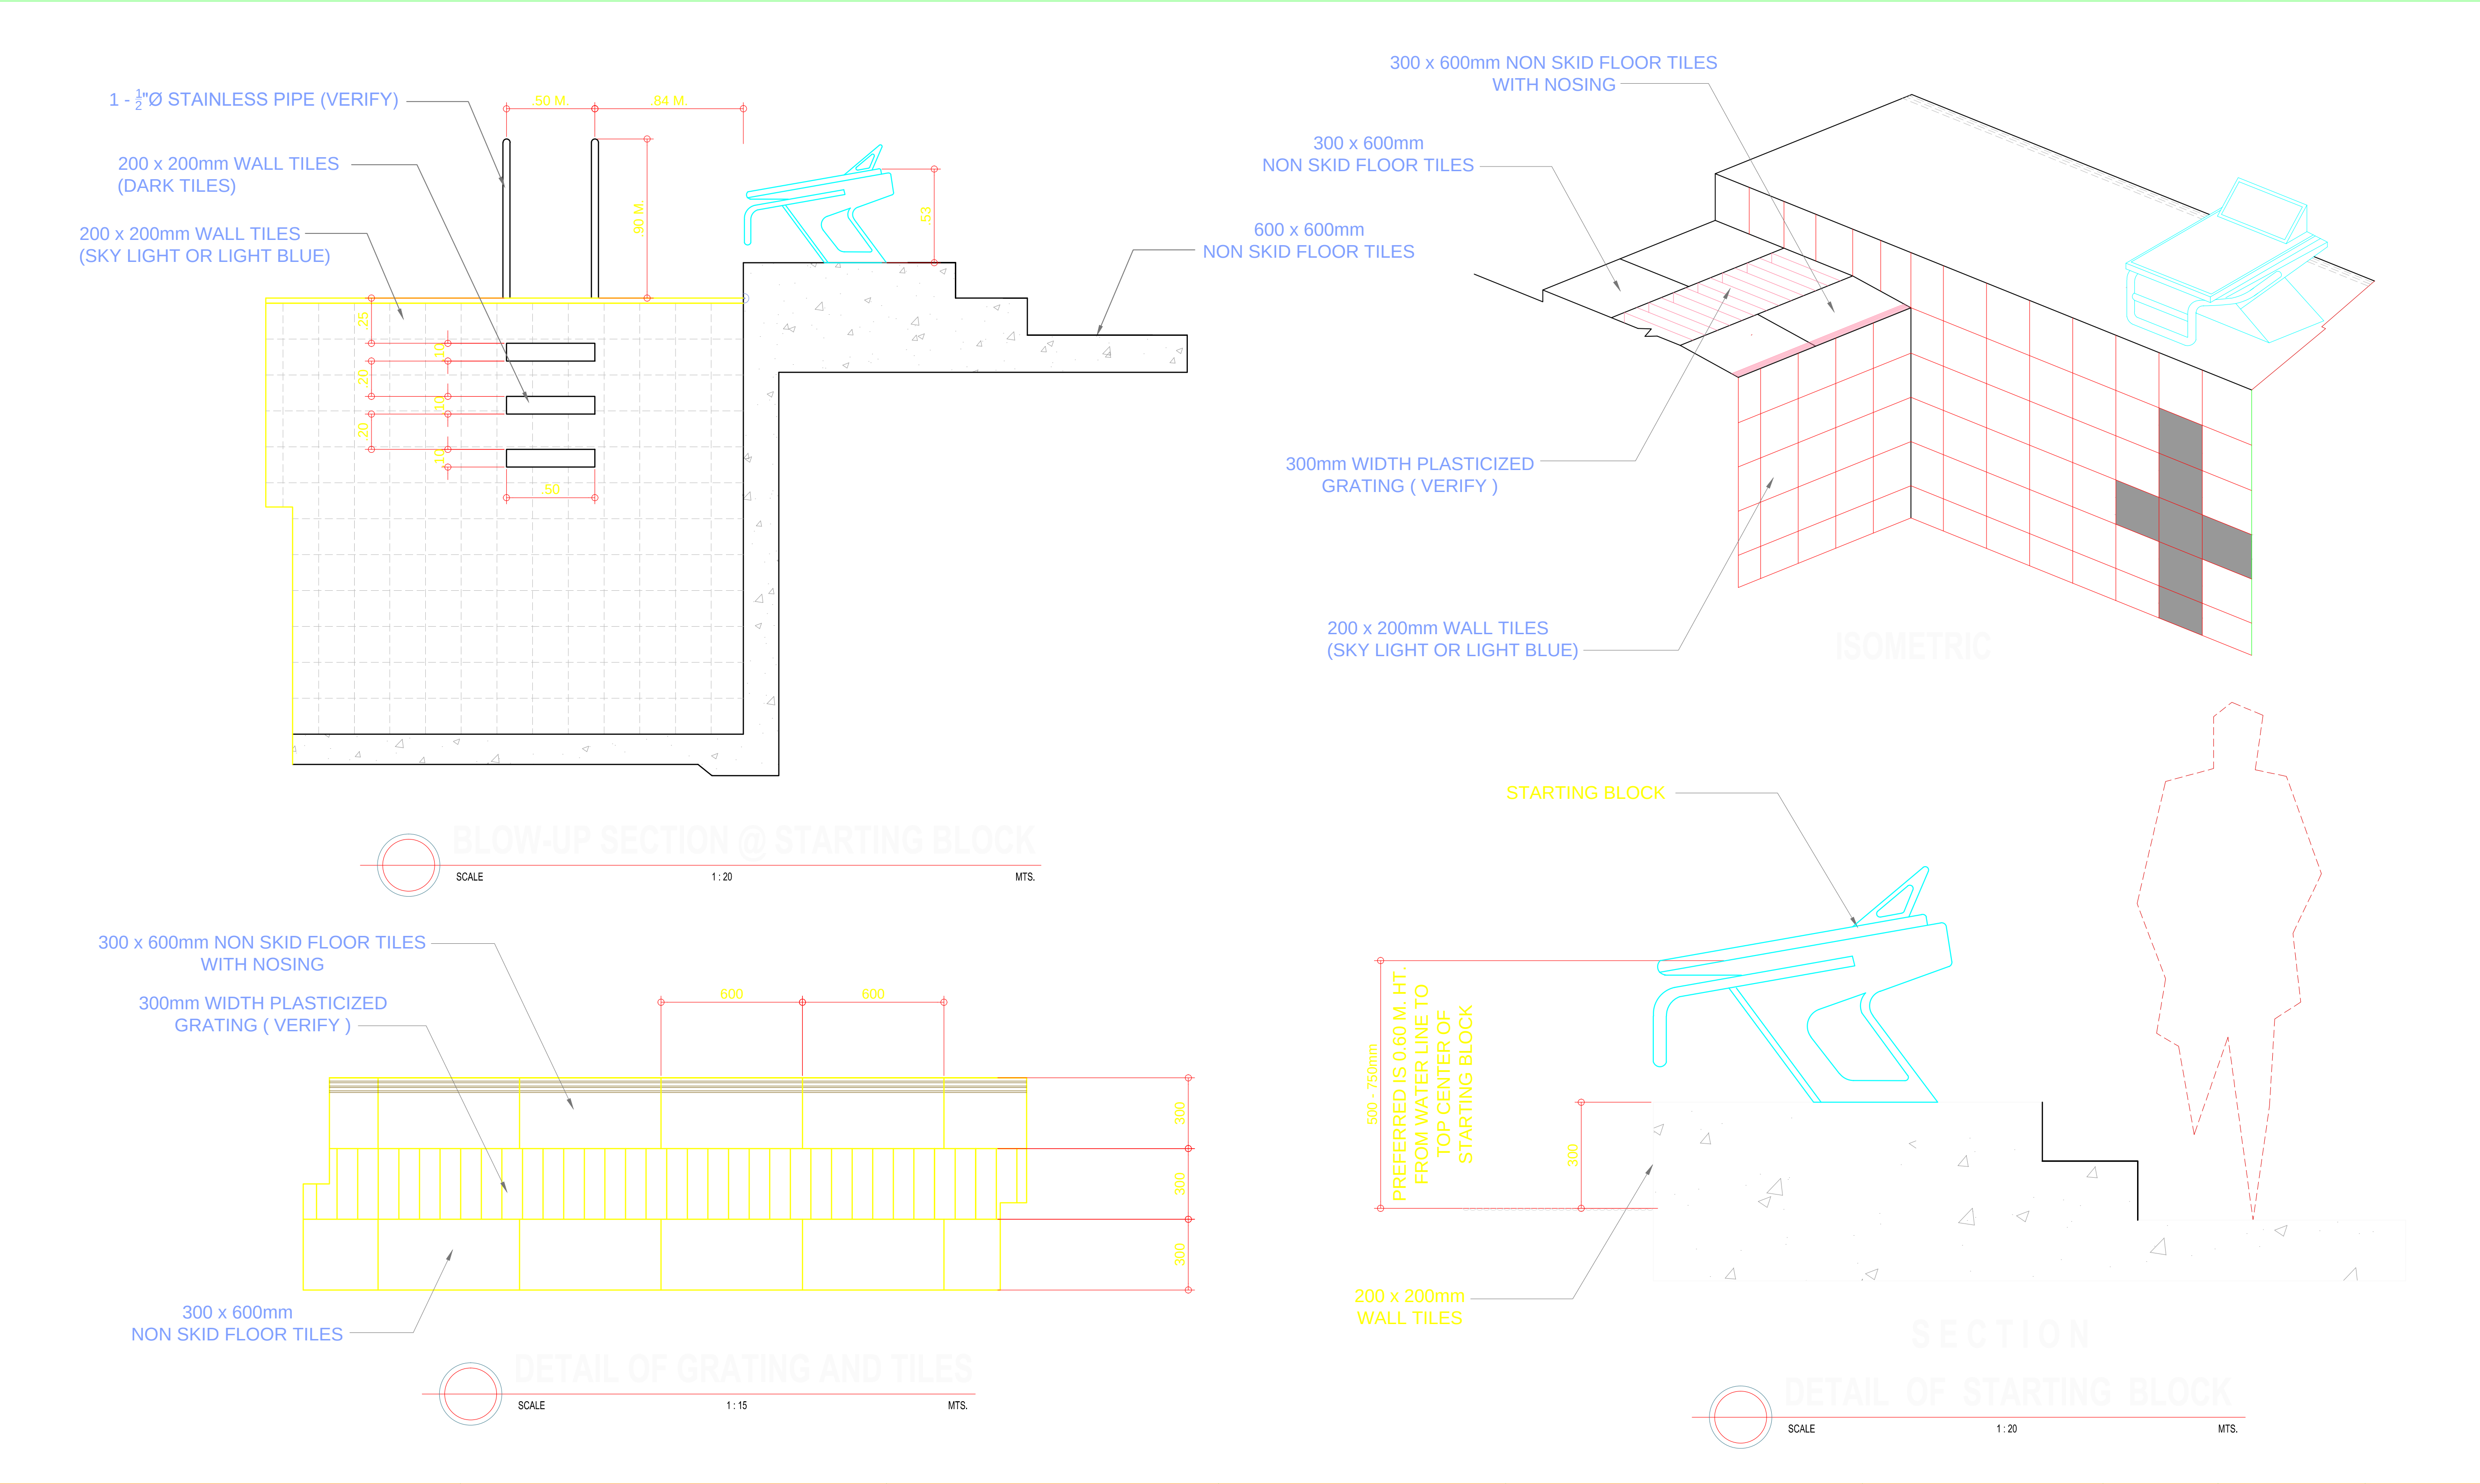

 OWNER	PROJECT TITLE :	SUBMITTED BY :	RECOMMENDING APPROVAL :	APPROVED BY :	SHEET CONTENTS :	DESIGN BY :	SHEET NO :
 PHILIPPINE SPORTS COMMISSION RMSC, PABLO OCAMPO SR. ST., MALATE, MANILA	UPGRADING OF SWIMMING POOL, DIVING POOL, AND CONSTRUCTION OF NEW BLEACHERS, WARM UP POOL AND JACUZZI LOCATION: PHILSPORTS, ULTRA, MERALCO AVE., PASIG CITY	ENGR. PEDRO I. PINEDA JR. HEAD - ENGINEERING UNIT	DIR. MERLITA R. IBAY DEPUTY EXECUTIVE DIRECTOR	HON. WILLIAM I. RAMIREZ CHAIRMAN	AS SHOWN	DRAWN BY :	A 6
						CHECKED BY :	
						DATE :	
						APPROVED BY :	

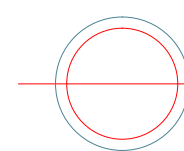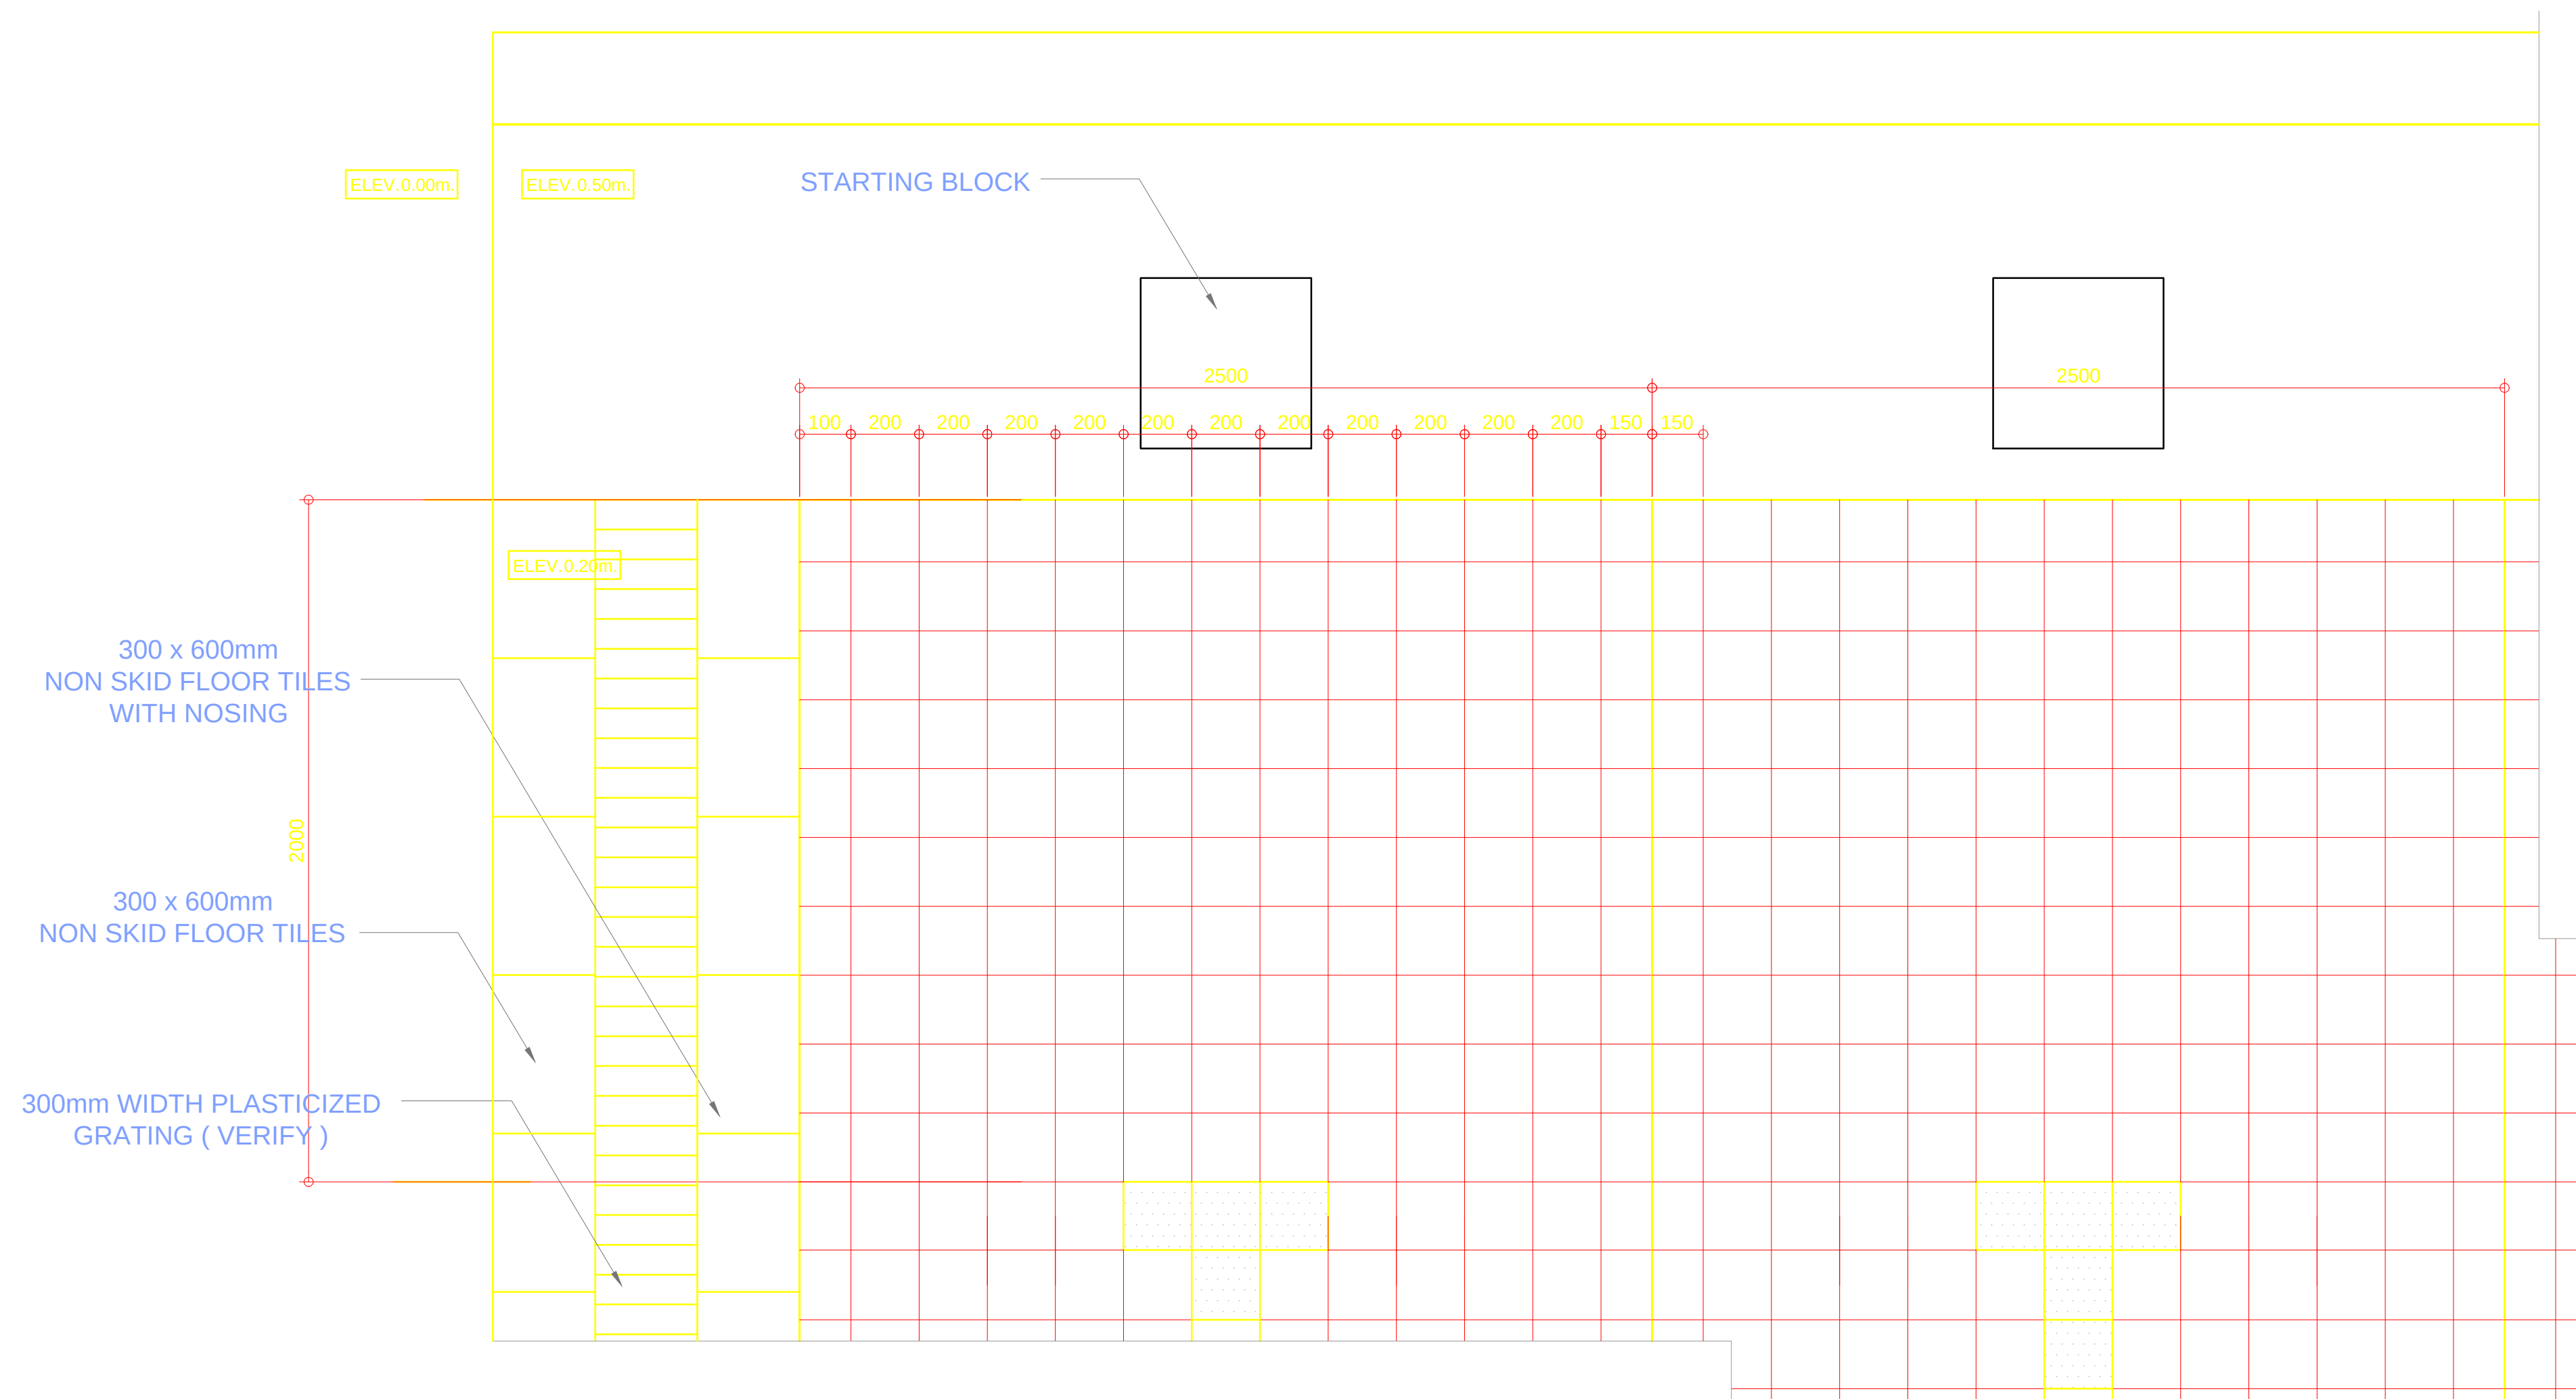

1:15

MTS.

OWNER	PROJECT TITLE :	SUBMITTED BY :	RECOMMENDING APPROVAL :	APPROVED BY :	SHEET CONTENTS :	DESIGN BY :	SHEET NO :
 PHILIPPINE SPORTS COMMISSION RMSC, PABLO OCAMPO SR. ST., MALATE, MANILA	UPGRADING OF SWIMMING POOL, DIVING POOL, AND CONSTRUCTION OF NEW BLEACHERS, WARM UP POOL AND JACUZZI LOCATION: PHILSPORTS, ULTRA, MERALCO AVE., PASIG CITY	ENGR. PEDRO I. PINEDA JR. HEAD - ENGINEERING UNIT	DIR. MERLITA R. IBAY DEPUTY EXECUTIVE DIRECTOR	HON. WILLIAM I. RAMIREZ CHAIRMAN	AS SHOWN	DRAWN BY :	A 7
						CHECKED BY :	
						DATE :	
						APPROVED BY :	

PROJECT TITLE :

SUBMITTED BY :

RECOMMENDING APPROVAL:

APPROVED BY :

SHEET CONTENTS :

DESIGN BY :

SHEET NO :



RMSC, PABLO OCAMPO SR. ST., MALATE, MANILA

UPGRADING OF SWIMMING POOL, DIVING POOL,
AND CONSTRUCTION OF NEW BLEACHERS,
WARM UP POOL AND JACUZZI

ENGR. PEDRO I. PINEDA JR.

HEAD - ENGINEERING UNIT

DIR. MERLITA R. IBAY

DEPUTY EXECUTIVE DIRECTOR

HON. WILLIAM I. RAMIREZ

CHAIRMAN

AS SHOWN

DRAWN BY :

CHECKED BY :


DATE : _____

APPROVED BY :


A

7


NOTE:
1. THE FLOATER OR LANE LINE SHALL BE ANTI-WAVE
AND WITH APPROPRIATE CLAMP ROPE HOOK.




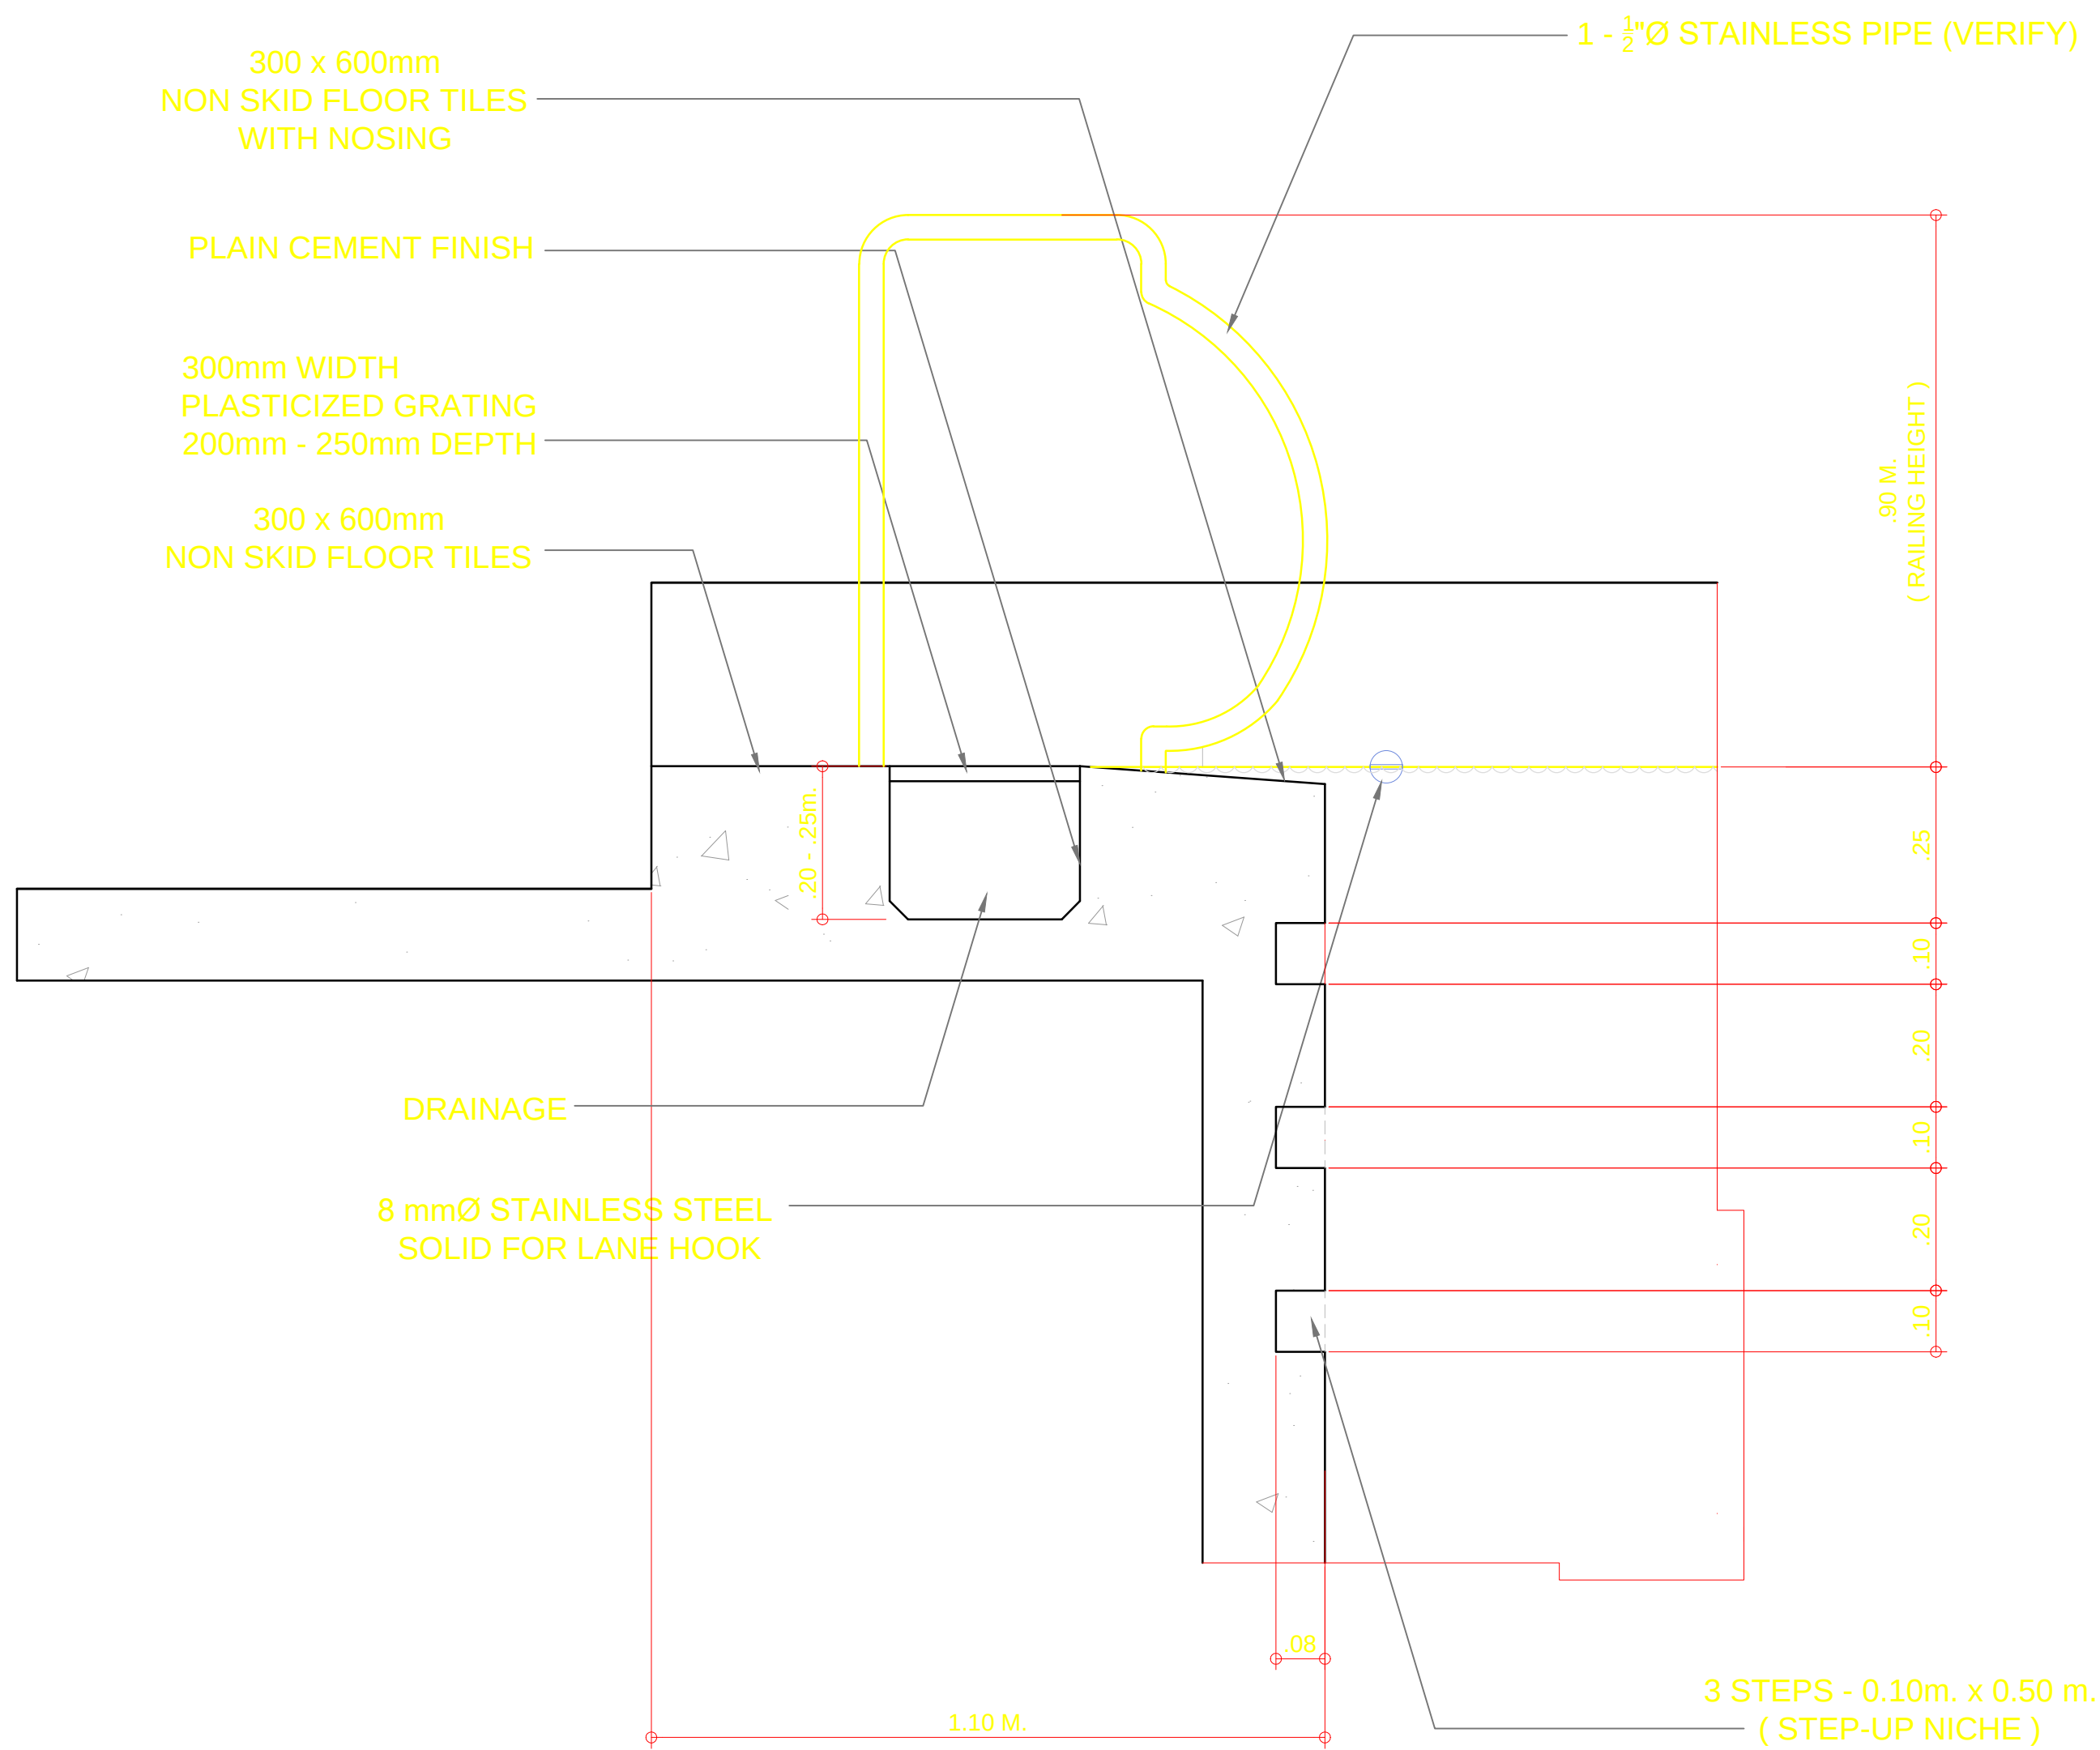


DETAIL OF RAILING AND POOL STEPS
SCALE 1:10 MTS.

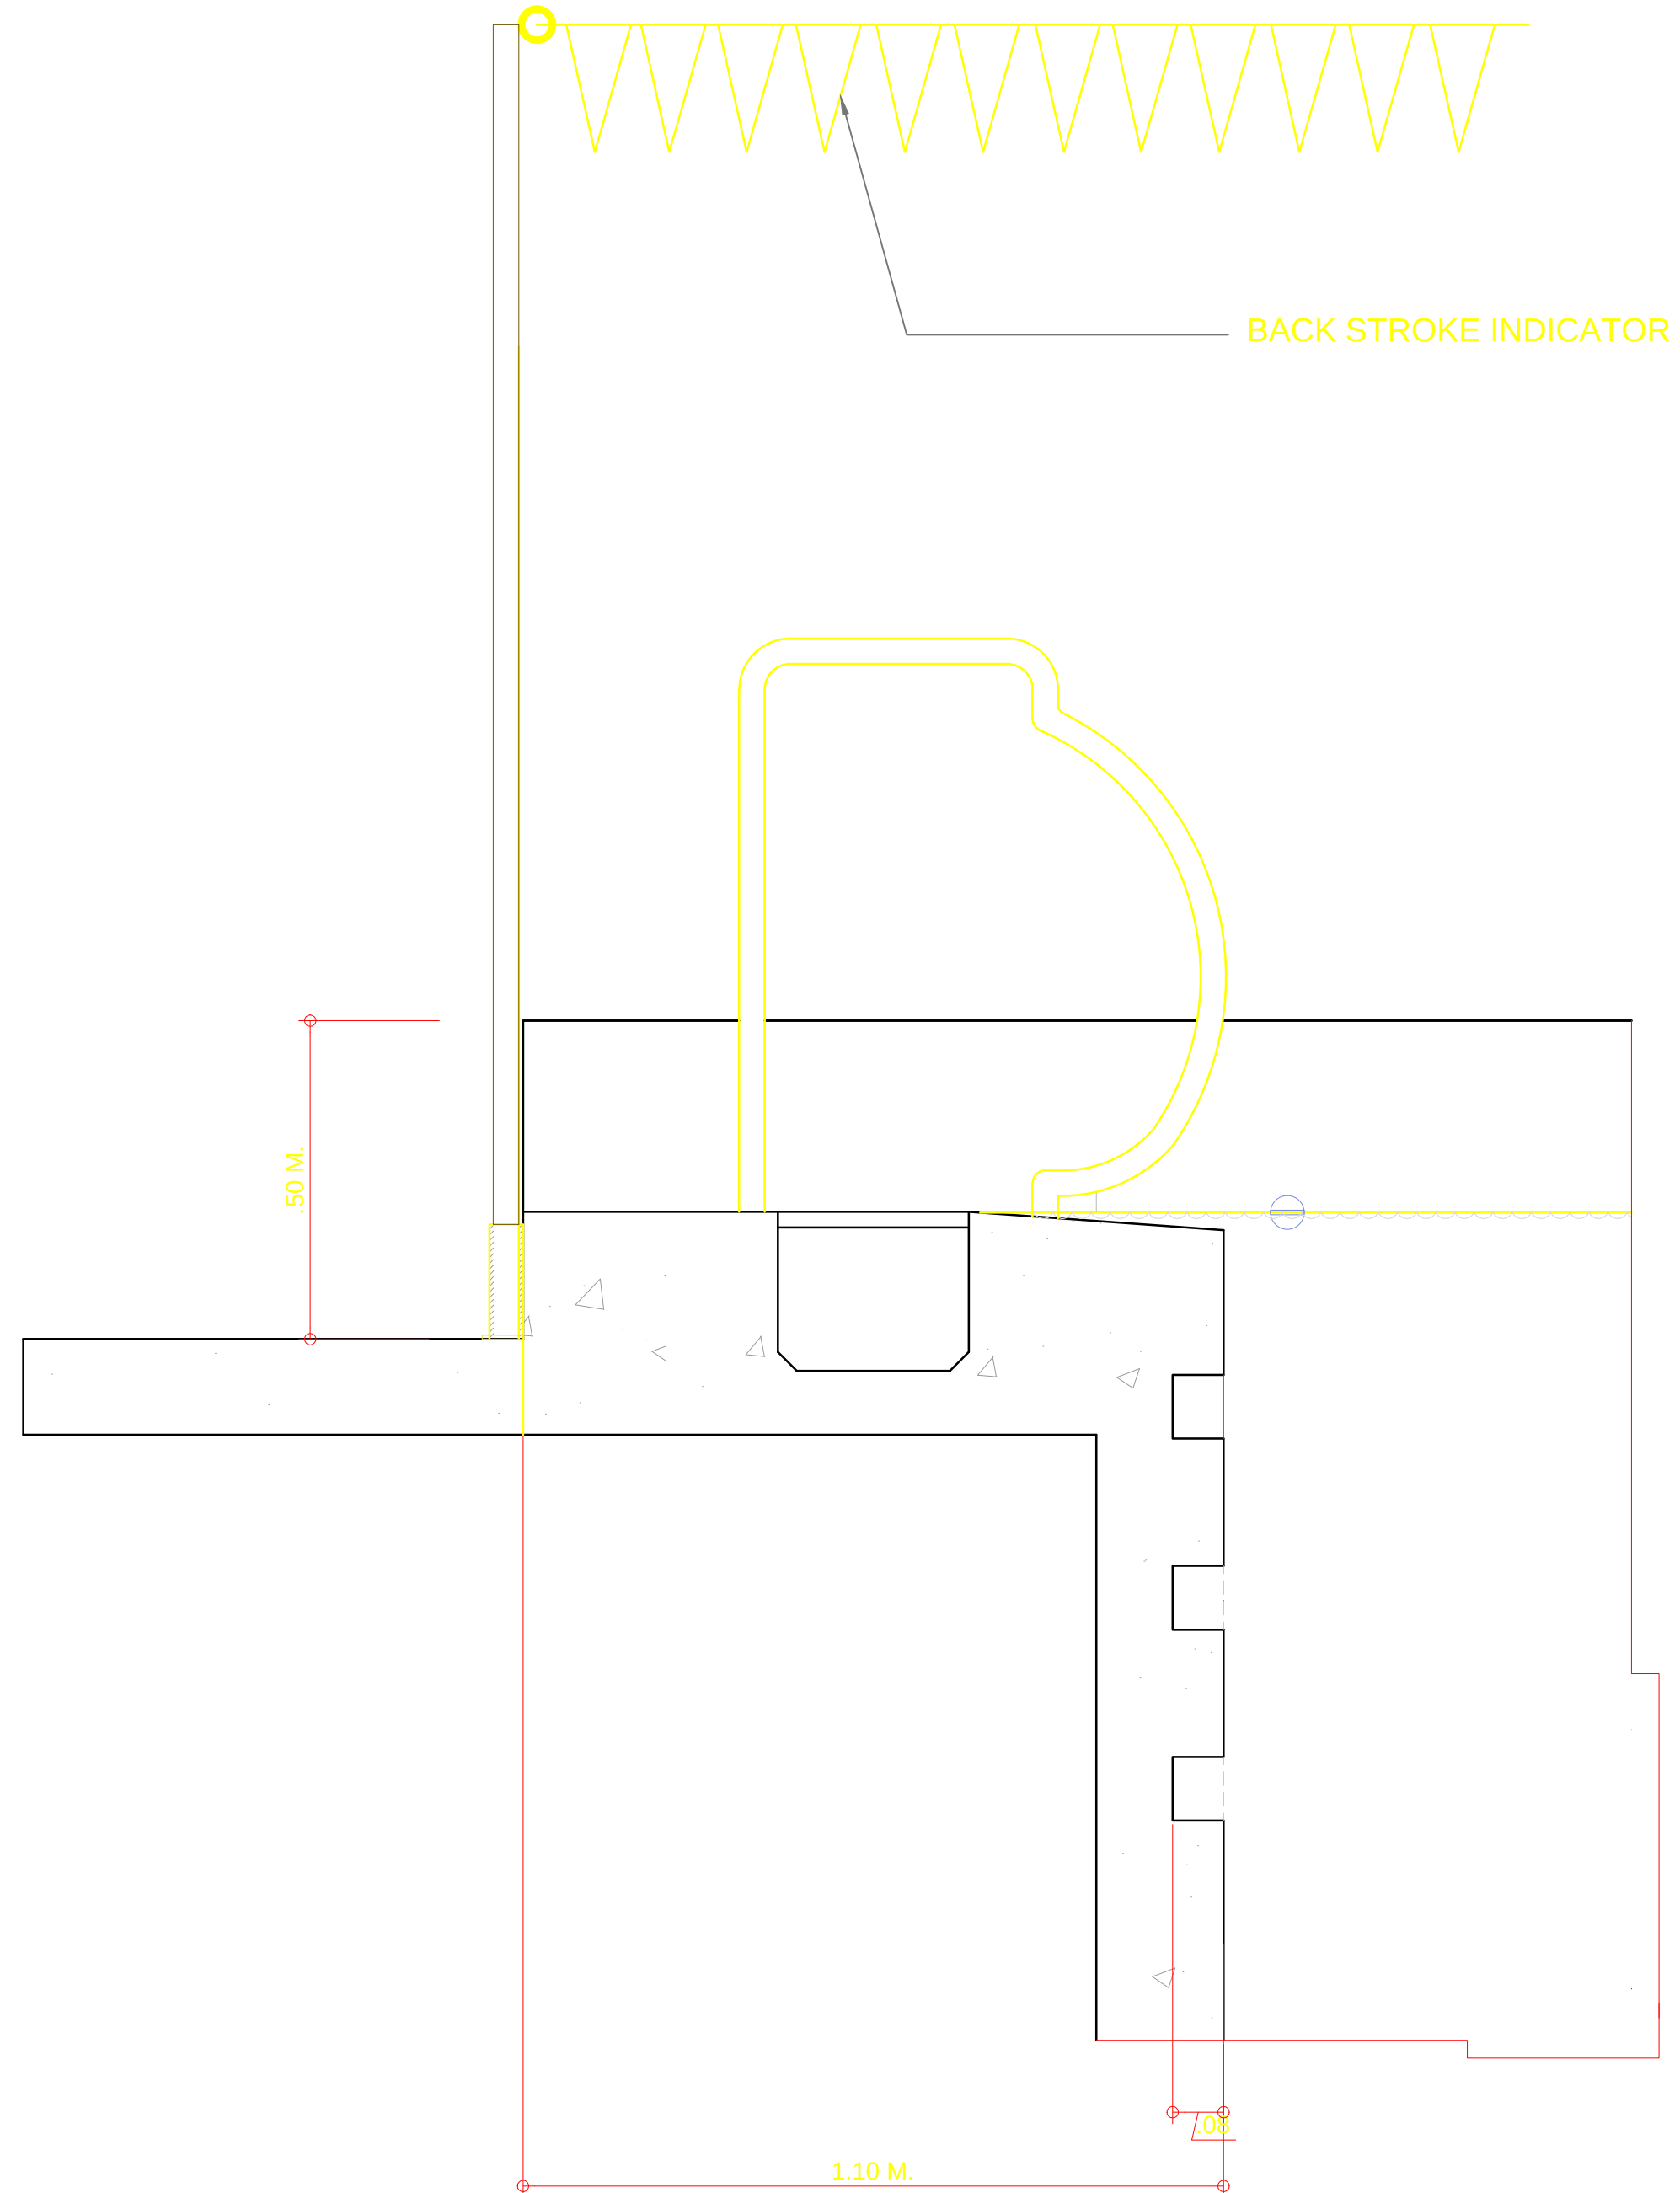


BACKSTROKE INDICATOR
SCALE 1:10 MTS.

 
OWNER	PROJECT TITLE :	SUBMITTED BY :	RECOMMENDING APPROVAL :	APPROVED BY :	SHEET CONTENTS :	DESIGN BY :		SHEET NO :
 PHILIPPINE SPORTS COMMISSION RMSC, PABLO OCAMPO SR. ST., MALATE, MANILA	UPGRADING OF SWIMMING POOL, DIVING POOL, AND CONSTRUCTION OF NEW BLEACHERS, WARM UP POOL AND JACUZZI LOCATION: PHILSPORTS, ULTRA, MERALCO AVE., PASIG CITY	ENGR. PEDRO I. PINEDA JR. HEAD - ENGINEERING UNIT	DIR. MERLITA R. IBAY DEPUTY EXECUTIVE DIRECTOR	HON. WILLIAM I. RAMIREZ CHAIRMAN	AS SHOWN	DRAWN BY :		A 8
						CHECKED BY :		
						DATE :		
						APPROVED BY :		

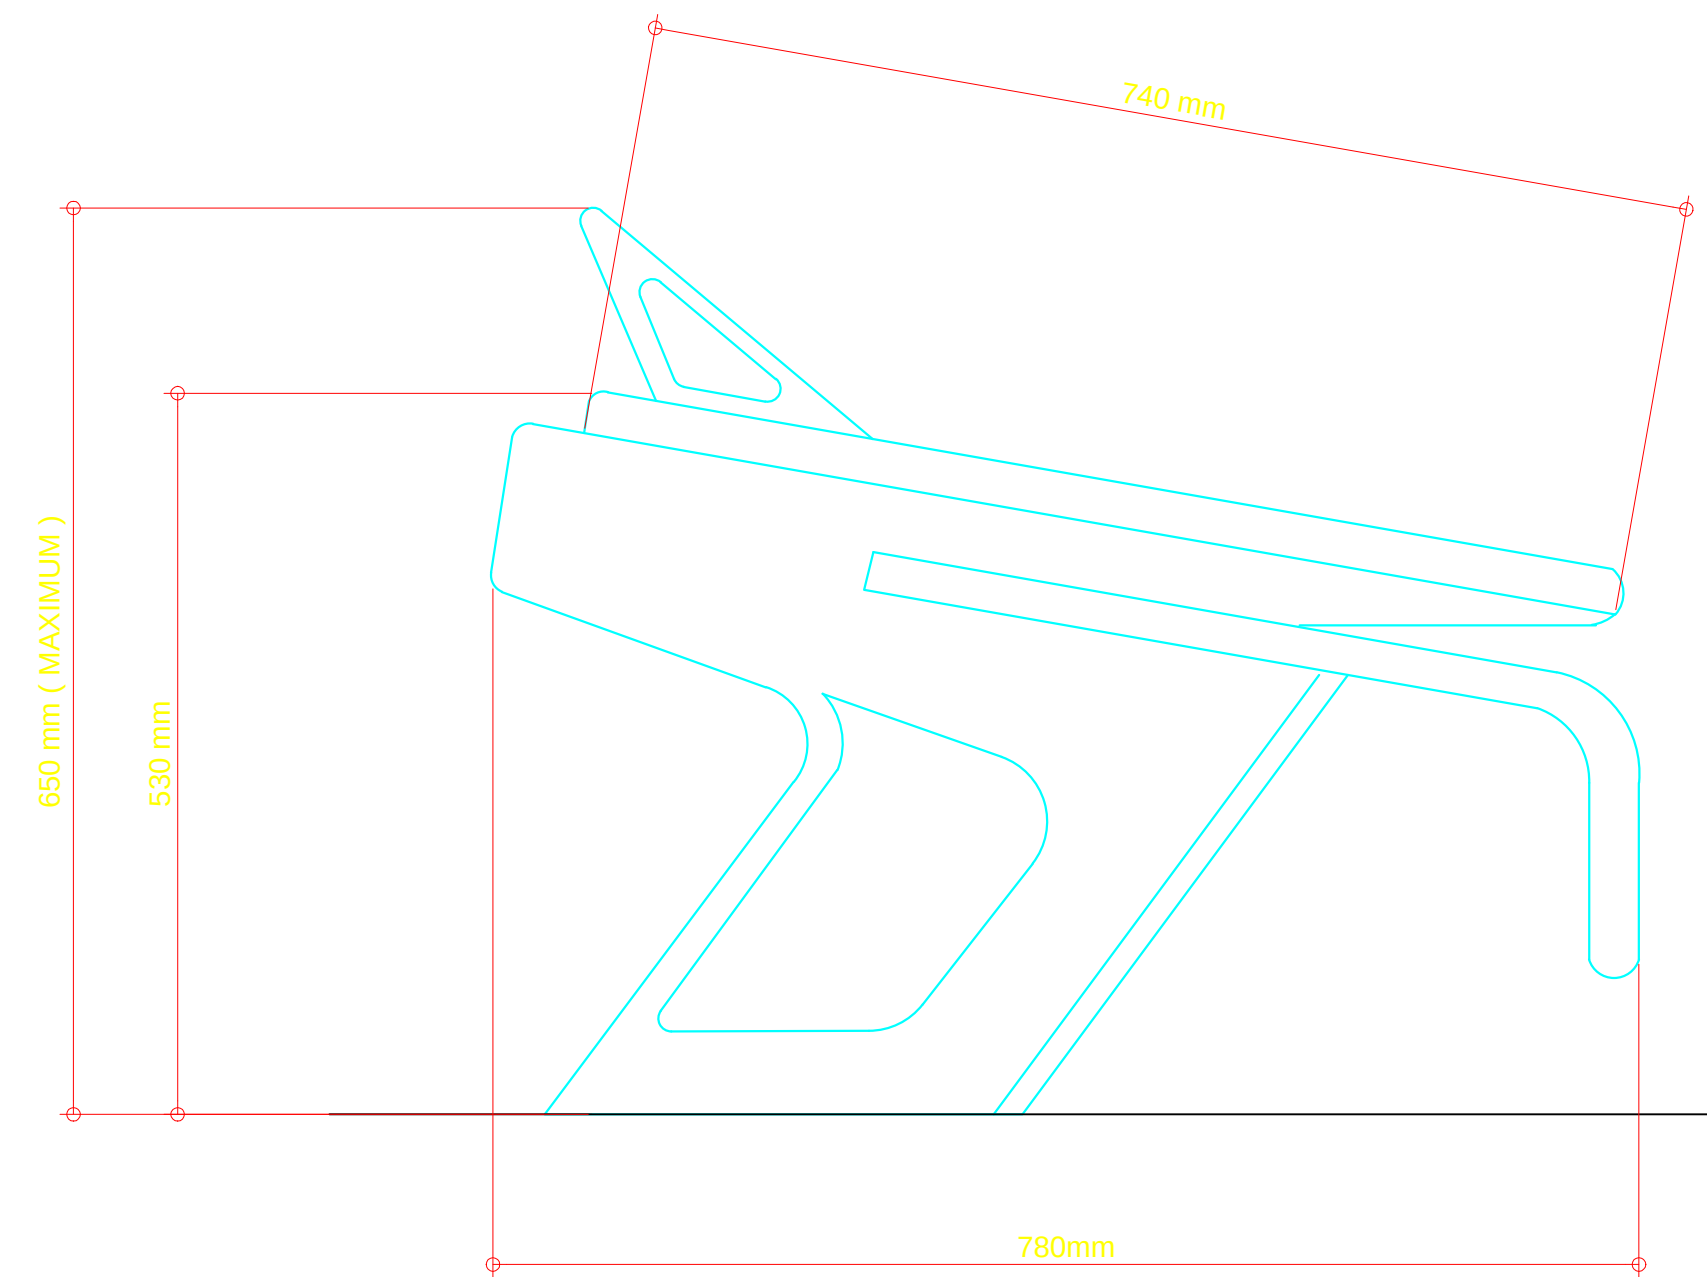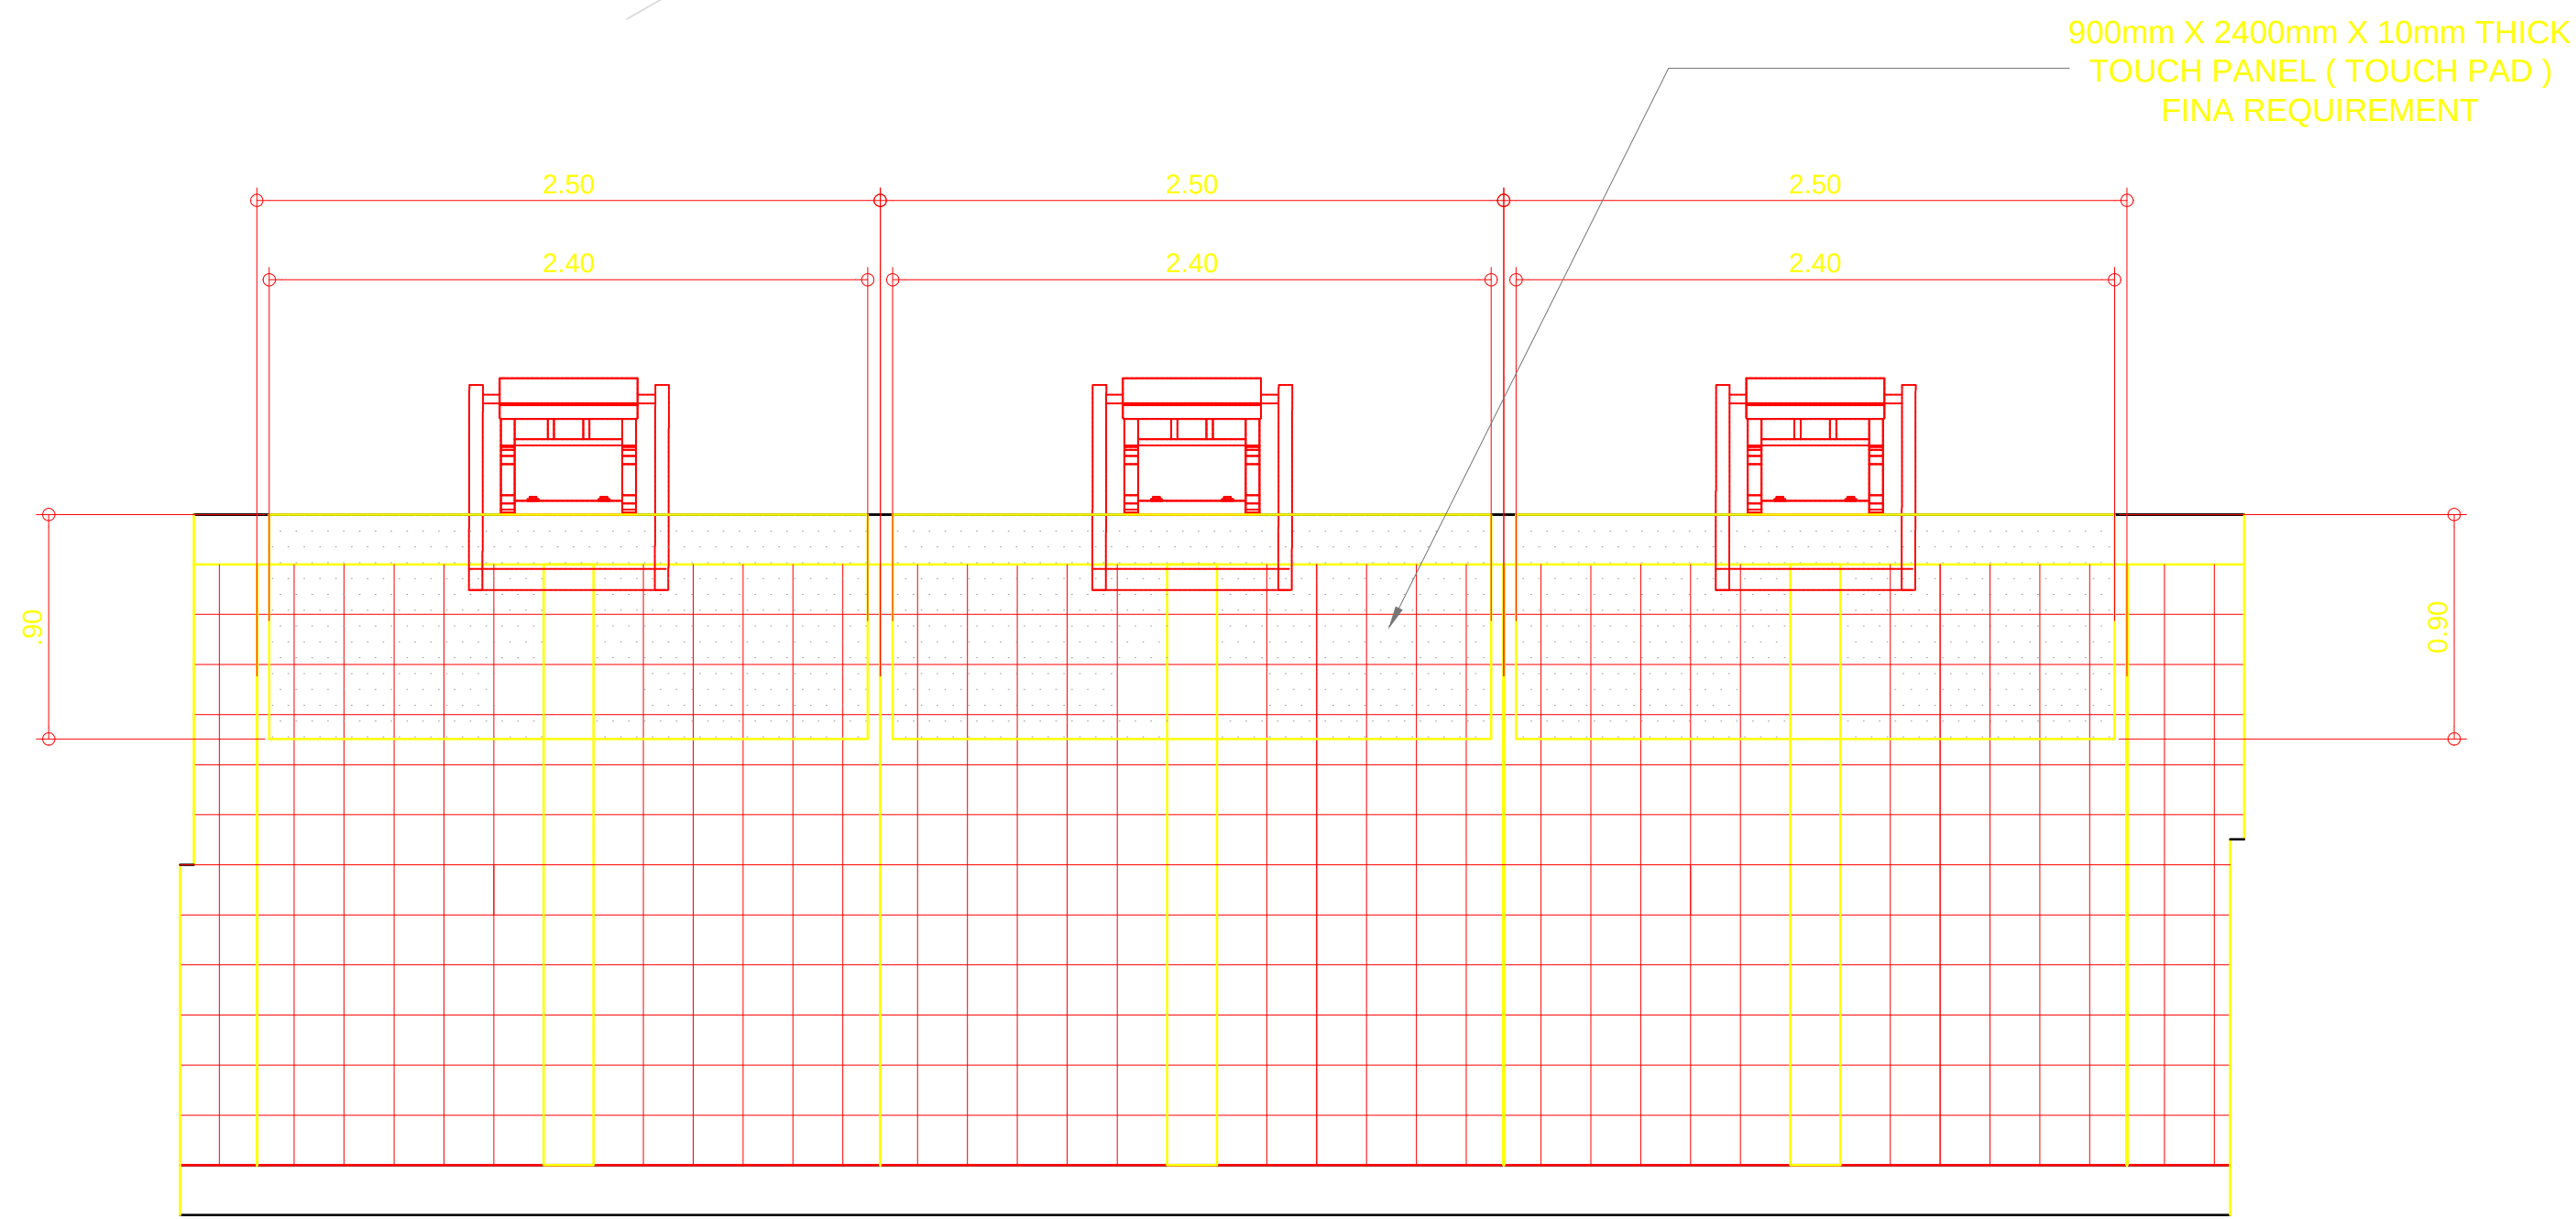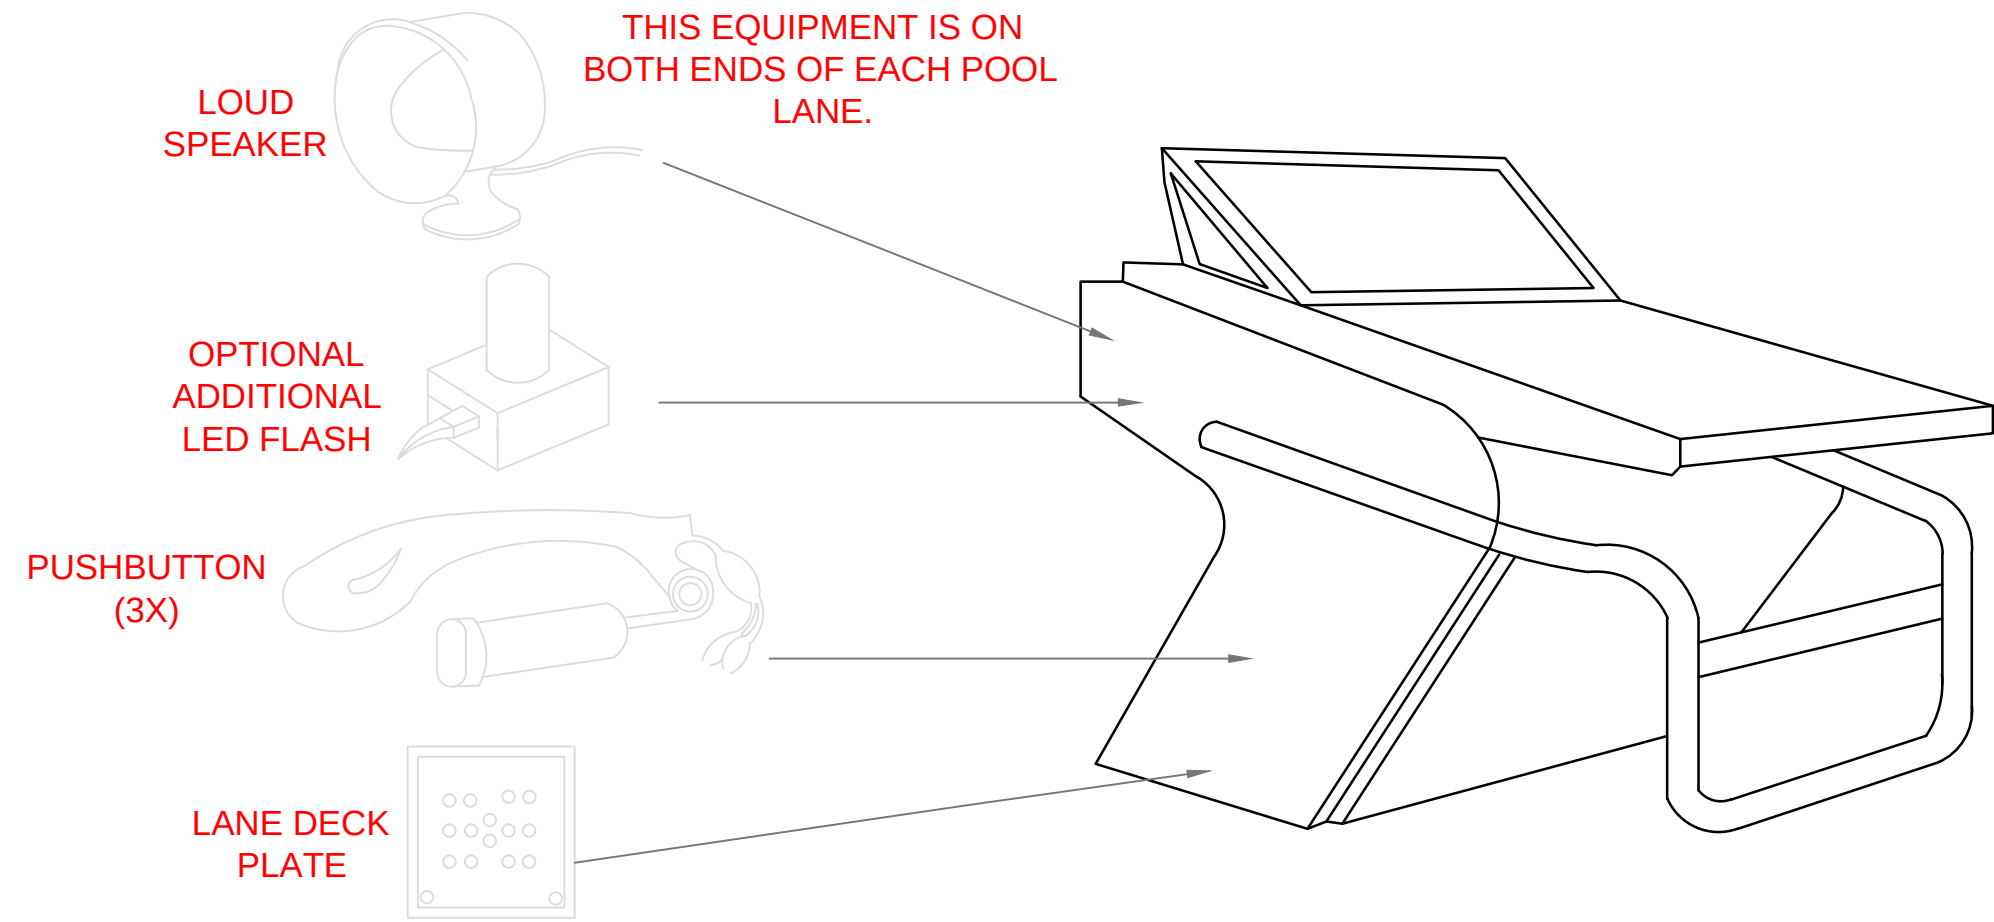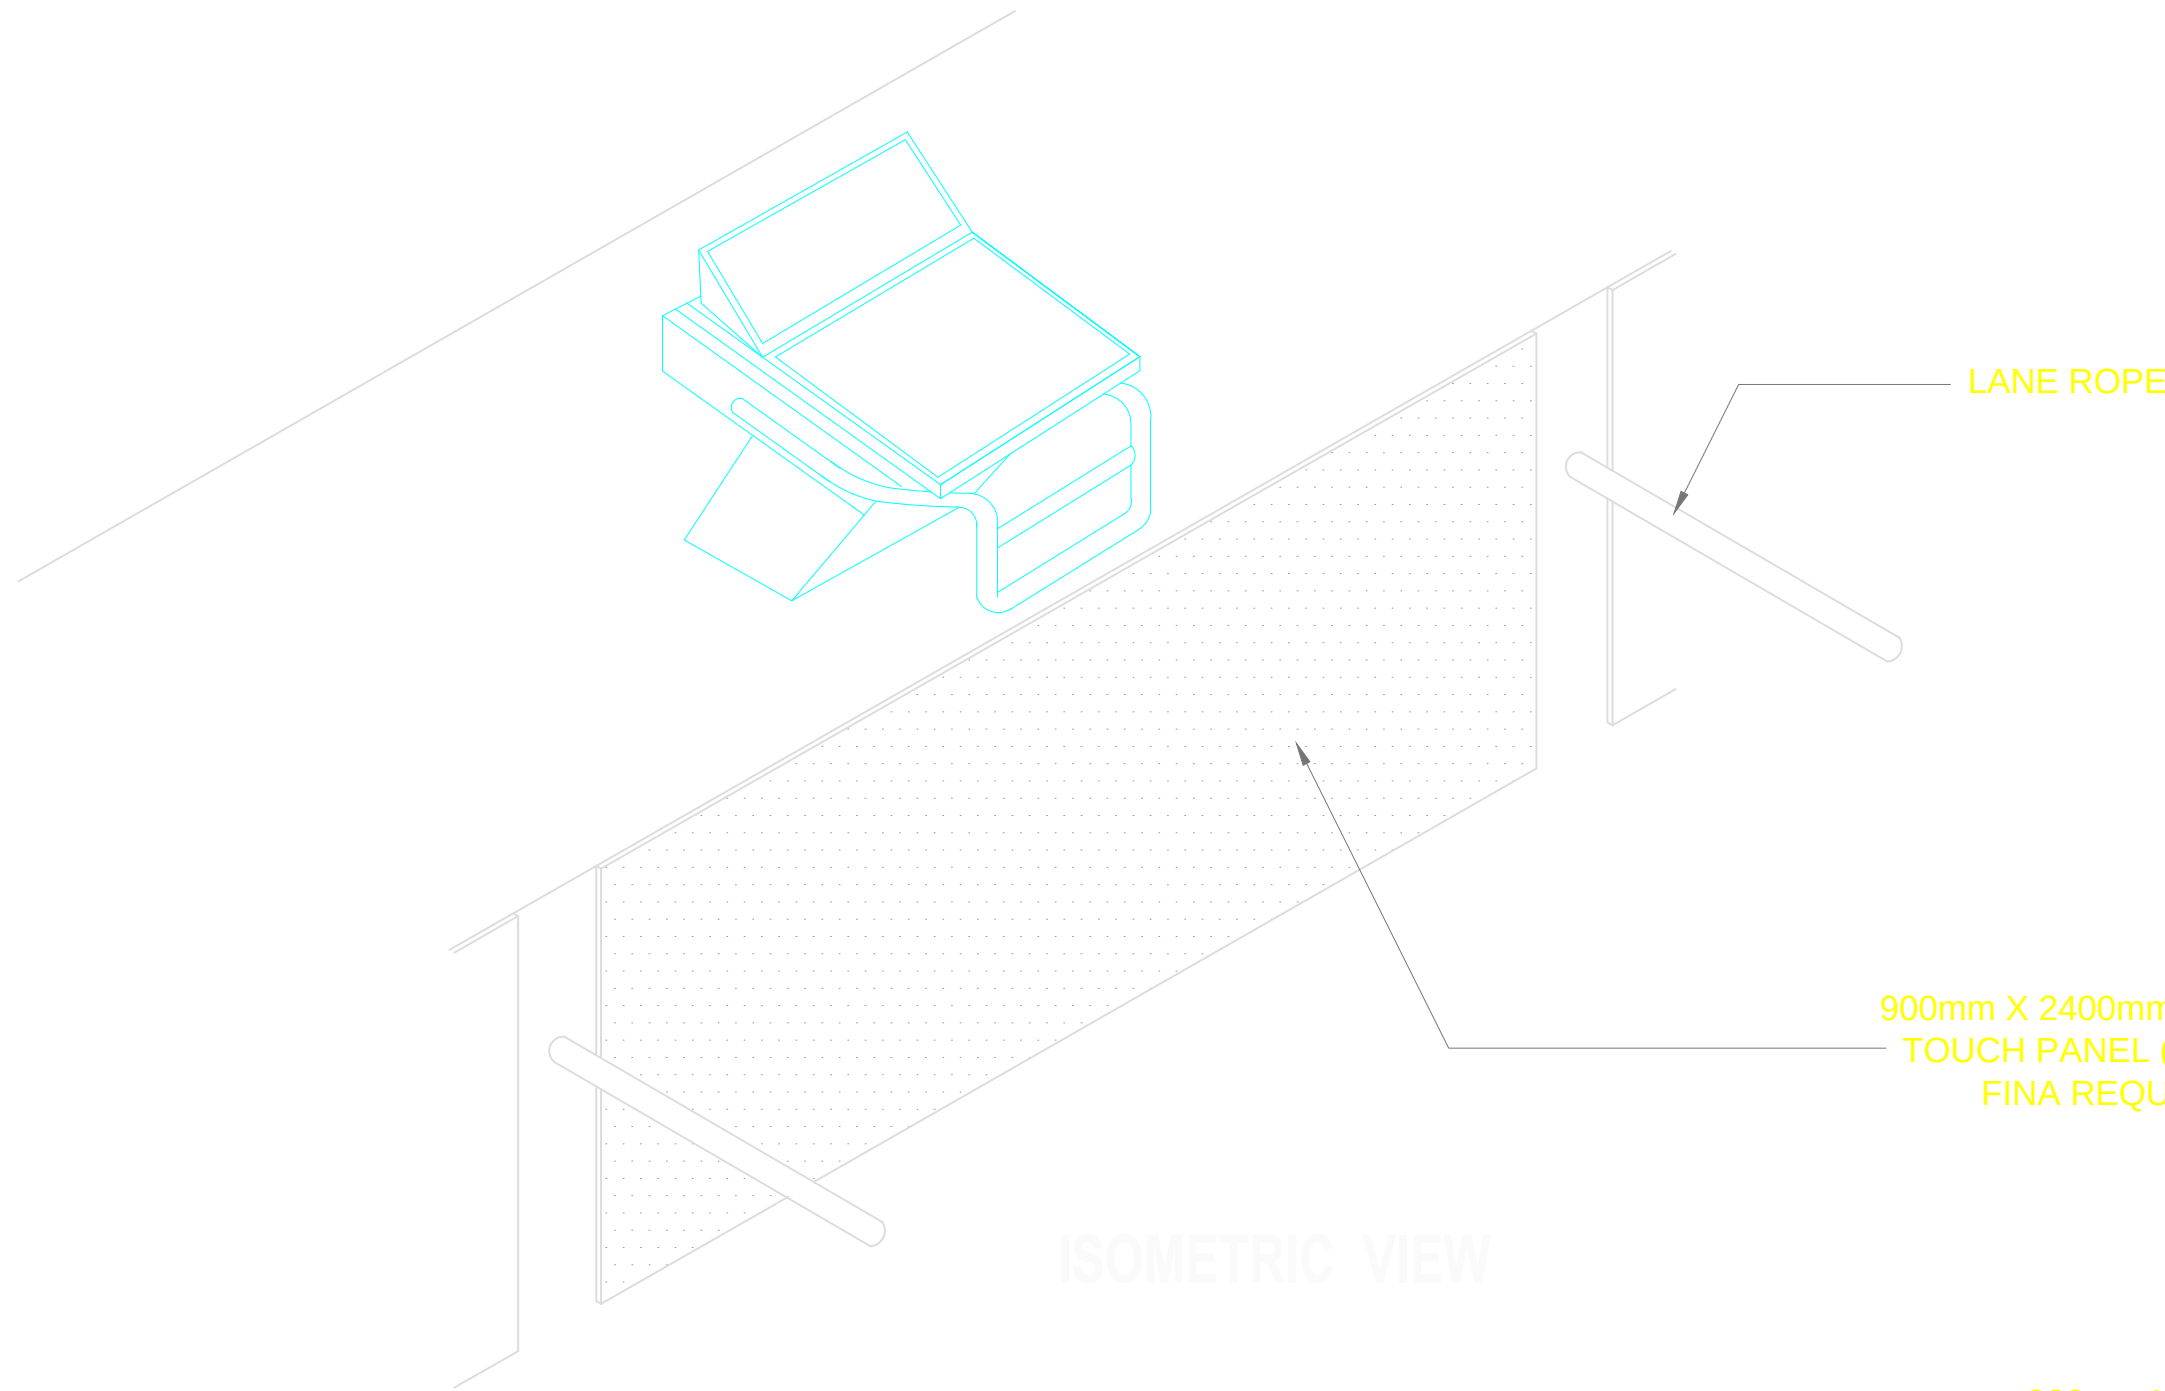


OWNER	PROJECT TITLE :	SUBMITTED BY :	RECOMMENDING APPROVAL :	APPROVED BY :	SHEET CONTENTS :	DESIGN BY :		SHEET NO :
 PHILIPPINE SPORTS COMMISSION RMSC, PABLO OCAMPO SR. ST., MALATE, MANILA	UPGRADING OF SWIMMING POOL, DIVING POOL, AND CONSTRUCTION OF NEW BLEACHERS, WARM UP POOL AND JACUZZI LOCATION: PHILSPORTS, ULTRA, MERALCO AVE., PASIG CITY	ENGR. PEDRO I. PINEDA JR. HEAD - ENGINEERING UNIT	DIR. MERLITA R. IBAY DEPUTY EXECUTIVE DIRECTOR	HON. WILLIAM I. RAMIREZ CHAIRMAN	AS SHOWN	DRAWN BY :		A 9
						CHECKED BY :		
						DATE :		
						APPROVED BY :		

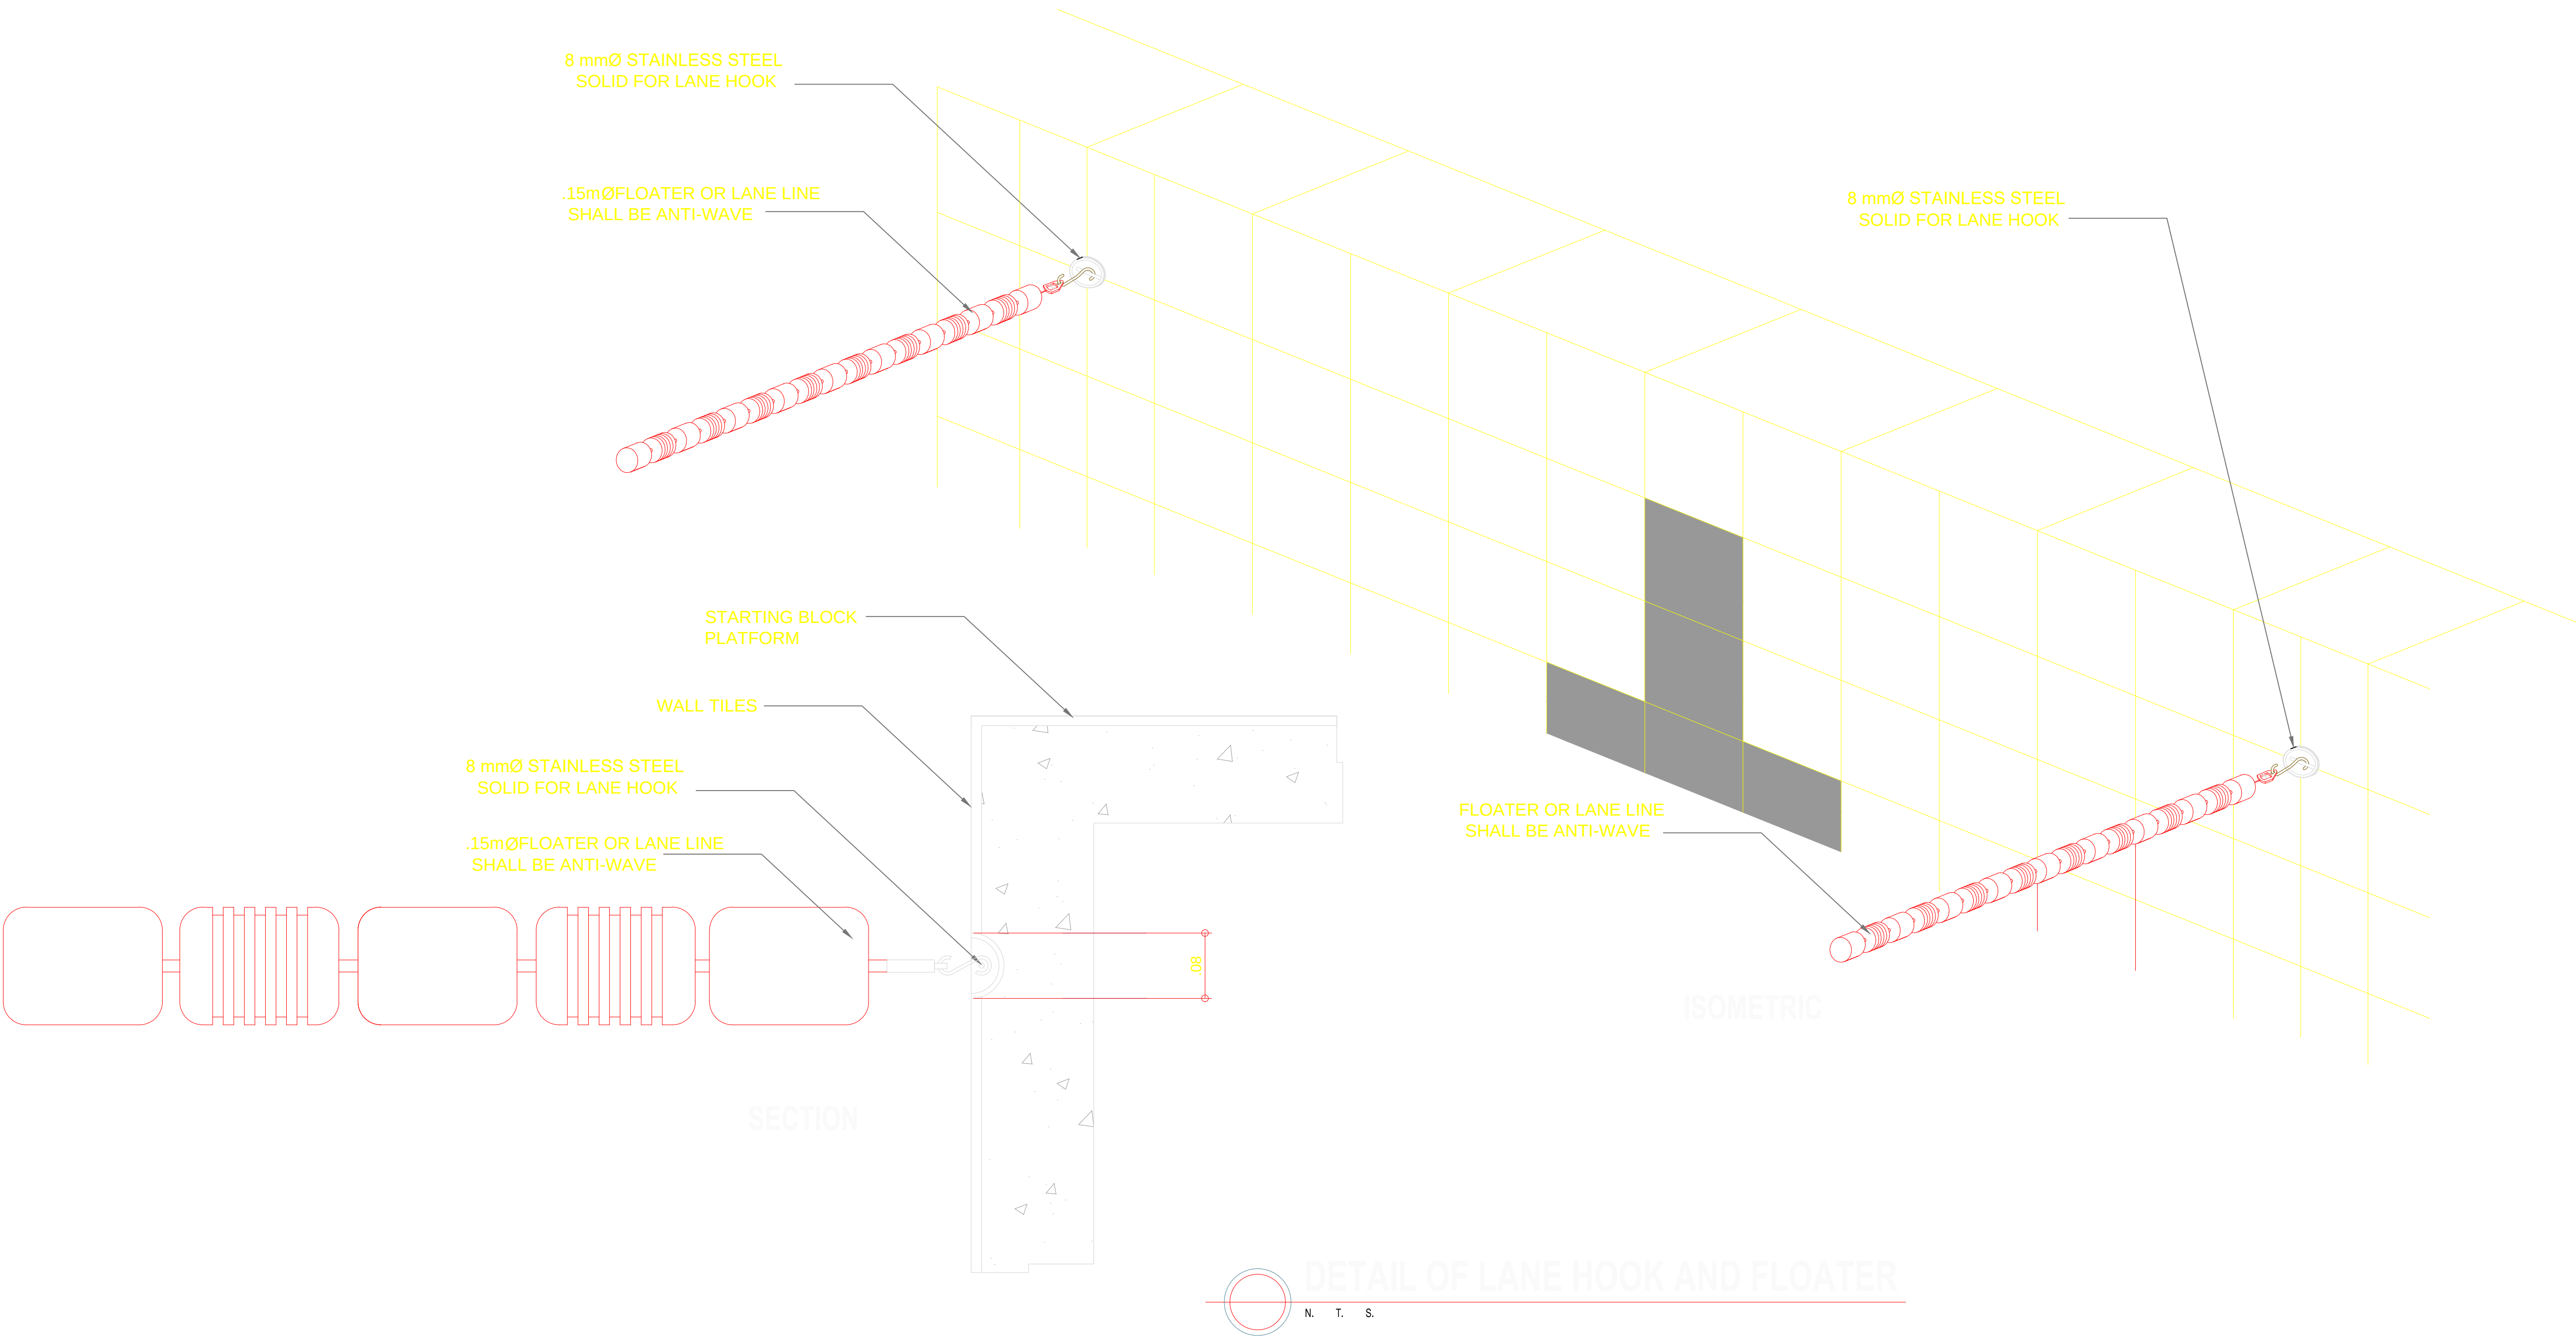

OWNER	PROJECT TITLE :	SUBMITTED BY :	RECOMMENDING APPROVAL :	APPROVED BY :	SHEET CONTENTS :	DESIGN BY :		SHEET NO :
 PHILIPPINE SPORTS COMMISSION RMSG, PABLO OCAMPO SR. ST., MALATE, MANILA	UPGRADING OF SWIMMING POOL, DIVING POOL, AND CONSTRUCTION OF NEW BLEACHERS, WARM UP POOL AND JACUZZI LOCATION: PHILSPORTS, ULTRA, MERALCO AVE., PASIG CITY	ENGR. PEDRO I. PINEDA JR. HEAD - ENGINEERING UNIT	DIR. MERLITA R. IBAY DEPUTY EXECUTIVE DIRECTOR	HON. WILLIAM I. RAMIREZ CHAIRMAN	AS SHOWN	DRAWN BY :		A 10
						CHECKED BY :		
						DATE :		
						APPROVED BY :		

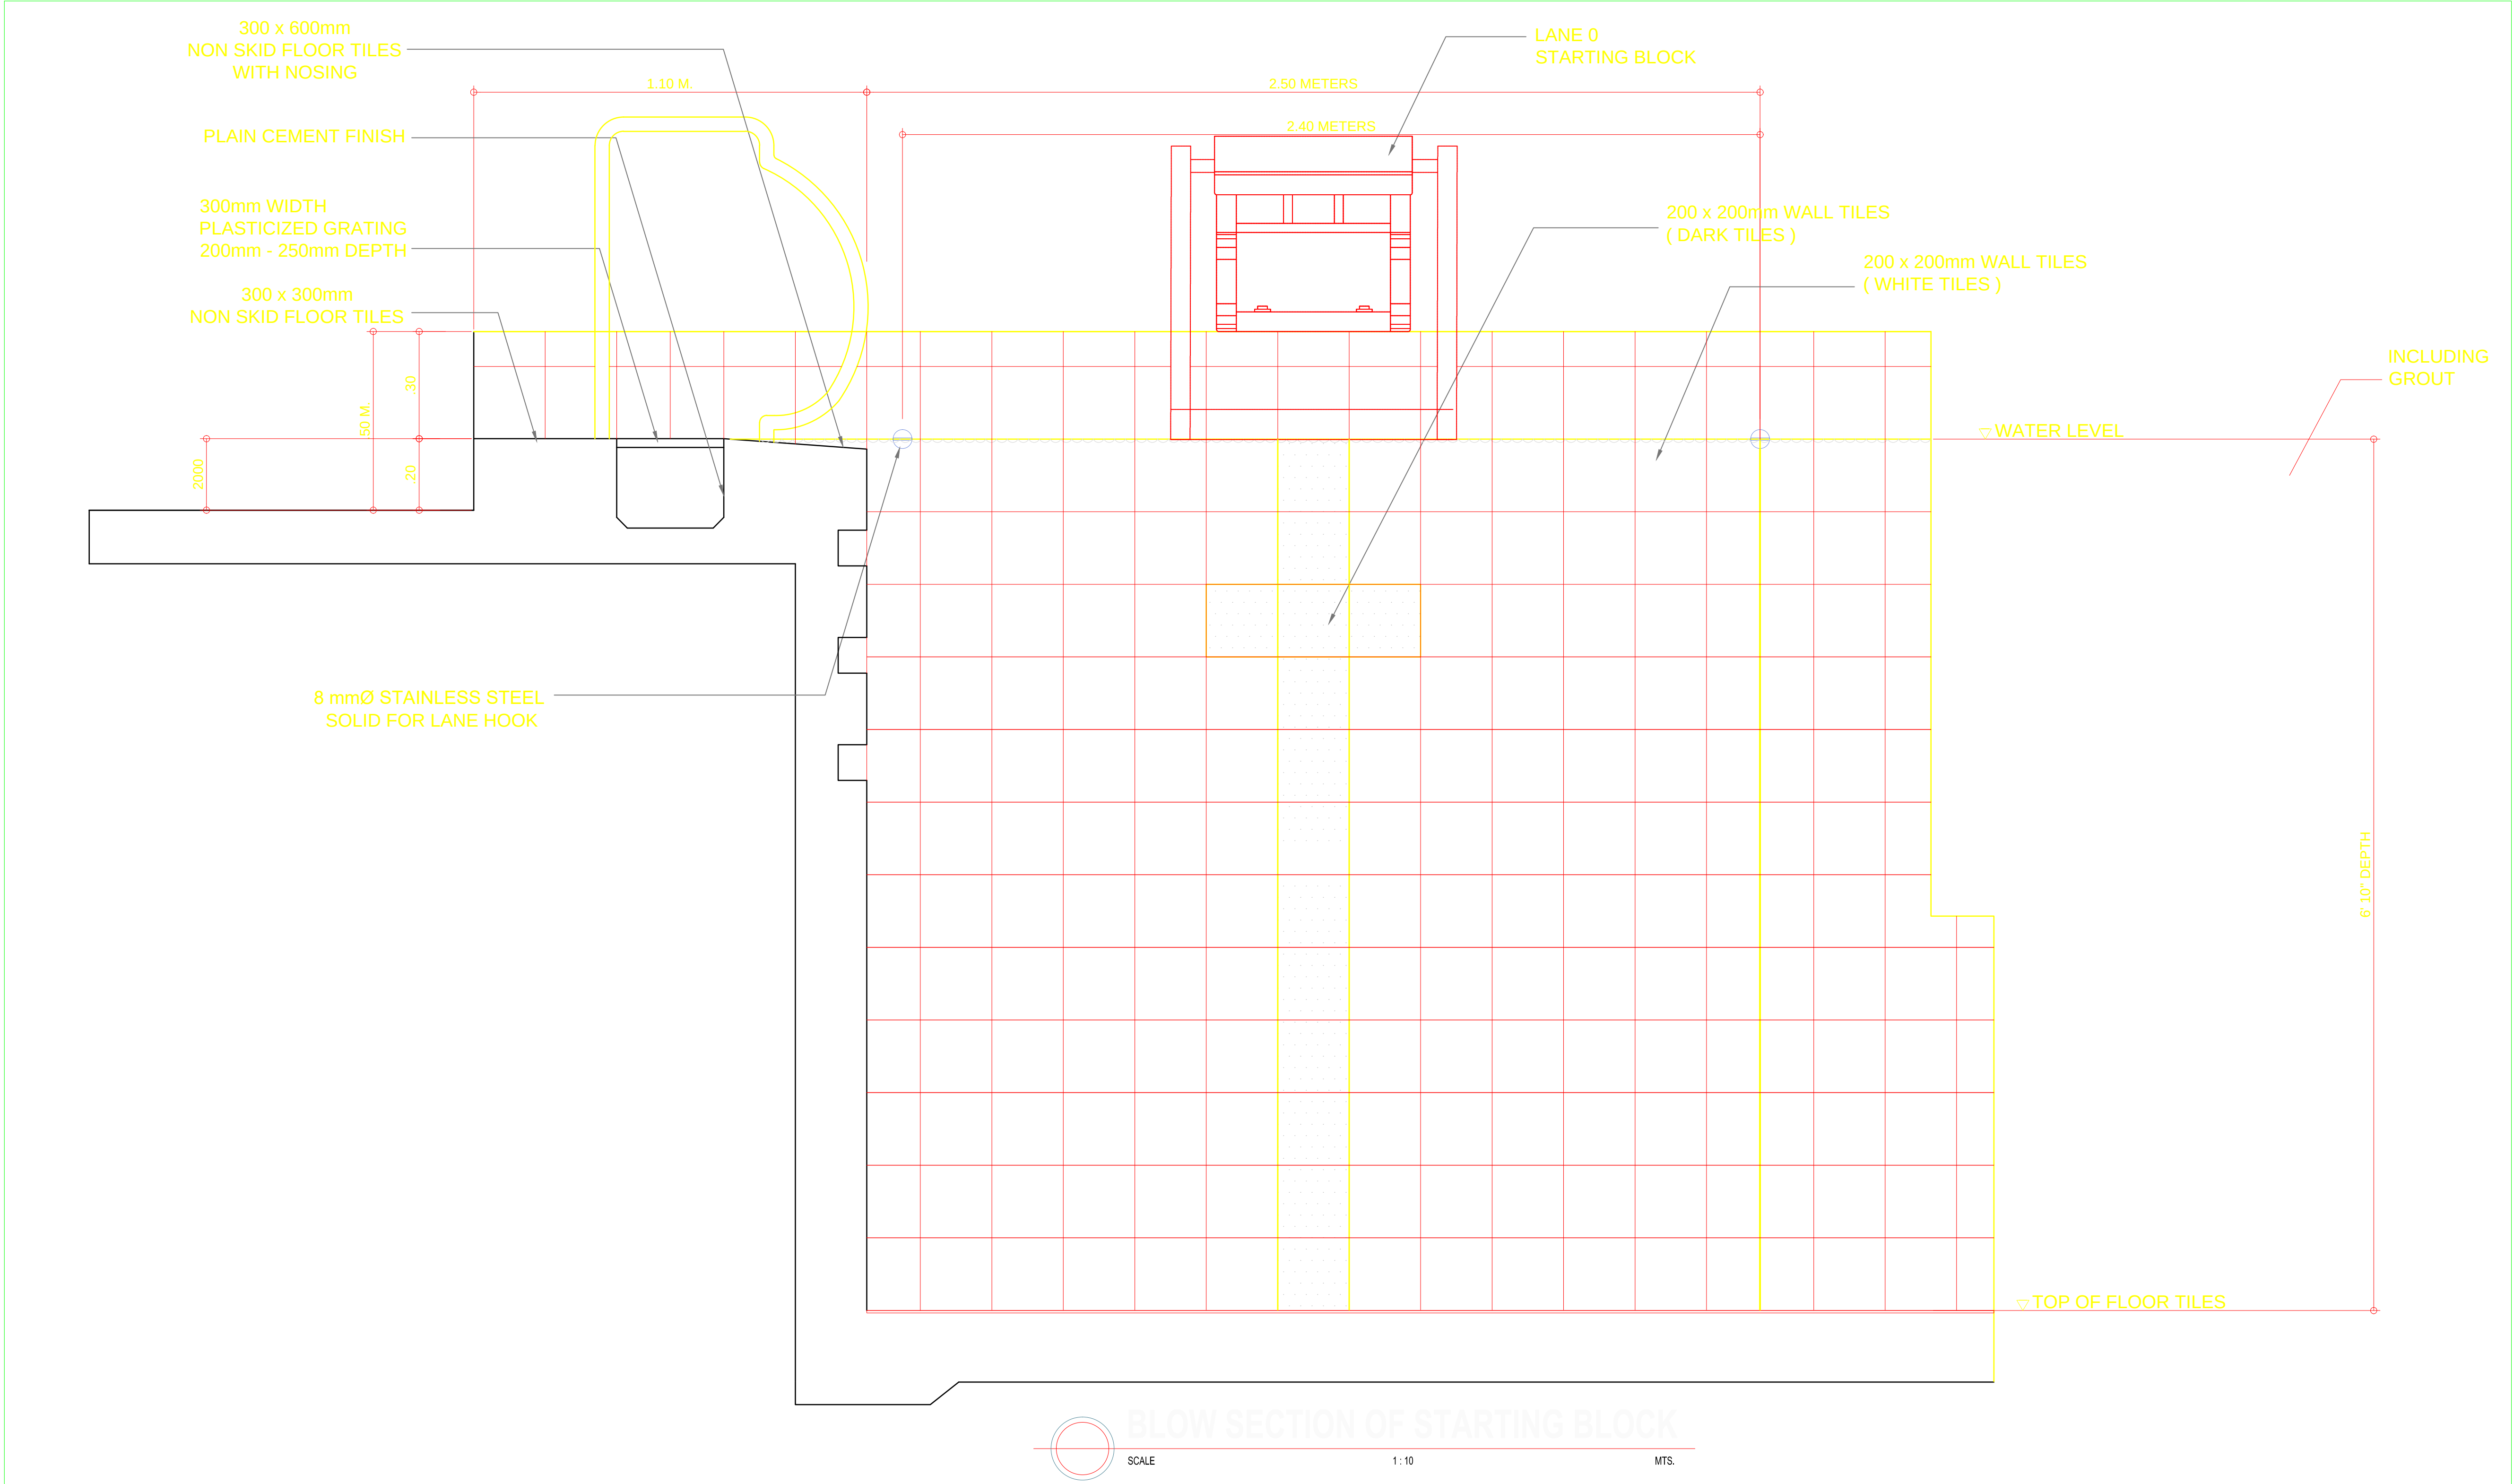


OWNER	PROJECT TITLE :	SUBMITTED BY :	RECOMMENDING APPROVAL :	APPROVED BY :	SHEET CONTENTS :	DESIGN BY :		SHEET NO :
PHILIPPINE SPORTS COMMISSION RMSC, PABLO OCAMPO SR. ST., MALATE, MANILA	UPGRADING OF SWIMMING POOL, DIVING POOL, AND CONSTRUCTION OF NEW BLEACHERS, WARM UP POOL AND JACUZZI LOCATION: PHILSPORTS, ULTRA, MERALCO AVE., PASIG CITY	ENGR. PEDRO I. PINEDA JR. HEAD - ENGINEERING UNIT	DIR. MERLITA R. IBAY DEPUTY EXECUTIVE DIRECTOR	HON. WILLIAM I. RAMIREZ CHAIRMAN	AS SHOWN	DRAWN BY :		A 11
						CHECKED BY :		
						DATE :		
						APPROVED BY :		

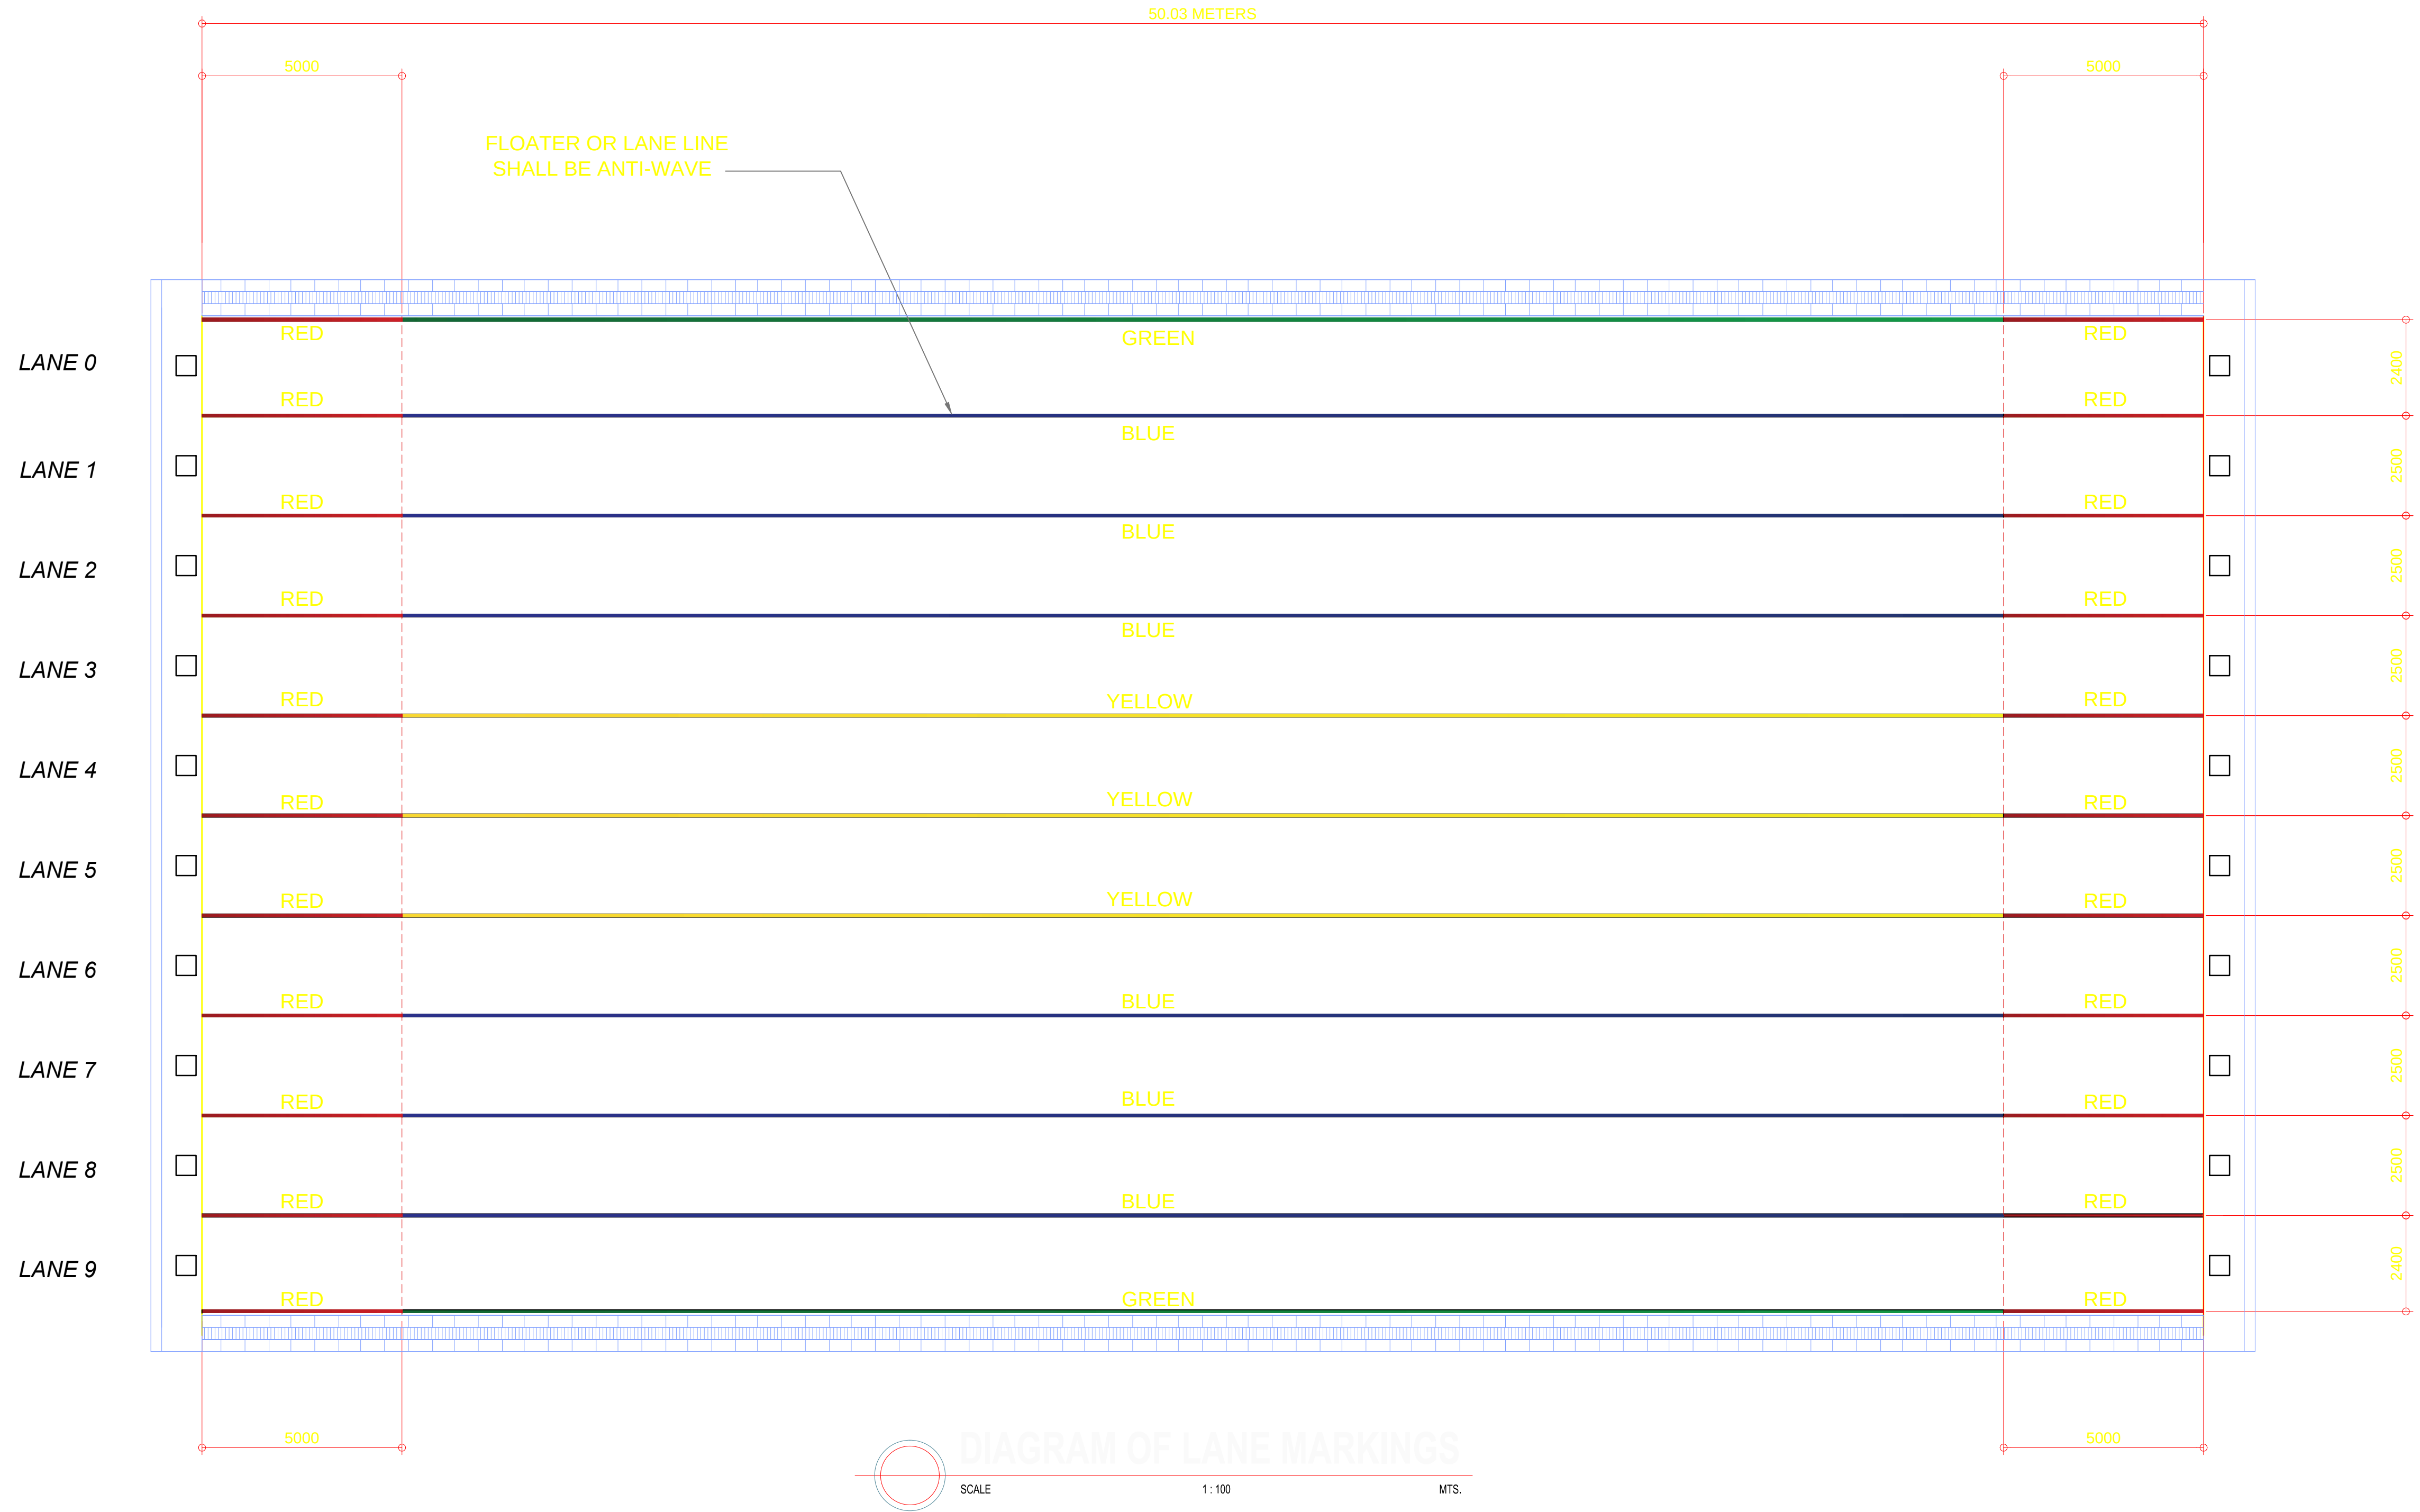

OWNER	PROJECT TITLE :	SUBMITTED BY :	RECOMMENDING APPROVAL :	APPROVED BY :	SHEET CONTENTS :	DESIGN BY :		SHEET NO :
PHILIPPINE SPORTS COMMISSION RMSG, PABLO OCAMPO SR. ST., MALATE, MANILA	UPGRADING OF SWIMMING POOL, DIVING POOL, AND CONSTRUCTION OF NEW BLEACHERS, WARM UP POOL AND JACUZZI LOCATION: PHILSPORTS, ULTRA, MERALCO AVE., PASIG CITY	ENGR. PEDRO I. PINEDA JR. HEAD - ENGINEERING UNIT	DIR. MERLITA R. IBAY DEPUTY EXECUTIVE DIRECTOR	HON. WILLIAM I. RAMIREZ CHAIRMAN	AS SHOWN	DESIGN BY :		A 12
						DRAWN BY :		
						CHECKED BY :		
						DATE :		
						APPROVED BY :		


OWNER	PROJECT TITLE :	SUBMITTED BY :	RECOMMENDING APPROVAL :	APPROVED BY :	SHEET CONTENTS :	DESIGN BY :	SHEET NO :
 PHILIPPINE SPORTS COMMISSION RMSC, PABLO OCAMPO SR. ST., MALATE, MANILA	UPGRADING OF SWIMMING POOL, DIVING POOL, AND CONSTRUCTION OF NEW BLEACHERS, WARM UP POOL AND JACUZZI LOCATION: PHILSPORTS, ULTRA, MERALCO AVE., PASIG CITY	ENGR. PEDRO I. PINEDA JR. HEAD - ENGINEERING UNIT	DIR. MERLITA R. IBAY DEPUTY EXECUTIVE DIRECTOR	HON. WILLIAM I. RAMIREZ CHAIRMAN	AS SHOWN	DRAWN BY :	A 13
						CHECKED BY :	
						DATE :	
						APPROVED BY :	

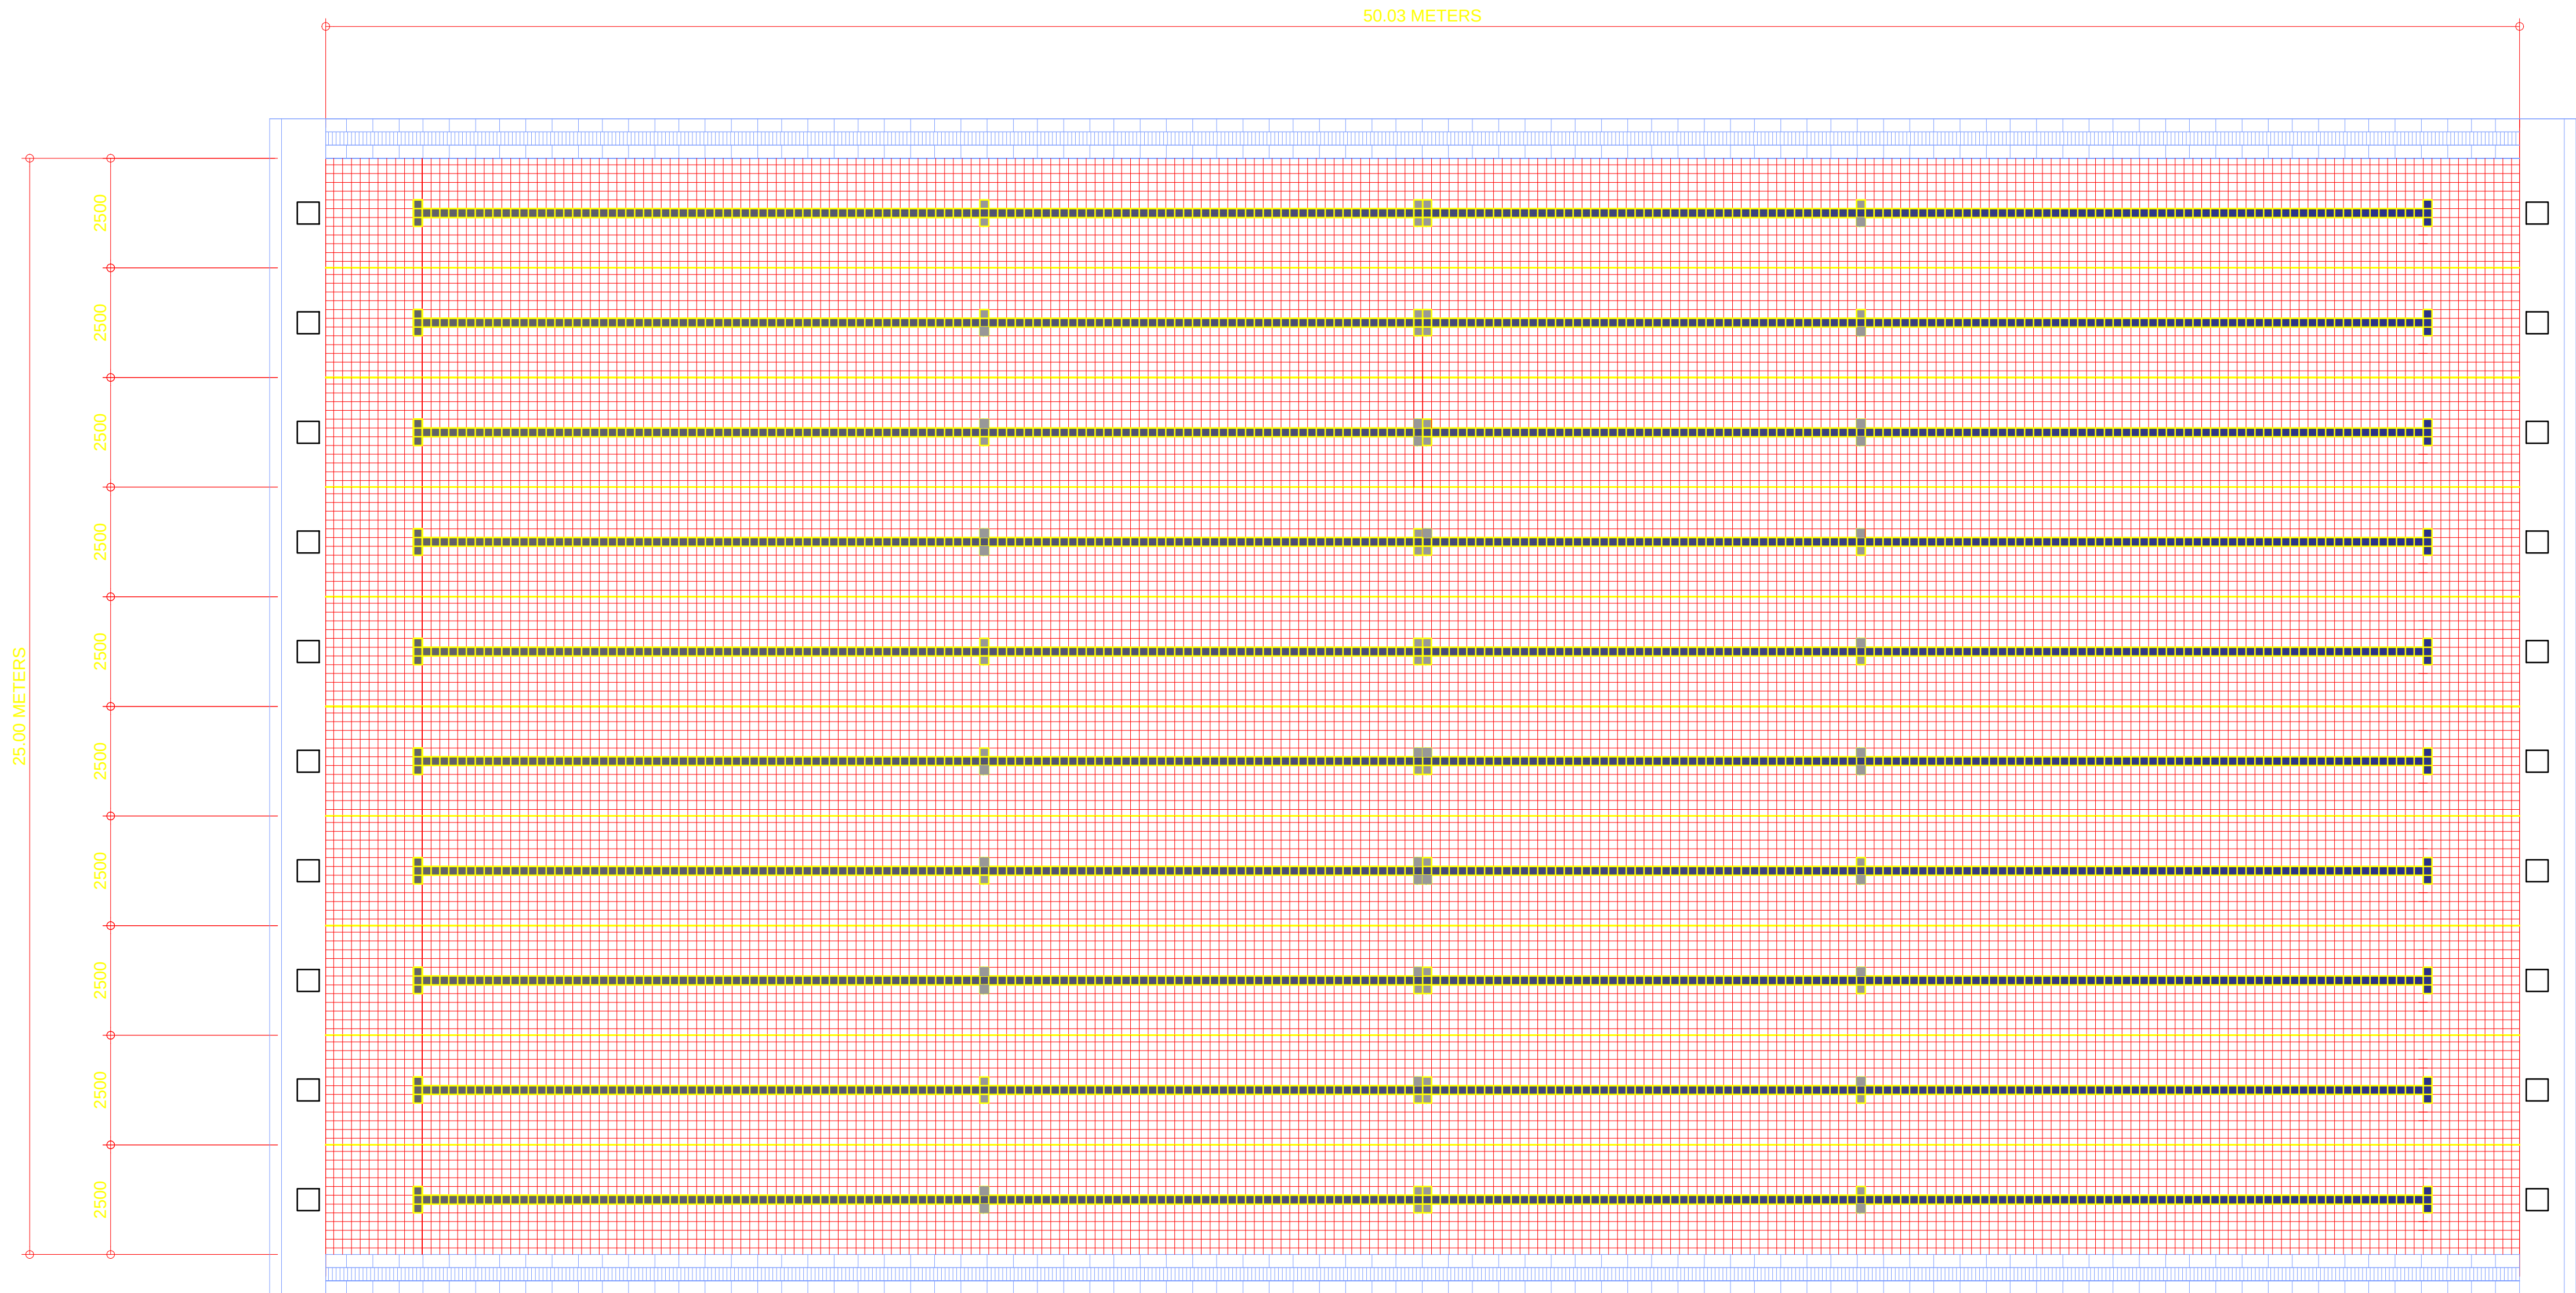


EXISTING LONGITUDINAL SECTION

SCALE 1:100 MTS.

OWNER	PROJECT TITLE :	SUBMITTED BY :	RECOMMENDING APPROVAL :	APPROVED BY :	SHEET CONTENTS :	DESIGN BY :		SHEET NO :
 PHILIPPINE SPORTS COMMISSION RMSG, PABLO OCAMPO SR. ST., MALATE, MANILA PHILIPPINE SPORTS COMMISSION	UPGRADING OF SWIMMING POOL, DIVING POOL, AND CONSTRUCTION OF NEW BLEACHERS, WARM UP POOL AND JACUZZI LOCATION: PHILSPORTS, ULTRA, MERALCO AVE., PASIG CITY	ENGR. PEDRO I. PINEDA JR. HEAD - ENGINEERING UNIT	DIR. MERLITA R. IBAY DEPUTY EXECUTIVE DIRECTOR	HON. WILLIAM I. RAMIREZ CHAIRMAN	AS SHOWN	DRAWN BY :		A 14
						CHECKED BY :		
						DATE :		
						APPROVED BY :		

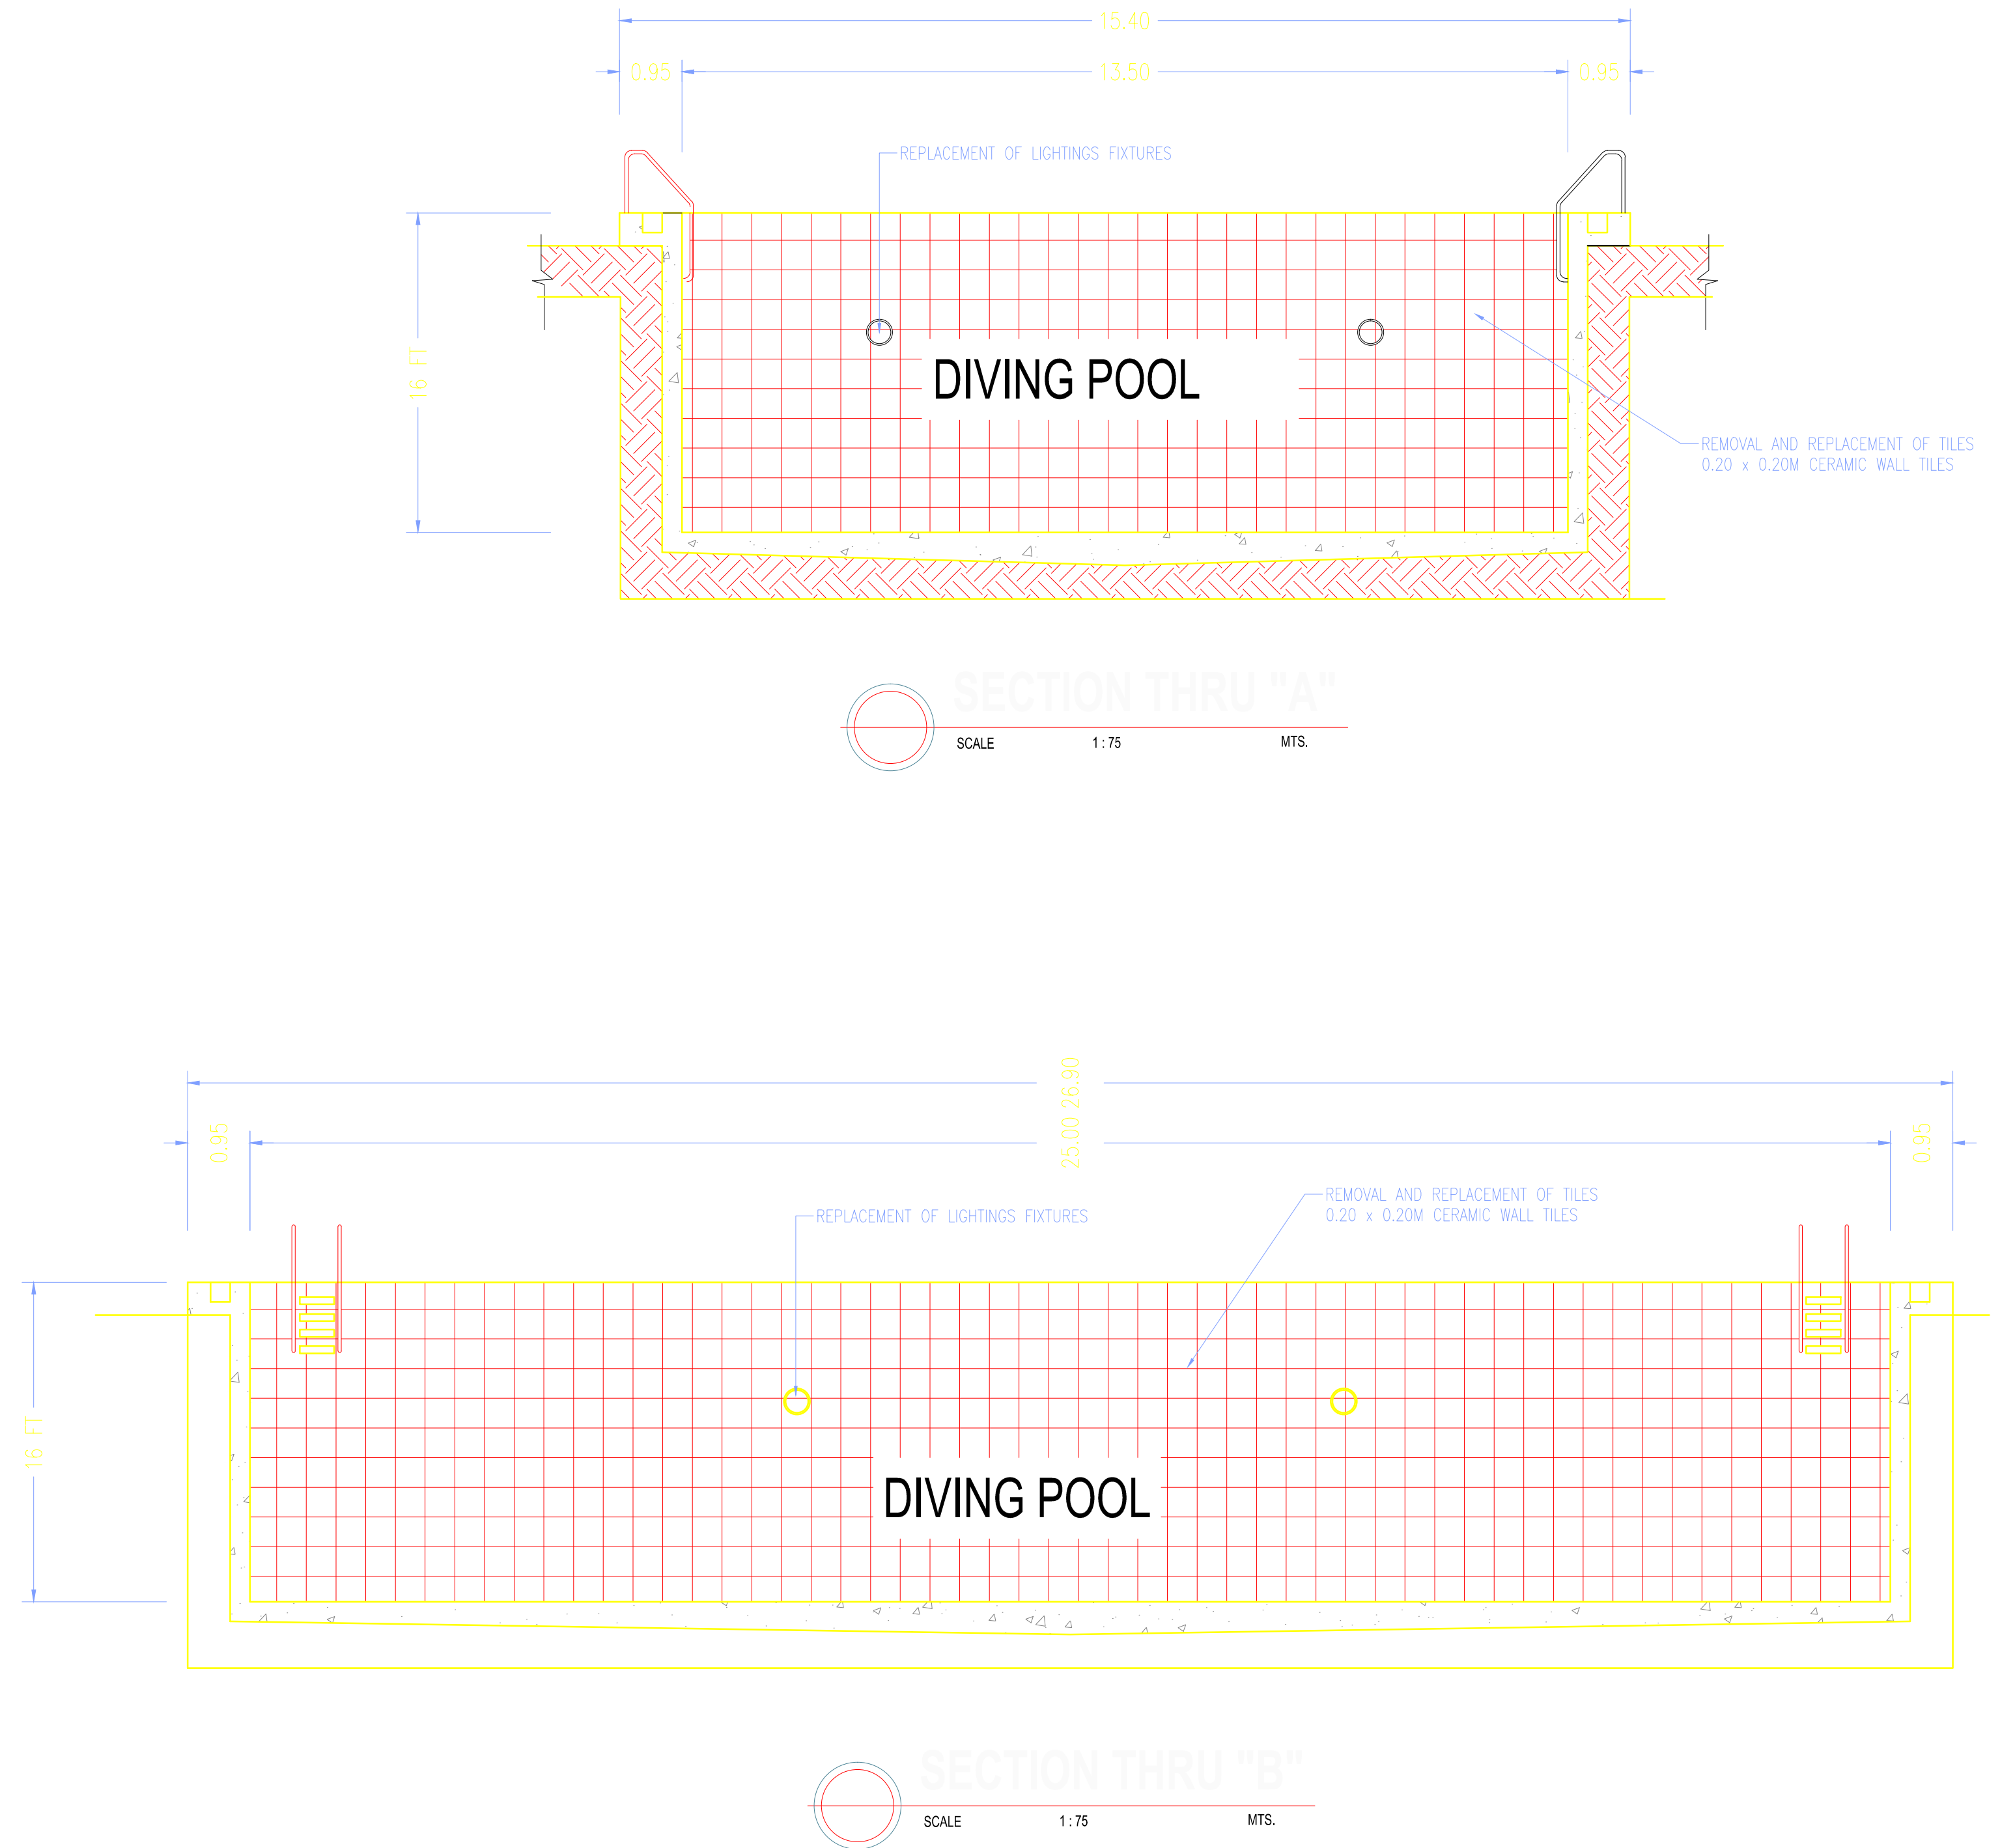


OWNER :	PROJECT TITLE :	SUBMITTED BY :	RECOMMENDING APPROVAL :	APPROVED BY :	SHEET CONTENTS :	DESIGN BY :	SHEET NO. :
 PHILIPPINE SPORTS COMMISSION RMSC, PABLO OCAMPO SR. ST., MALATE, MANILA	UPGRADING OF SWIMMING POOL, DIVING POOL, AND CONSTRUCTION OF NEW BLEACHERS, WARM UP POOL AND JACUZZI LOCATION: PHILSPORTS, ULTRA, MERALCO AVE., PASIG CITY	ENGR. PEDRO I. PINEDA JR. HEAD - ENGINEERING UNIT	DIR. MERLITA R. IBAY DEPUTY EXECUTIVE DIRECTOR	HON. WILLIAM I. RAMIREZ CHAIRMAN	AS SHOWN	DESIGN BY :	A 15
						DRAWN BY :	
						CHECKED BY :	
						DATE :	
						APPROVED BY :	

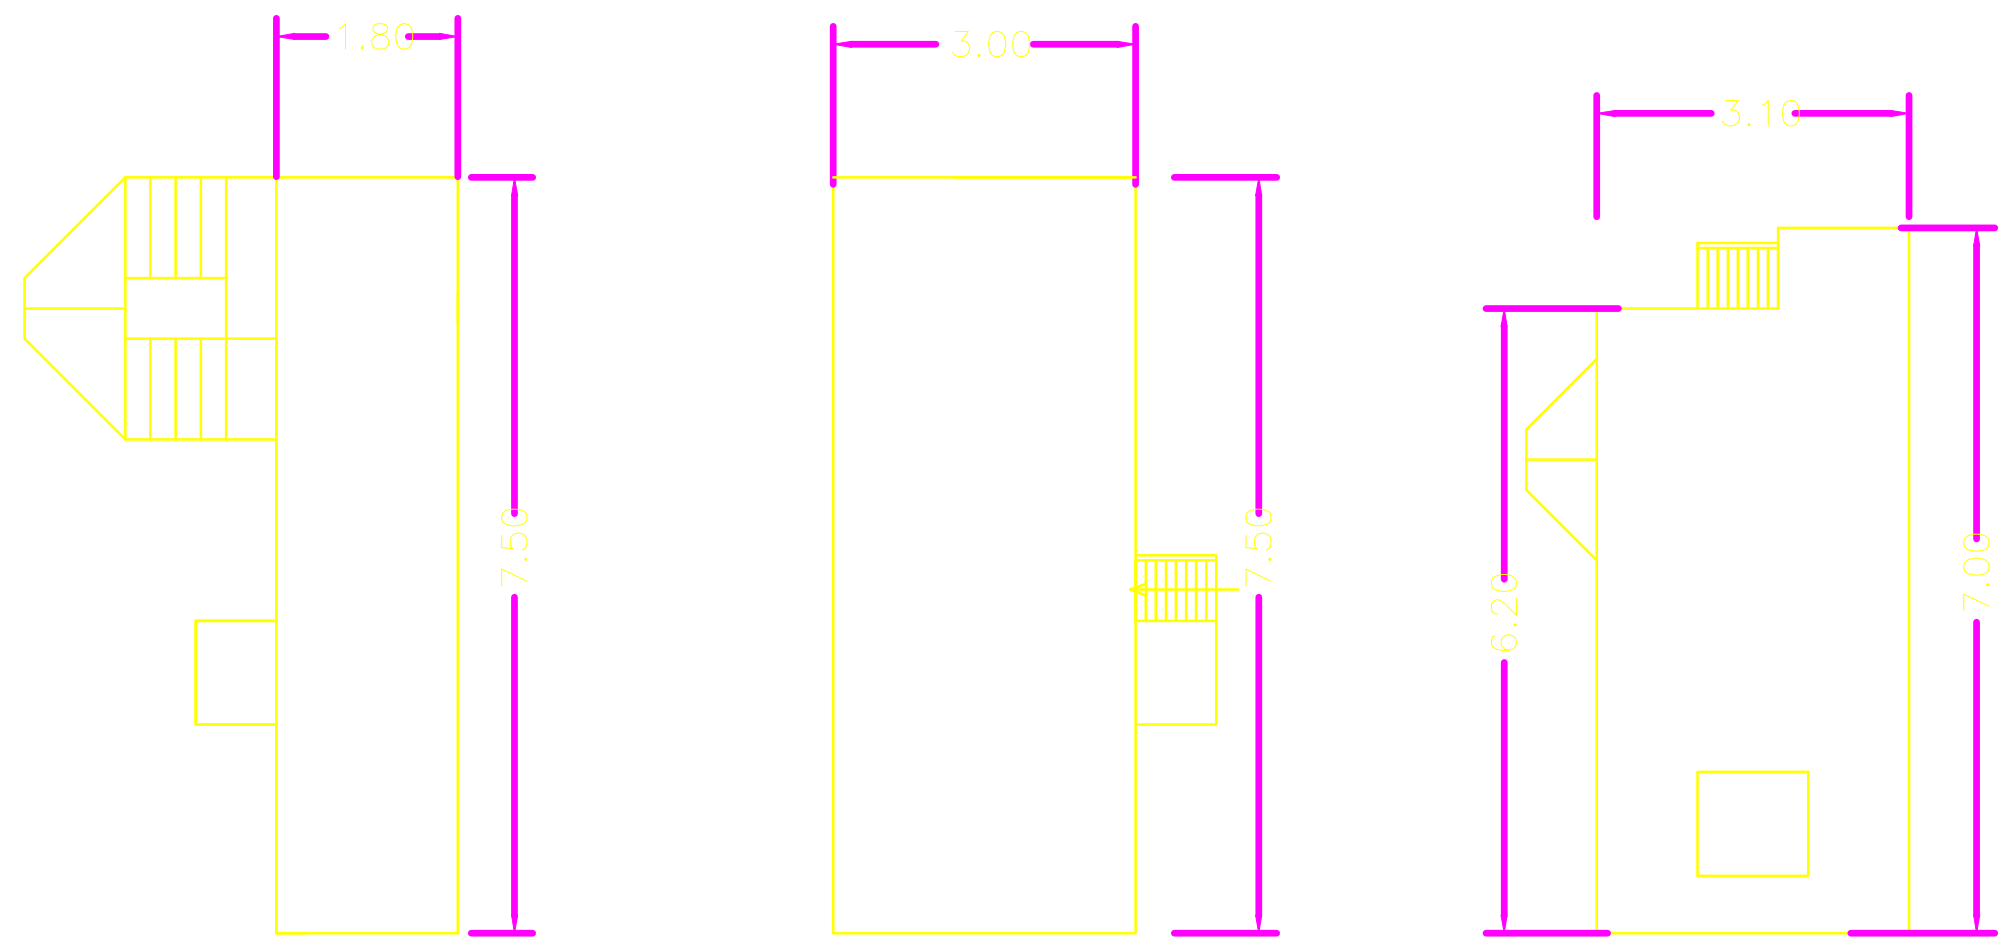


FIRST LEVEL @ 5.00 M SECOND LEVEL @ 7.50 M THIRD LEVEL @ 10.00 M

PLAN OF DIVING PLATFORM
SCALE 1:75 MTS.

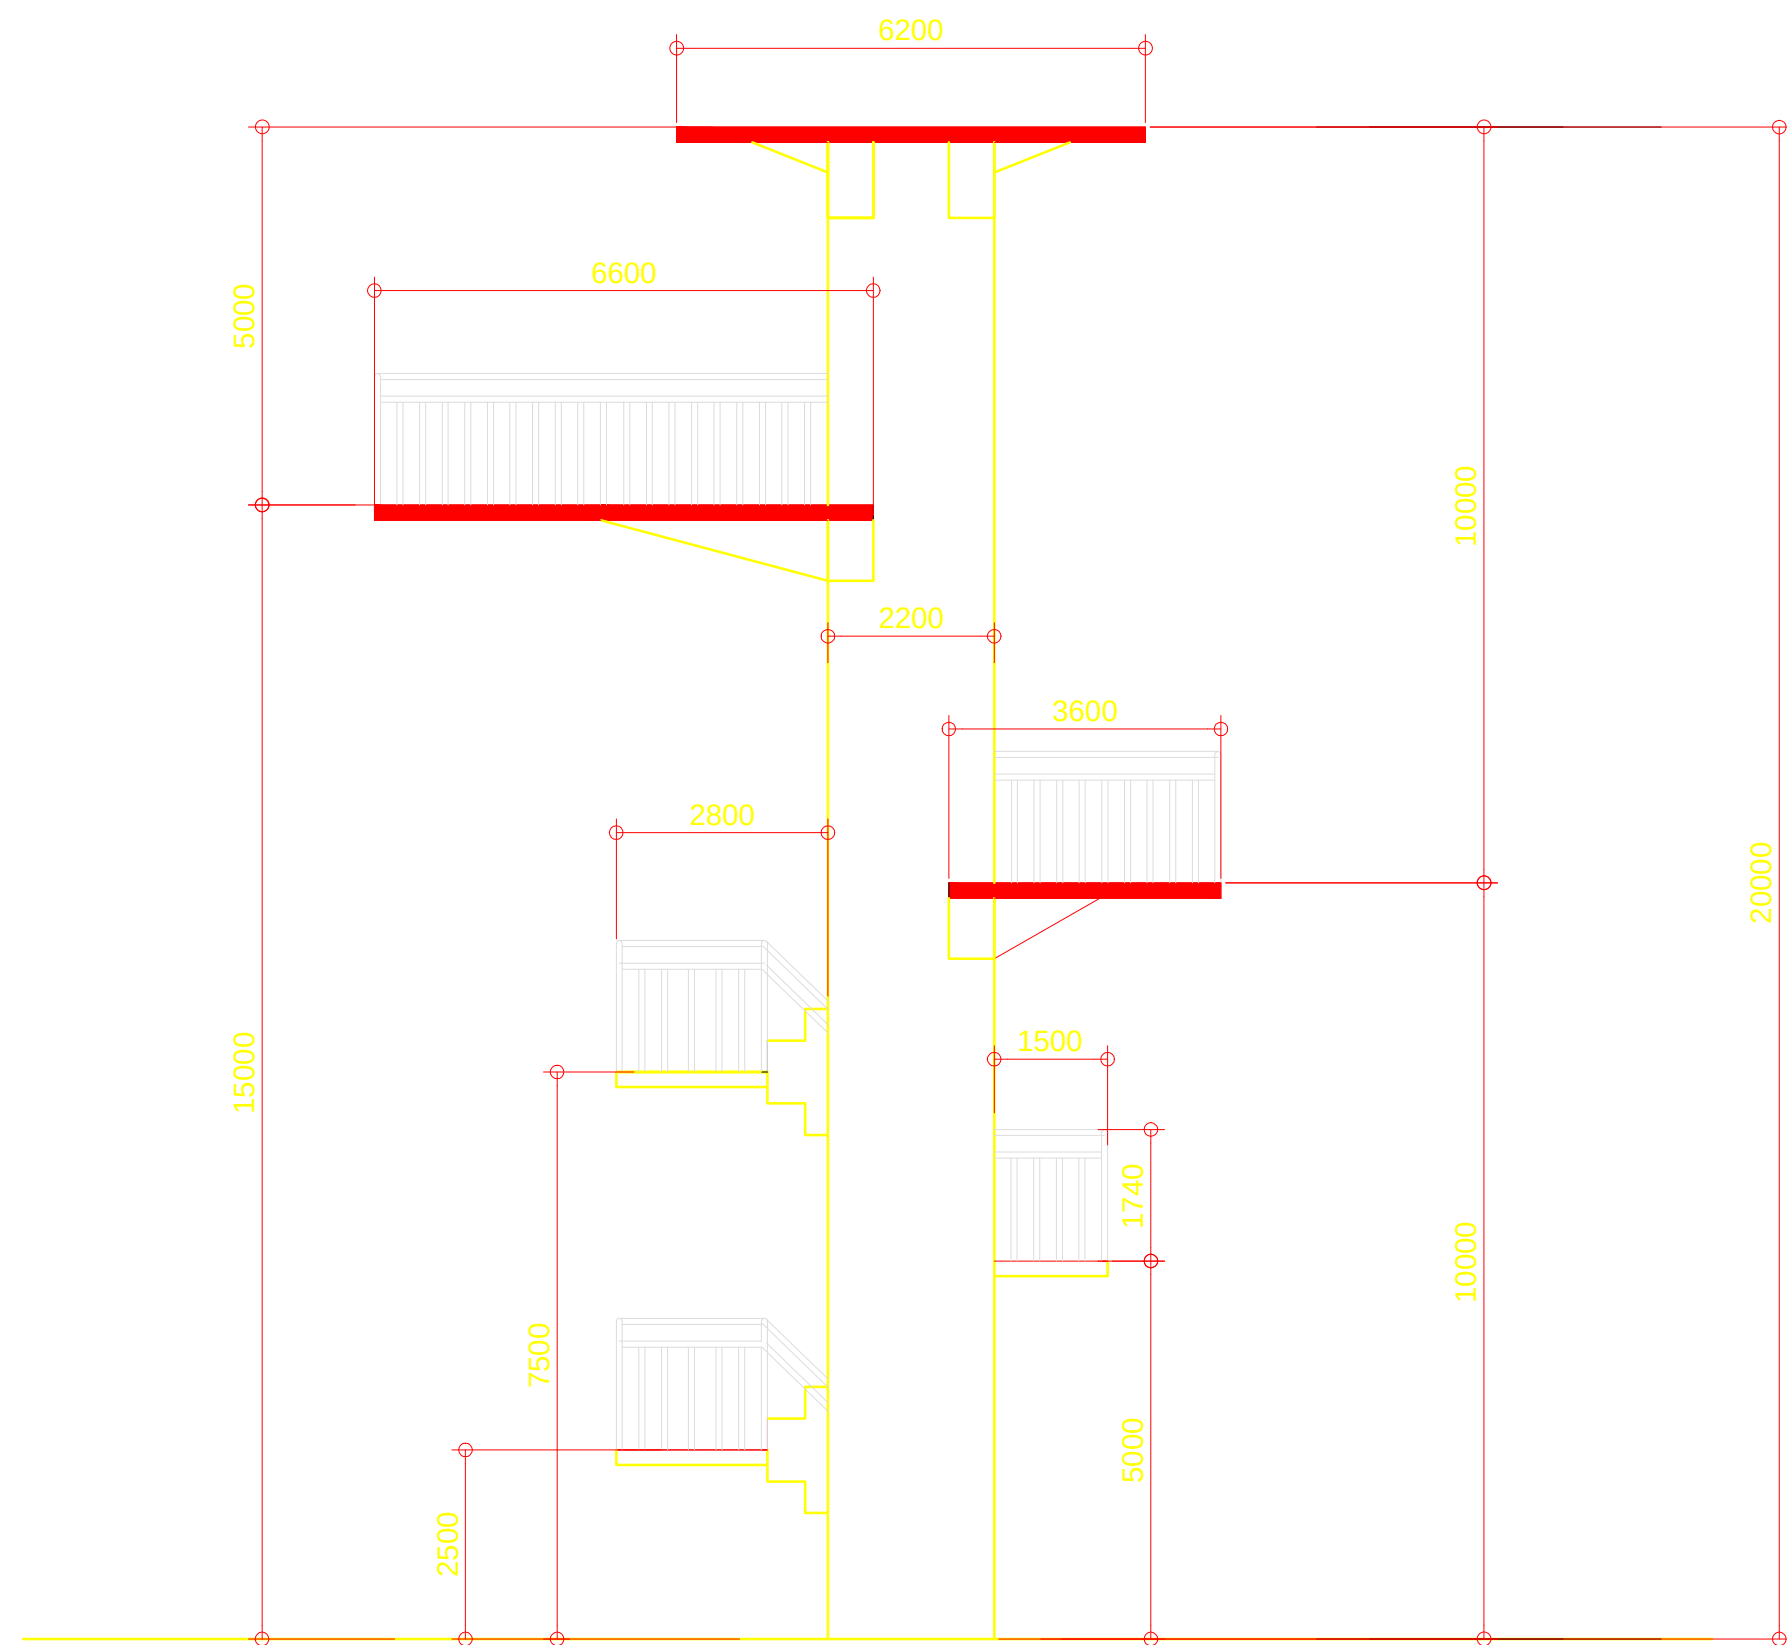


DIVING PLATFORM
FRONT ELEVATION
SCALE 1:200 MTS.

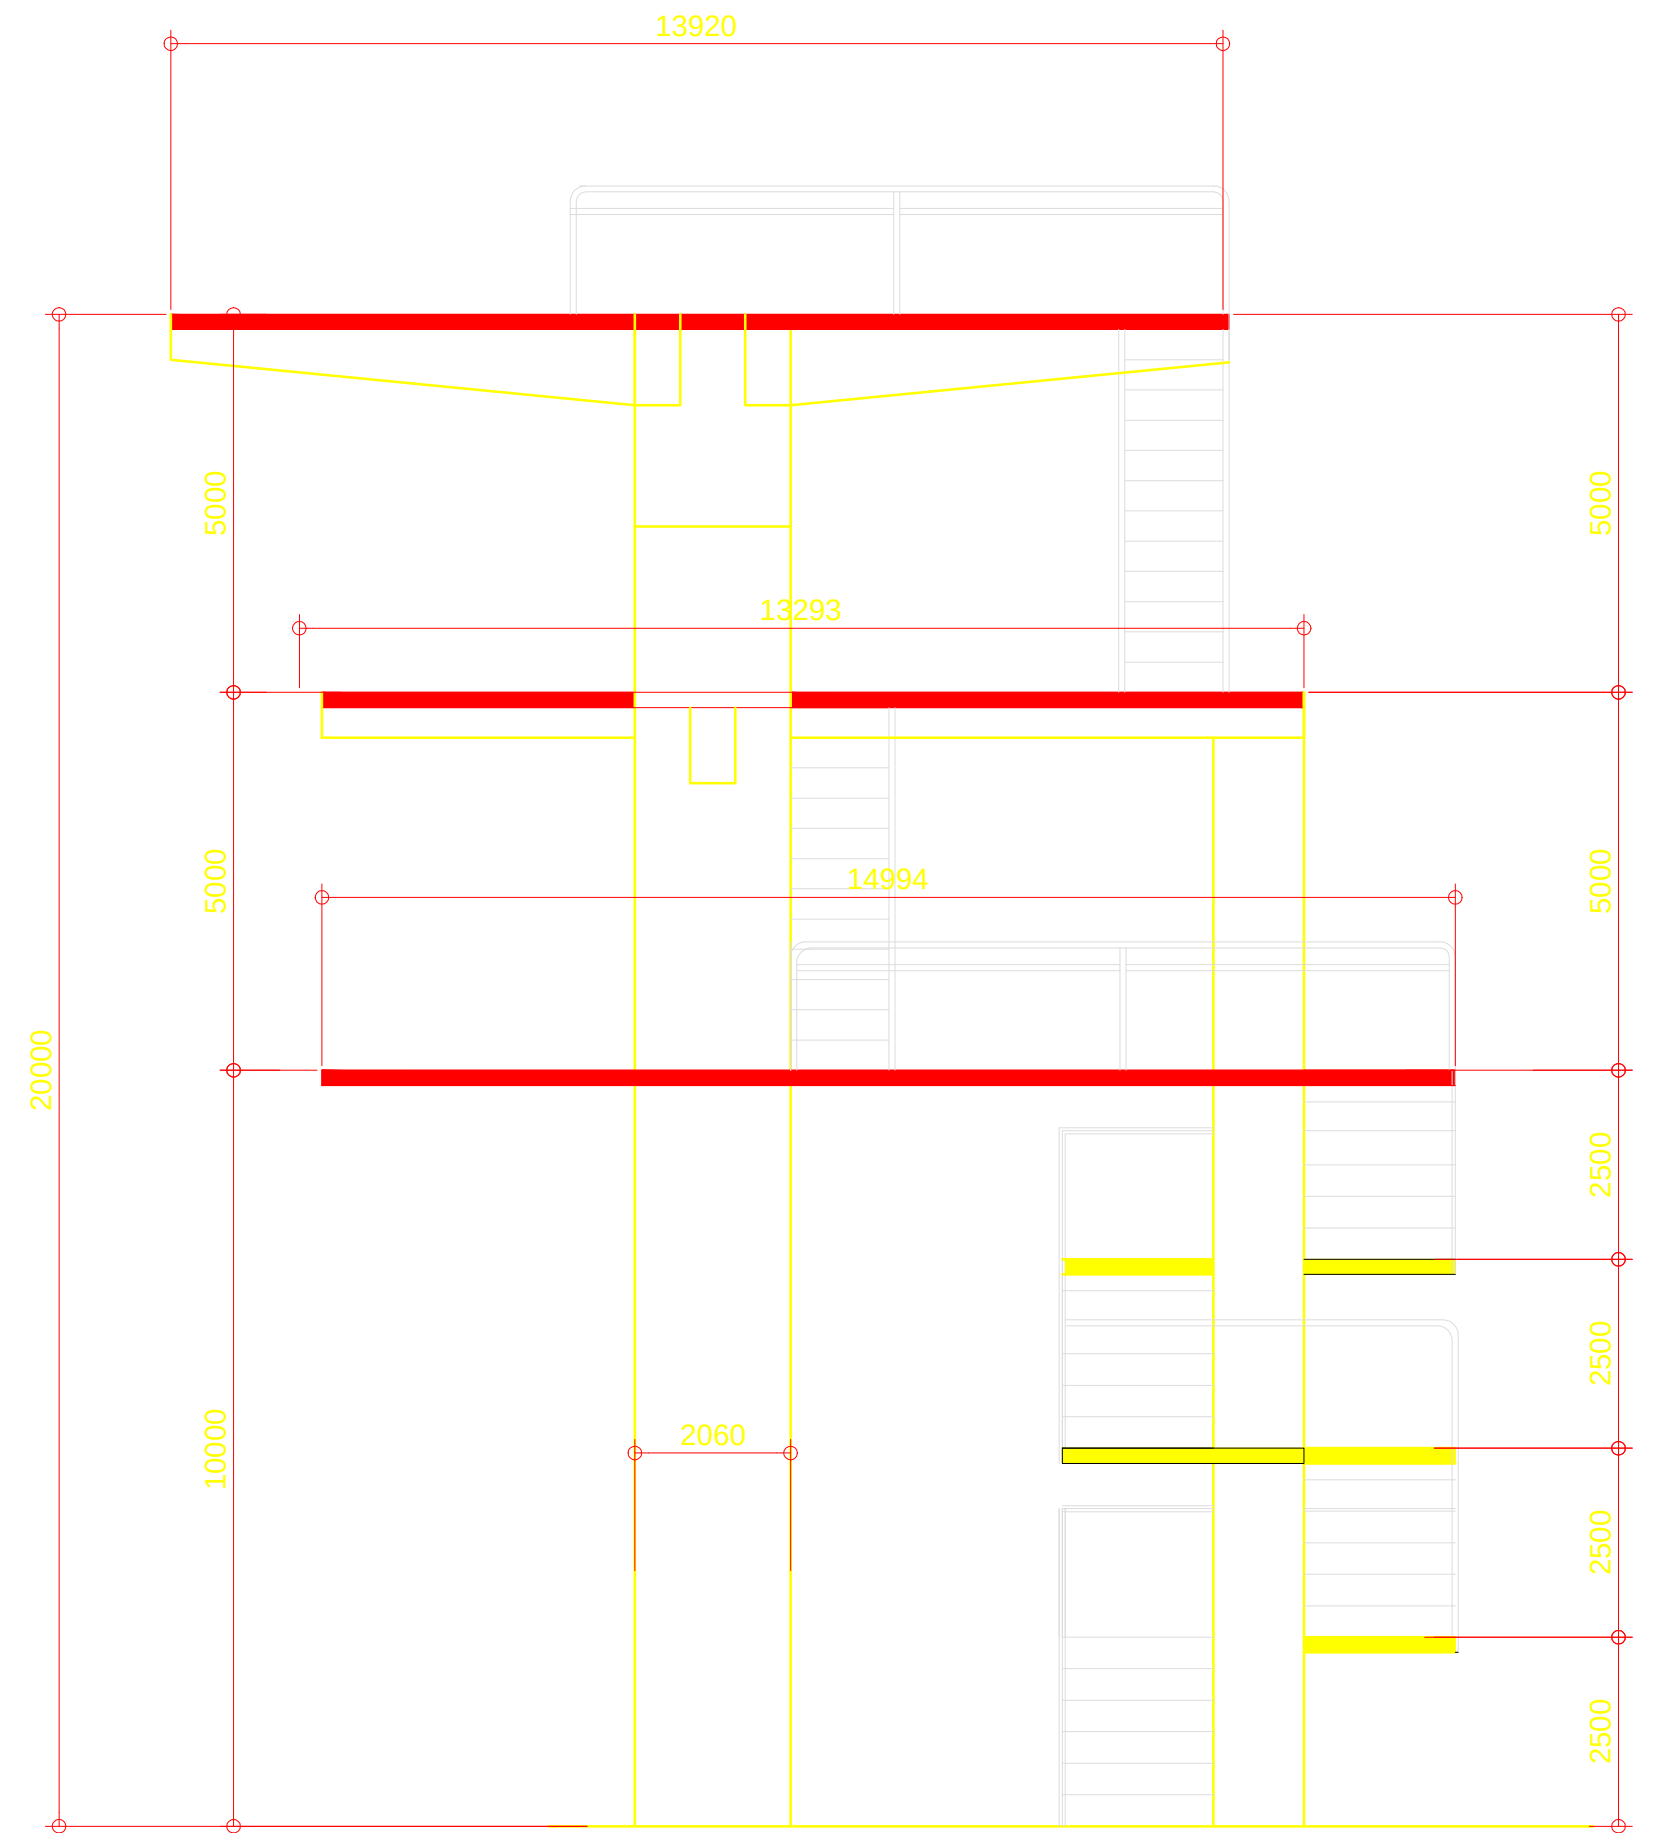


DIVING PLATFORM
SIDE ELEVATION
SCALE 1:200 MTS.


OWNER	PROJECT TITLE :	SUBMITTED BY :	RECOMMENDING APPROVAL :	APPROVED BY :	SHEET CONTENTS :	DESIGN BY :		SHEET NO :
 PHILIPPINE SPORTS COMMISSION RMSG, PABLO OCAMPO SR. ST., MALATE, MANILA	UPGRADING OF SWIMMING POOL, DIVING POOL, AND CONSTRUCTION OF NEW BLEACHERS, WARM UP POOL AND JACUZZI LOCATION: PHILSPORTS, ULTRA, MERALCO AVE., PASIG CITY	ENGR. PEDRO I. PINEDA JR. HEAD - ENGINEERING UNIT	DIR. MERLITA R. IBAY DEPUTY EXECUTIVE DIRECTOR	HON. WILLIAM I. RAMIREZ CHAIRMAN	AS SHOWN	DRAWN BY : CHECKED BY : DATE : APPROVED BY :		A 16

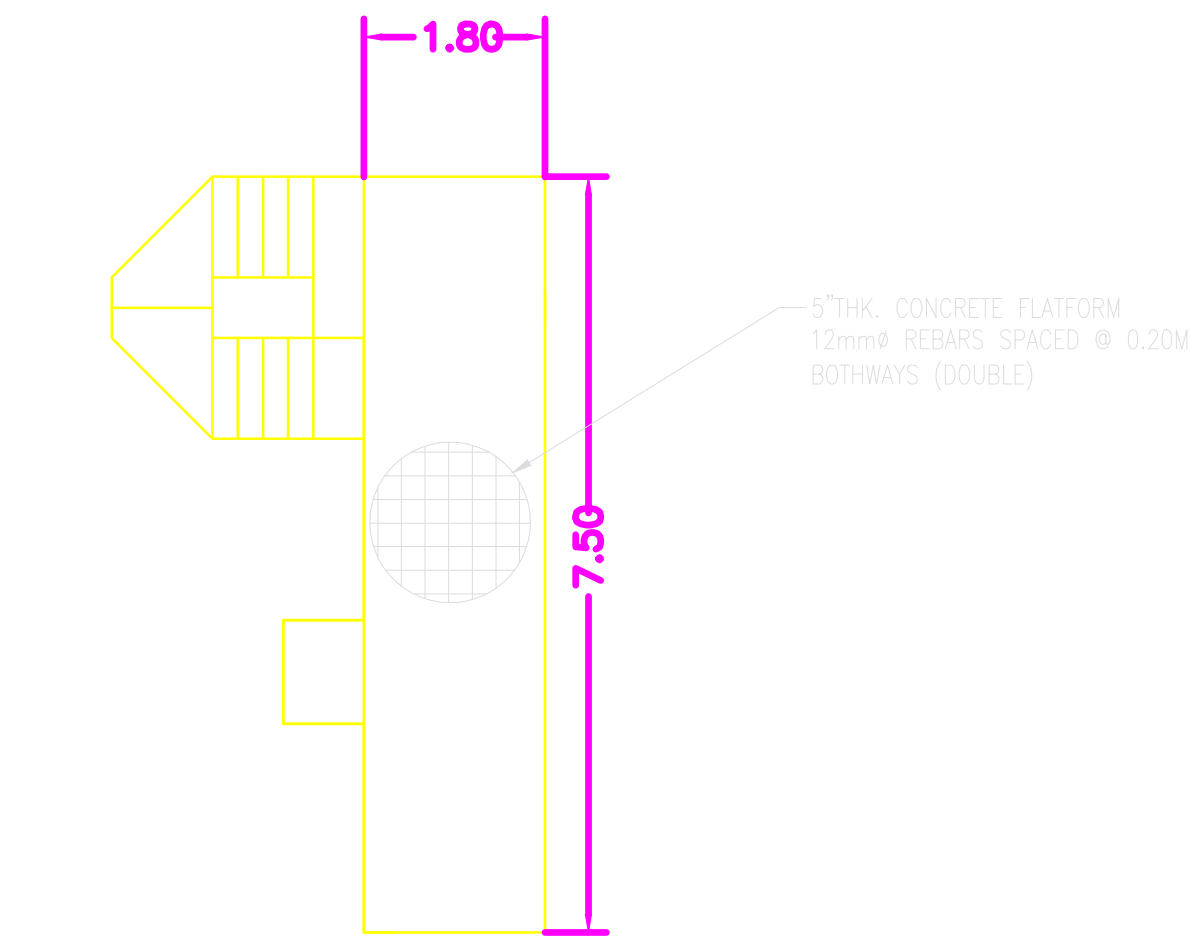


FIRST LEVEL @ 5.00M

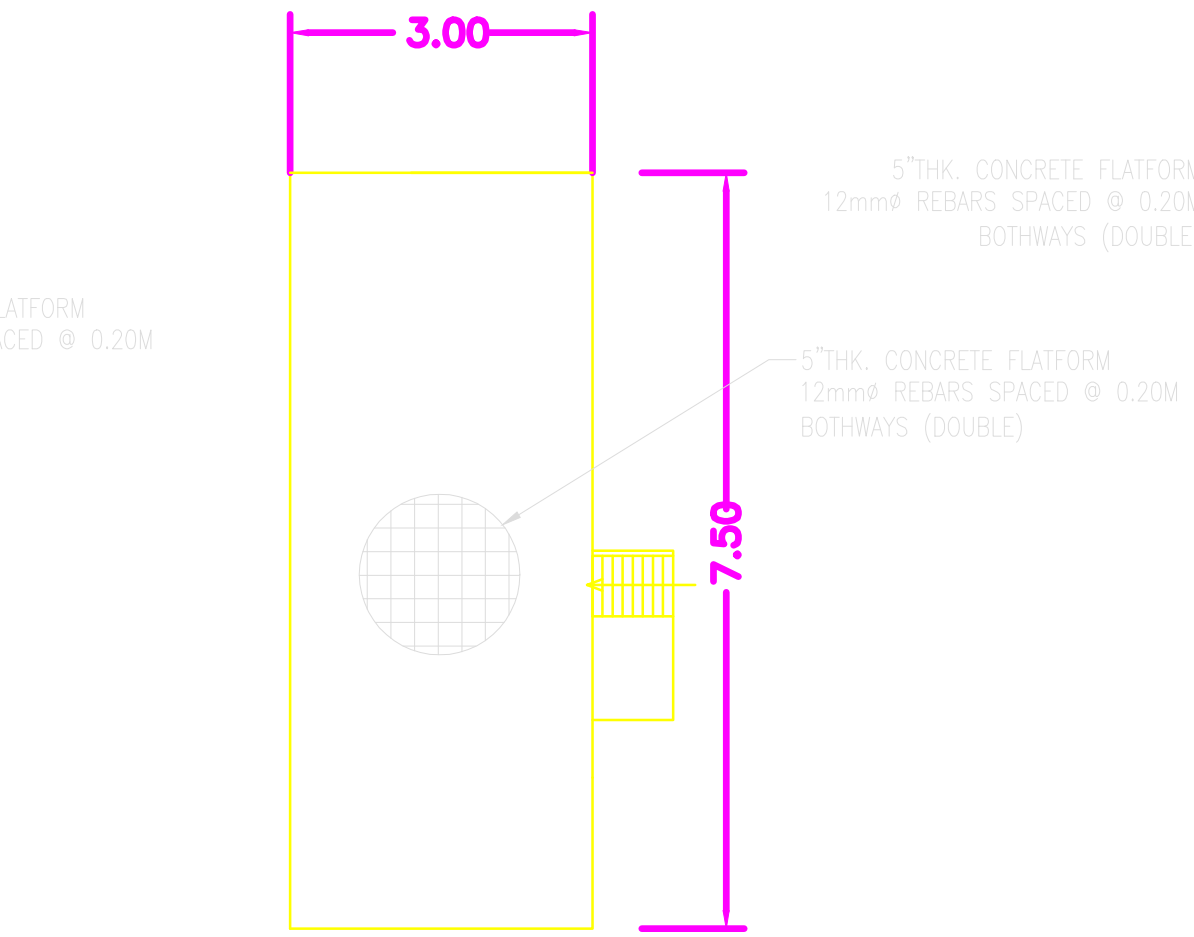


SECOND LEVEL @ 7.50M

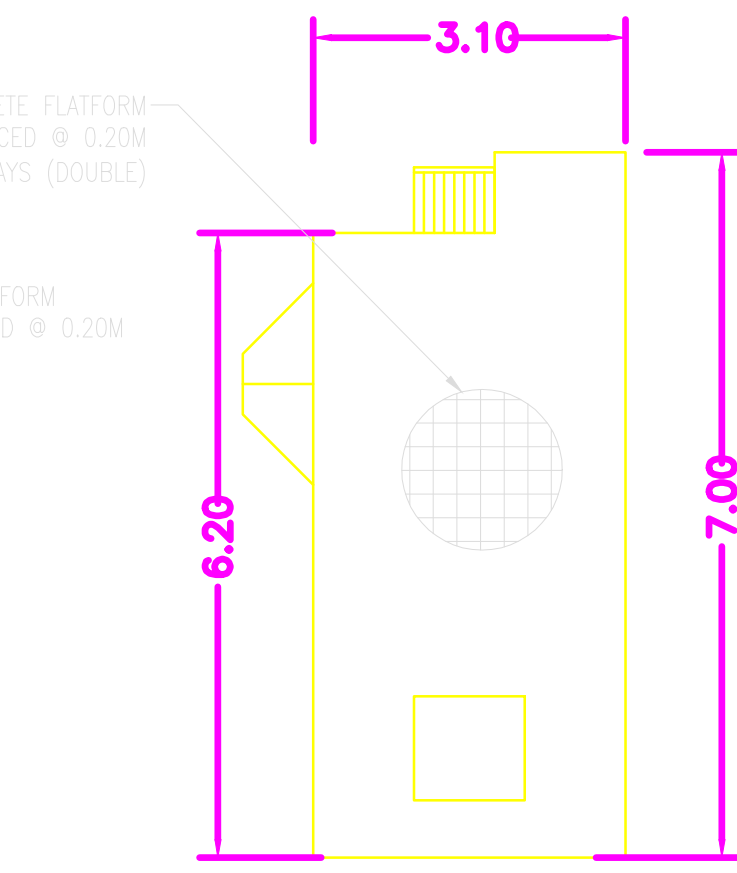


THIRD LEVEL @ 10.00M

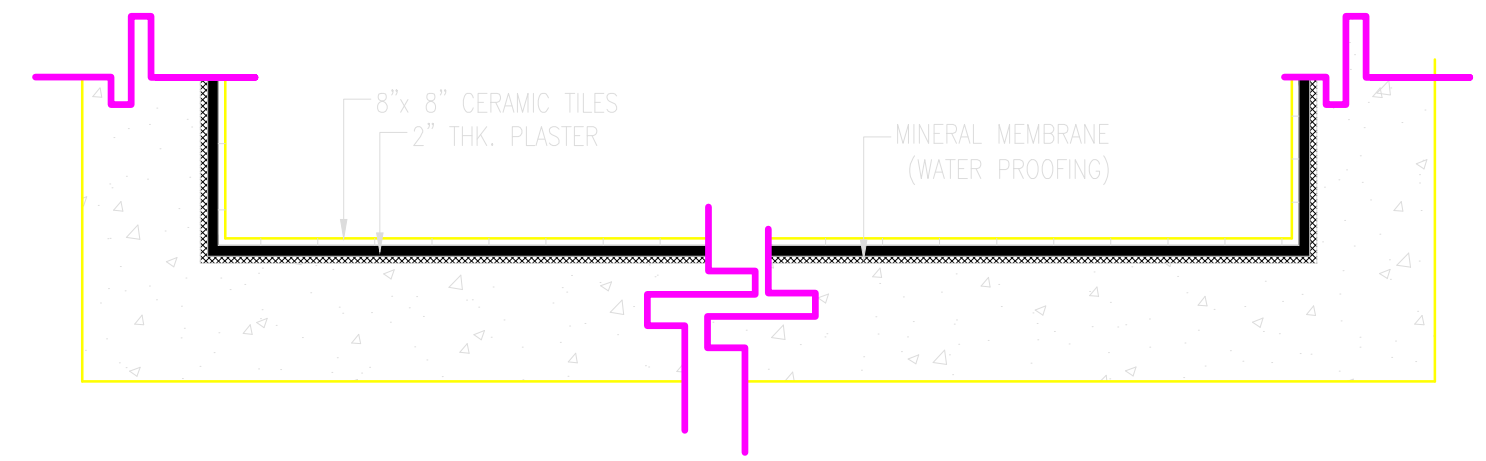



DIVING POOL FLOOR DETAILS

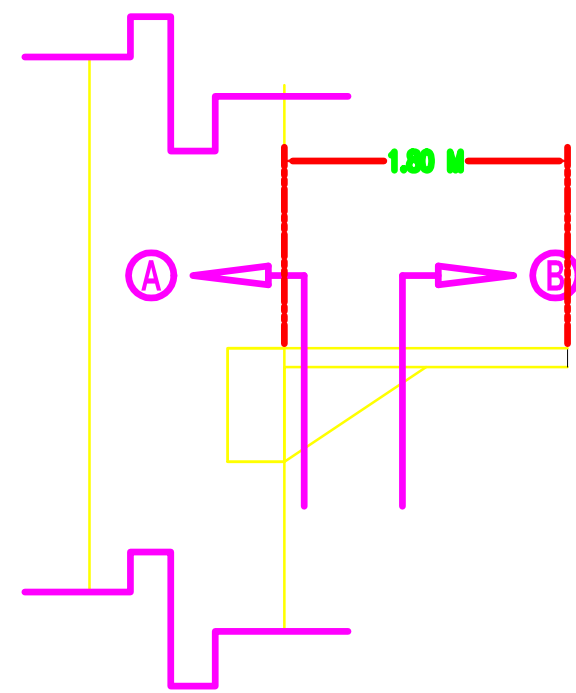


DETAILS OF 'B-3'

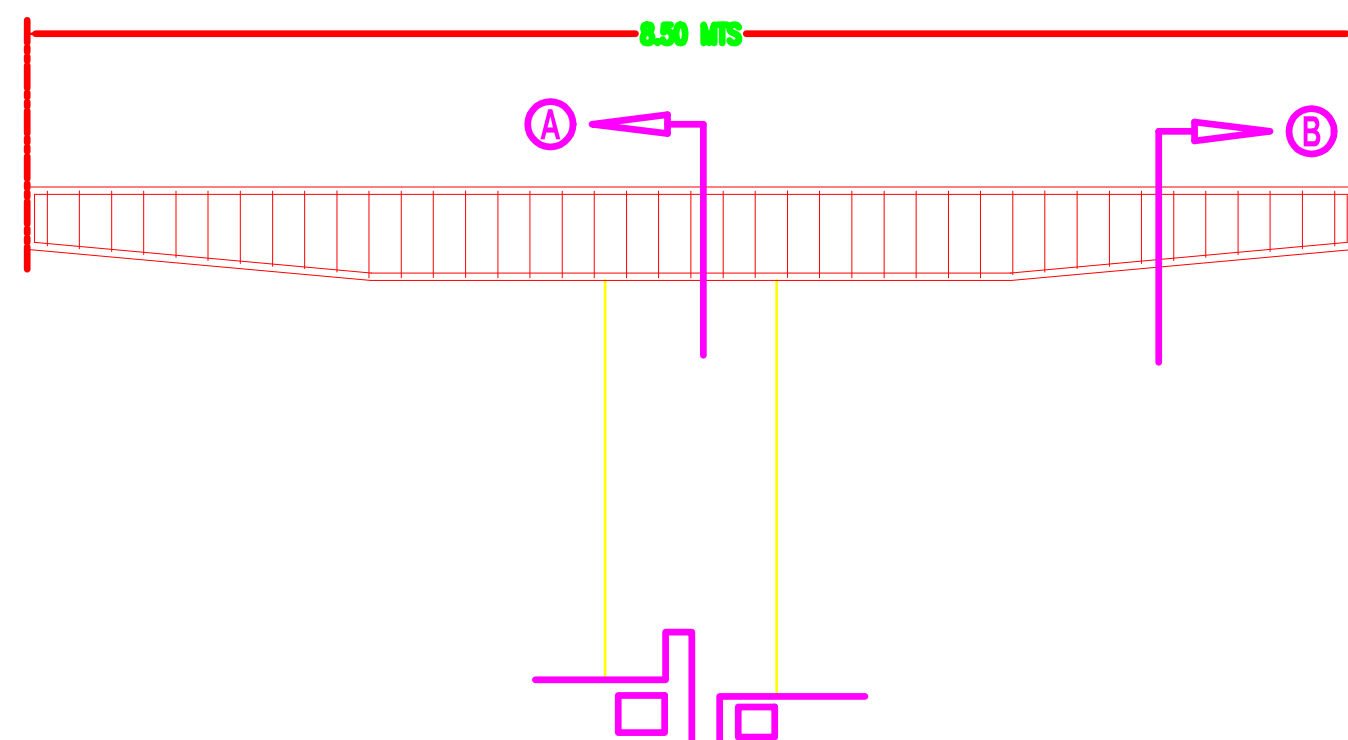


DETAILS OF 'B-4'

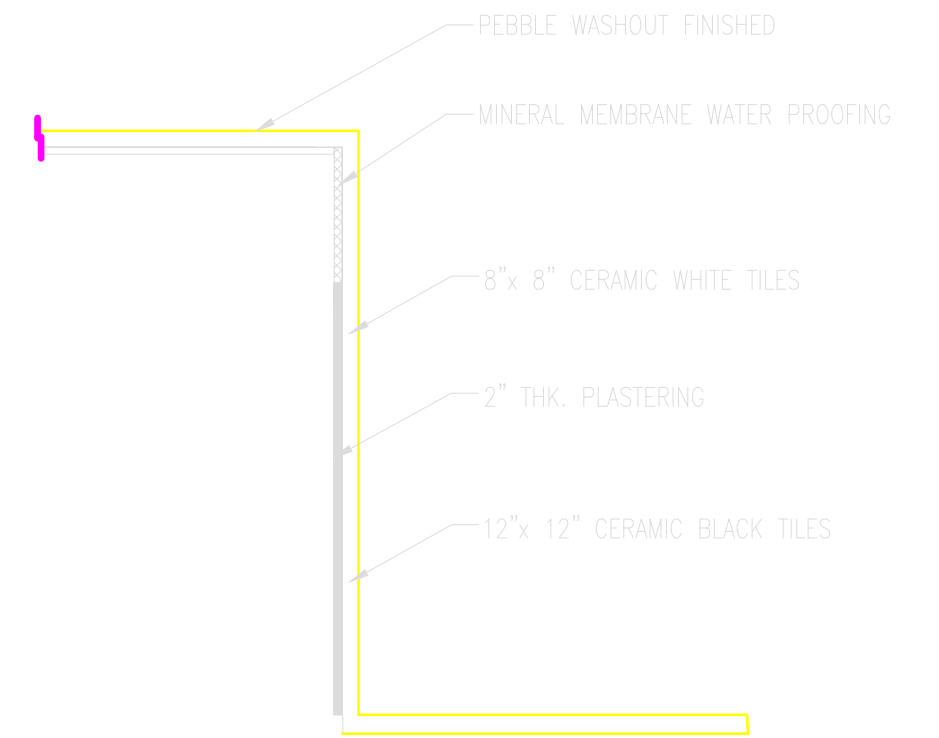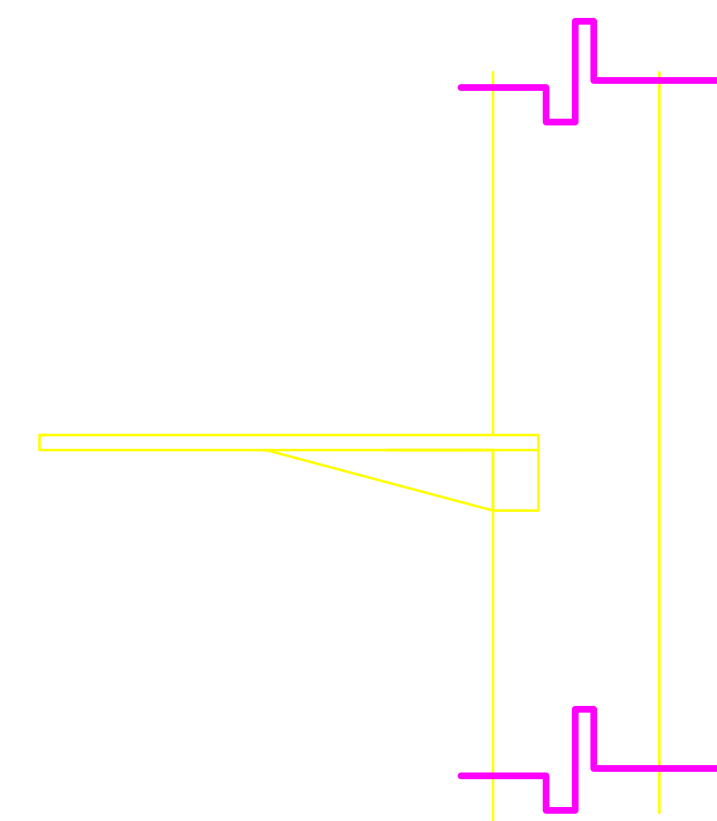


DIVING POOL DETAIL OF END WALL

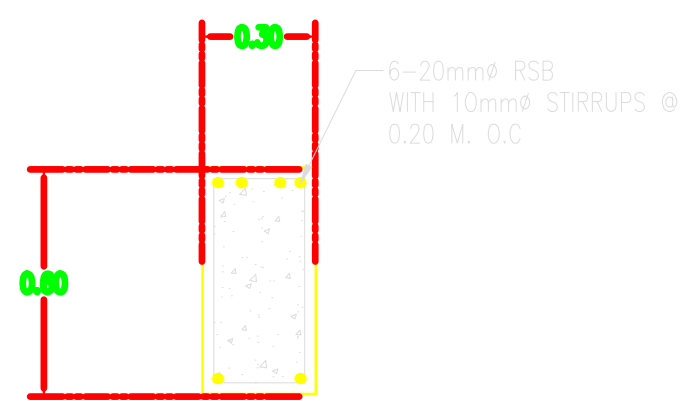


DETAILS @ 'A'

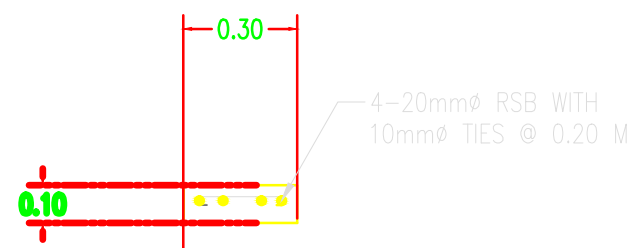


DETAILS @ 'B'

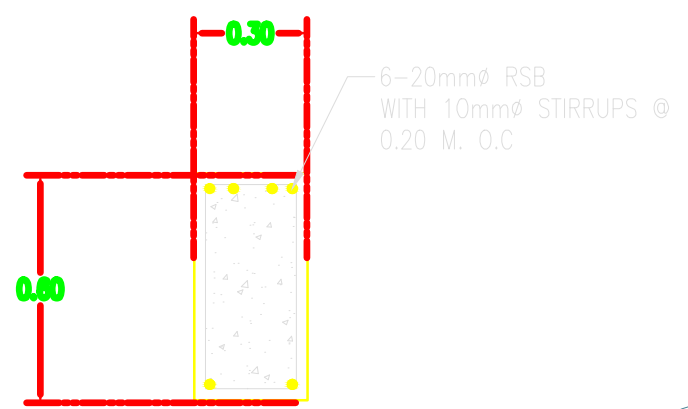


DETAILS @ 'A'

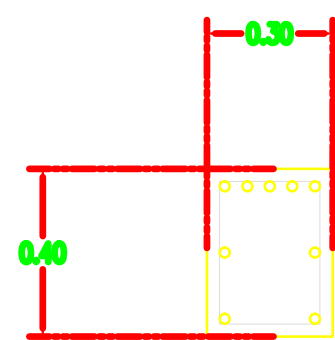

DETAILS @ 'B'

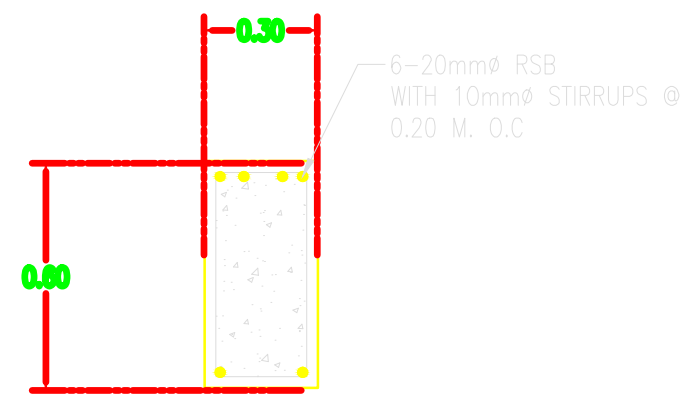


DETAILS @ 'A'

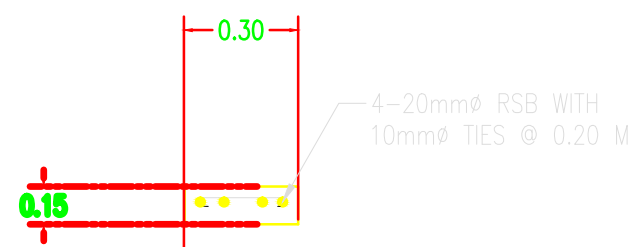


DETAILS @ 'B'

OWNER	PROJECT TITLE :	SUBMITTED BY :	RECOMMENDING APPROVAL :	APPROVED BY :	SHEET CONTENTS :	DESIGN BY :		SHEET NO :
PHILIPPINE SPORTS COMMISSION RMSC, PABLO OCAMPO SR. ST., MALATE, MANILA	UPGRADING OF SWIMMING POOL, DIVING POOL, AND CONSTRUCTION OF NEW BLEACHERS, WARM UP POOL AND JACUZZI LOCATION: PHILSPORTS, ULTRA, MERALCO AVE., PASIG CITY	ENGR. PEDRO I. PINEDA JR. HEAD - ENGINEERING UNIT	DIR. MERLITA R. IBAY DEPUTY EXECUTIVE DIRECTOR	HON. WILLIAM I. RAMIREZ CHAIRMAN	AS SHOWN	DRAWN BY :		A 17
						CHECKED BY :		
						DATE :		
						APPROVED BY :		

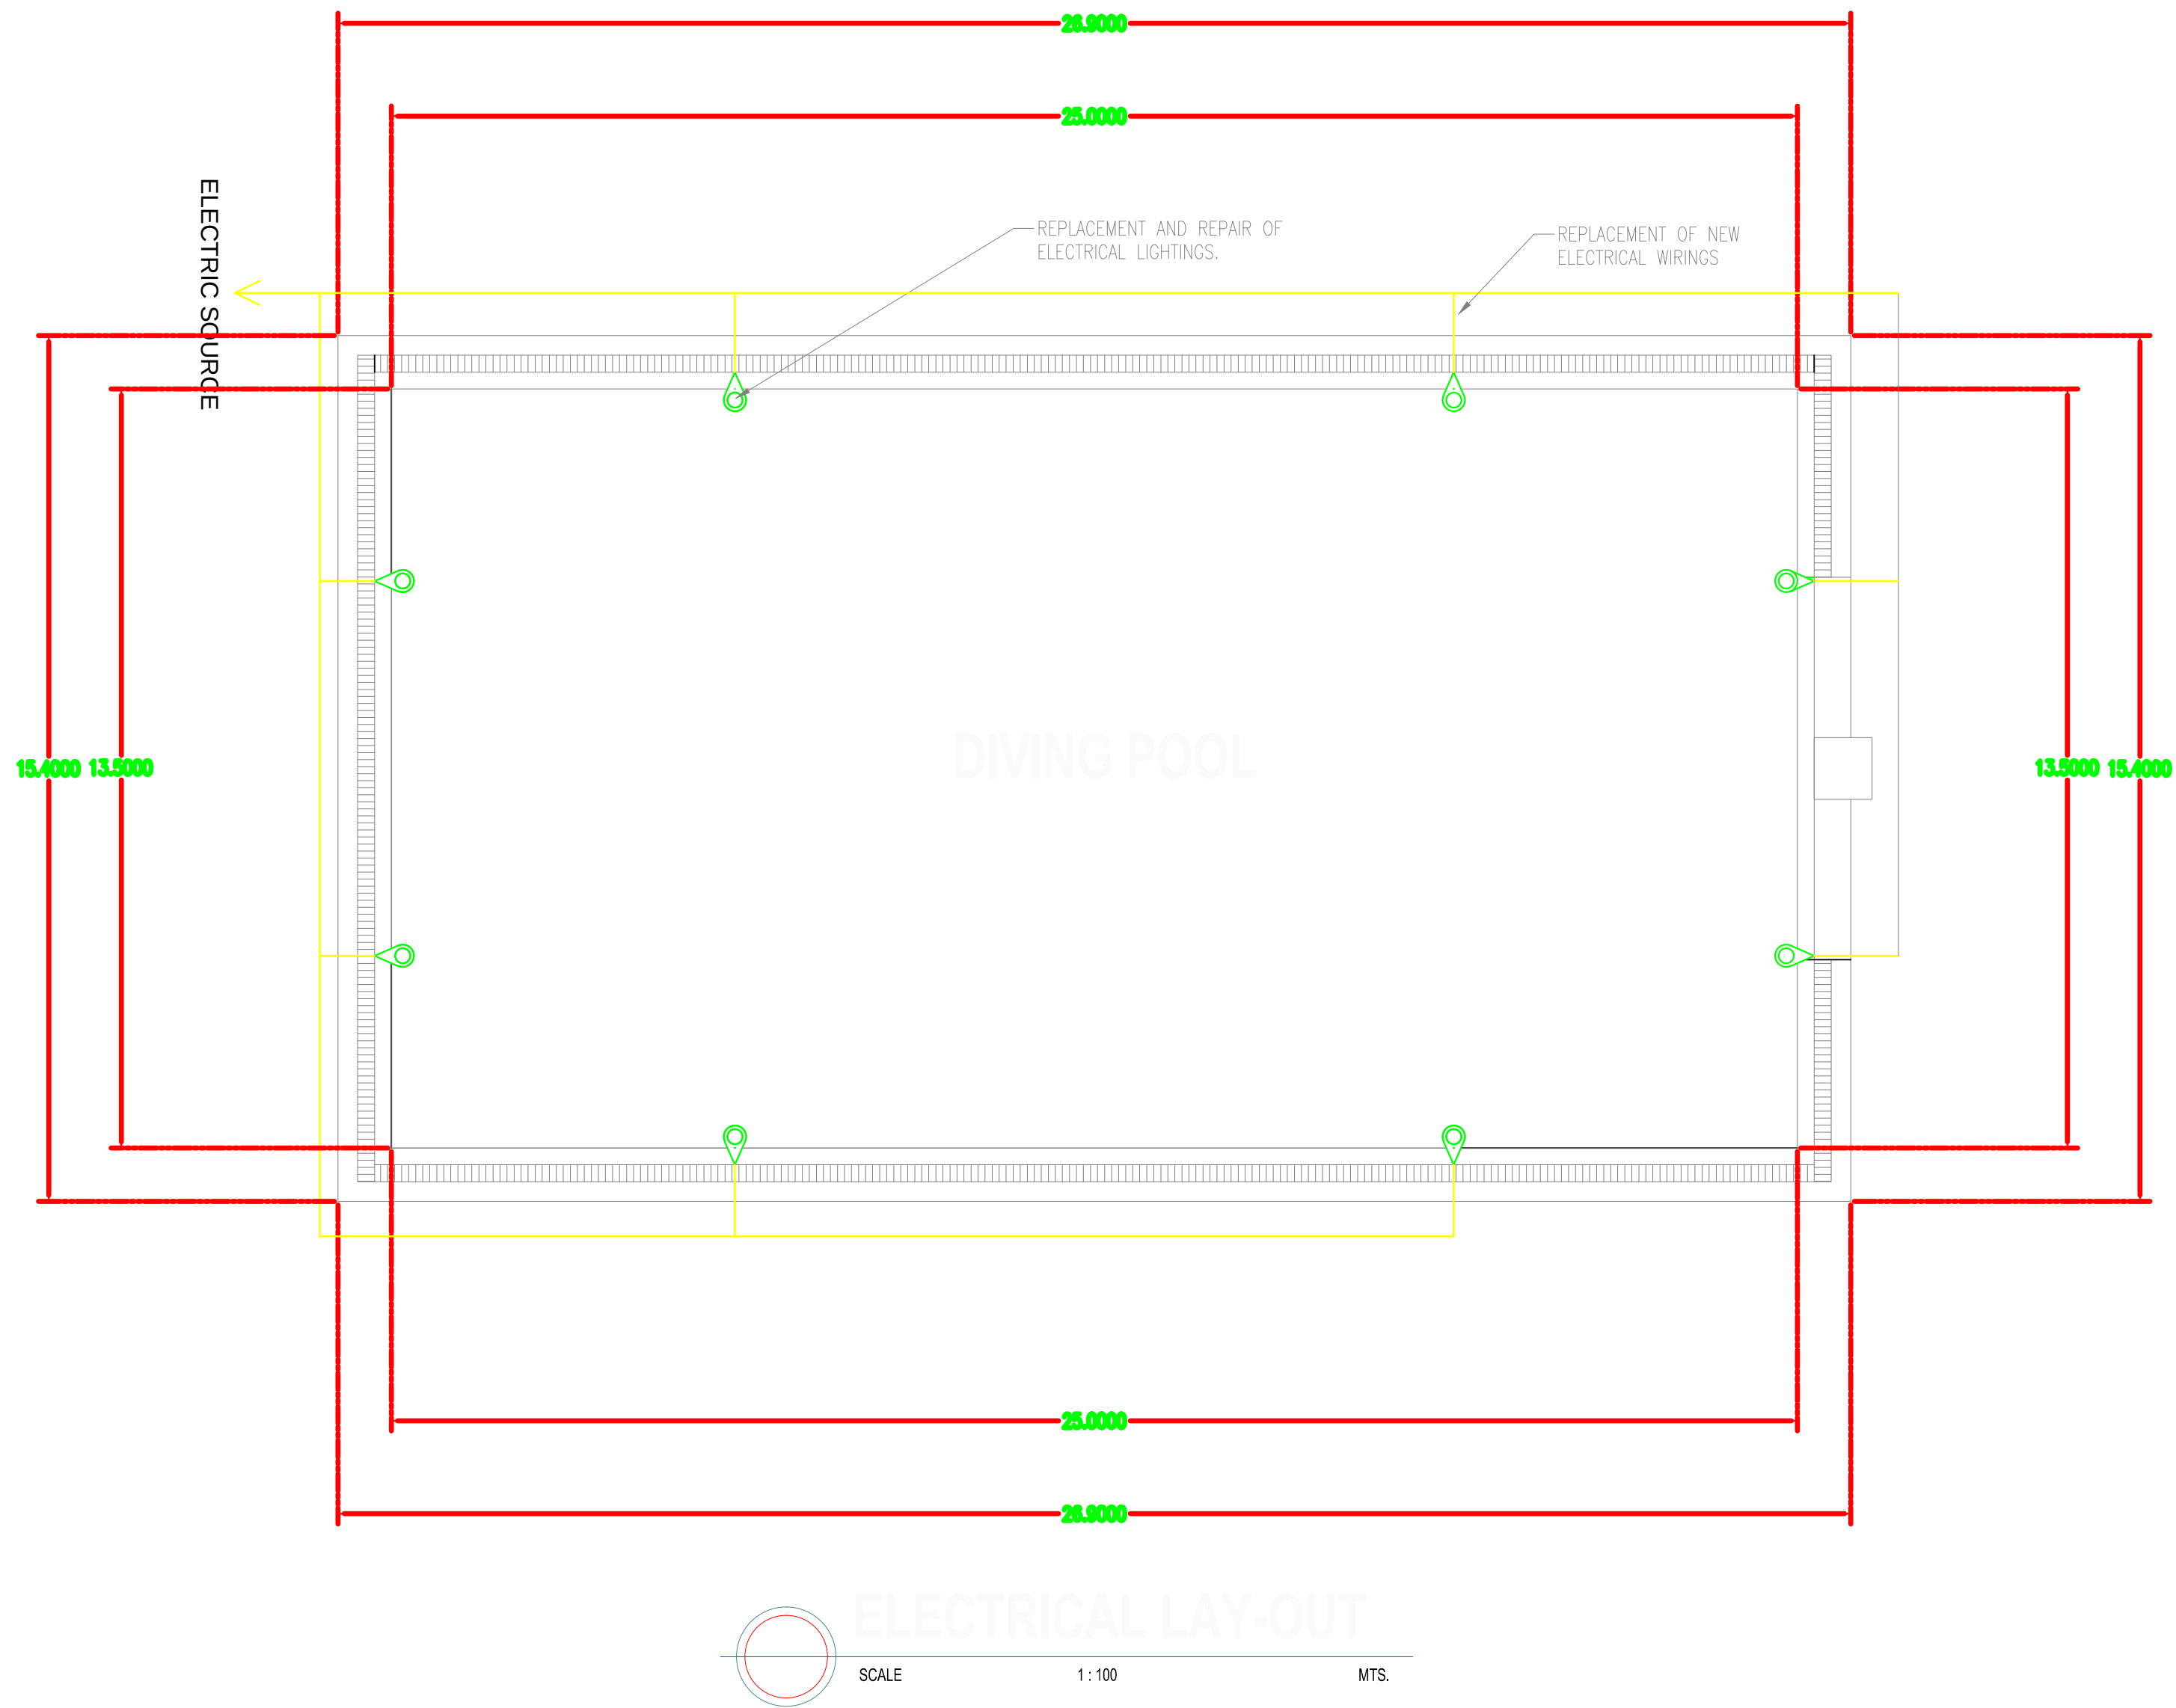


OWNER	PROJECT TITLE :	SUBMITTED BY :	RECOMMENDING APPROVAL :	APPROVED BY :	SHEET CONTENTS :	DESIGN BY :		SHEET NO :
 PHILIPPINE SPORTS COMMISSION RMSC, PABLO OCAMPO SR. ST., MALATE, MANILA	UPGRADING OF SWIMMING POOL, DIVING POOL, AND CONSTRUCTION OF NEW BLEACHERS, WARM UP POOL AND JACUZZI LOCATION: PHILSPORTS, ULTRA, MERALCO AVE., PASIG CITY	ENGR. PEDRO I. PINEDA JR. HEAD - ENGINEERING UNIT	DIR. MERLITA R. IBAY DEPUTY EXECUTIVE DIRECTOR	HON. WILLIAM I. RAMIREZ CHAIRMAN	AS SHOWN	DRAWN BY :		A 18
						CHECKED BY :		
						DATE :		
						APPROVED BY :		

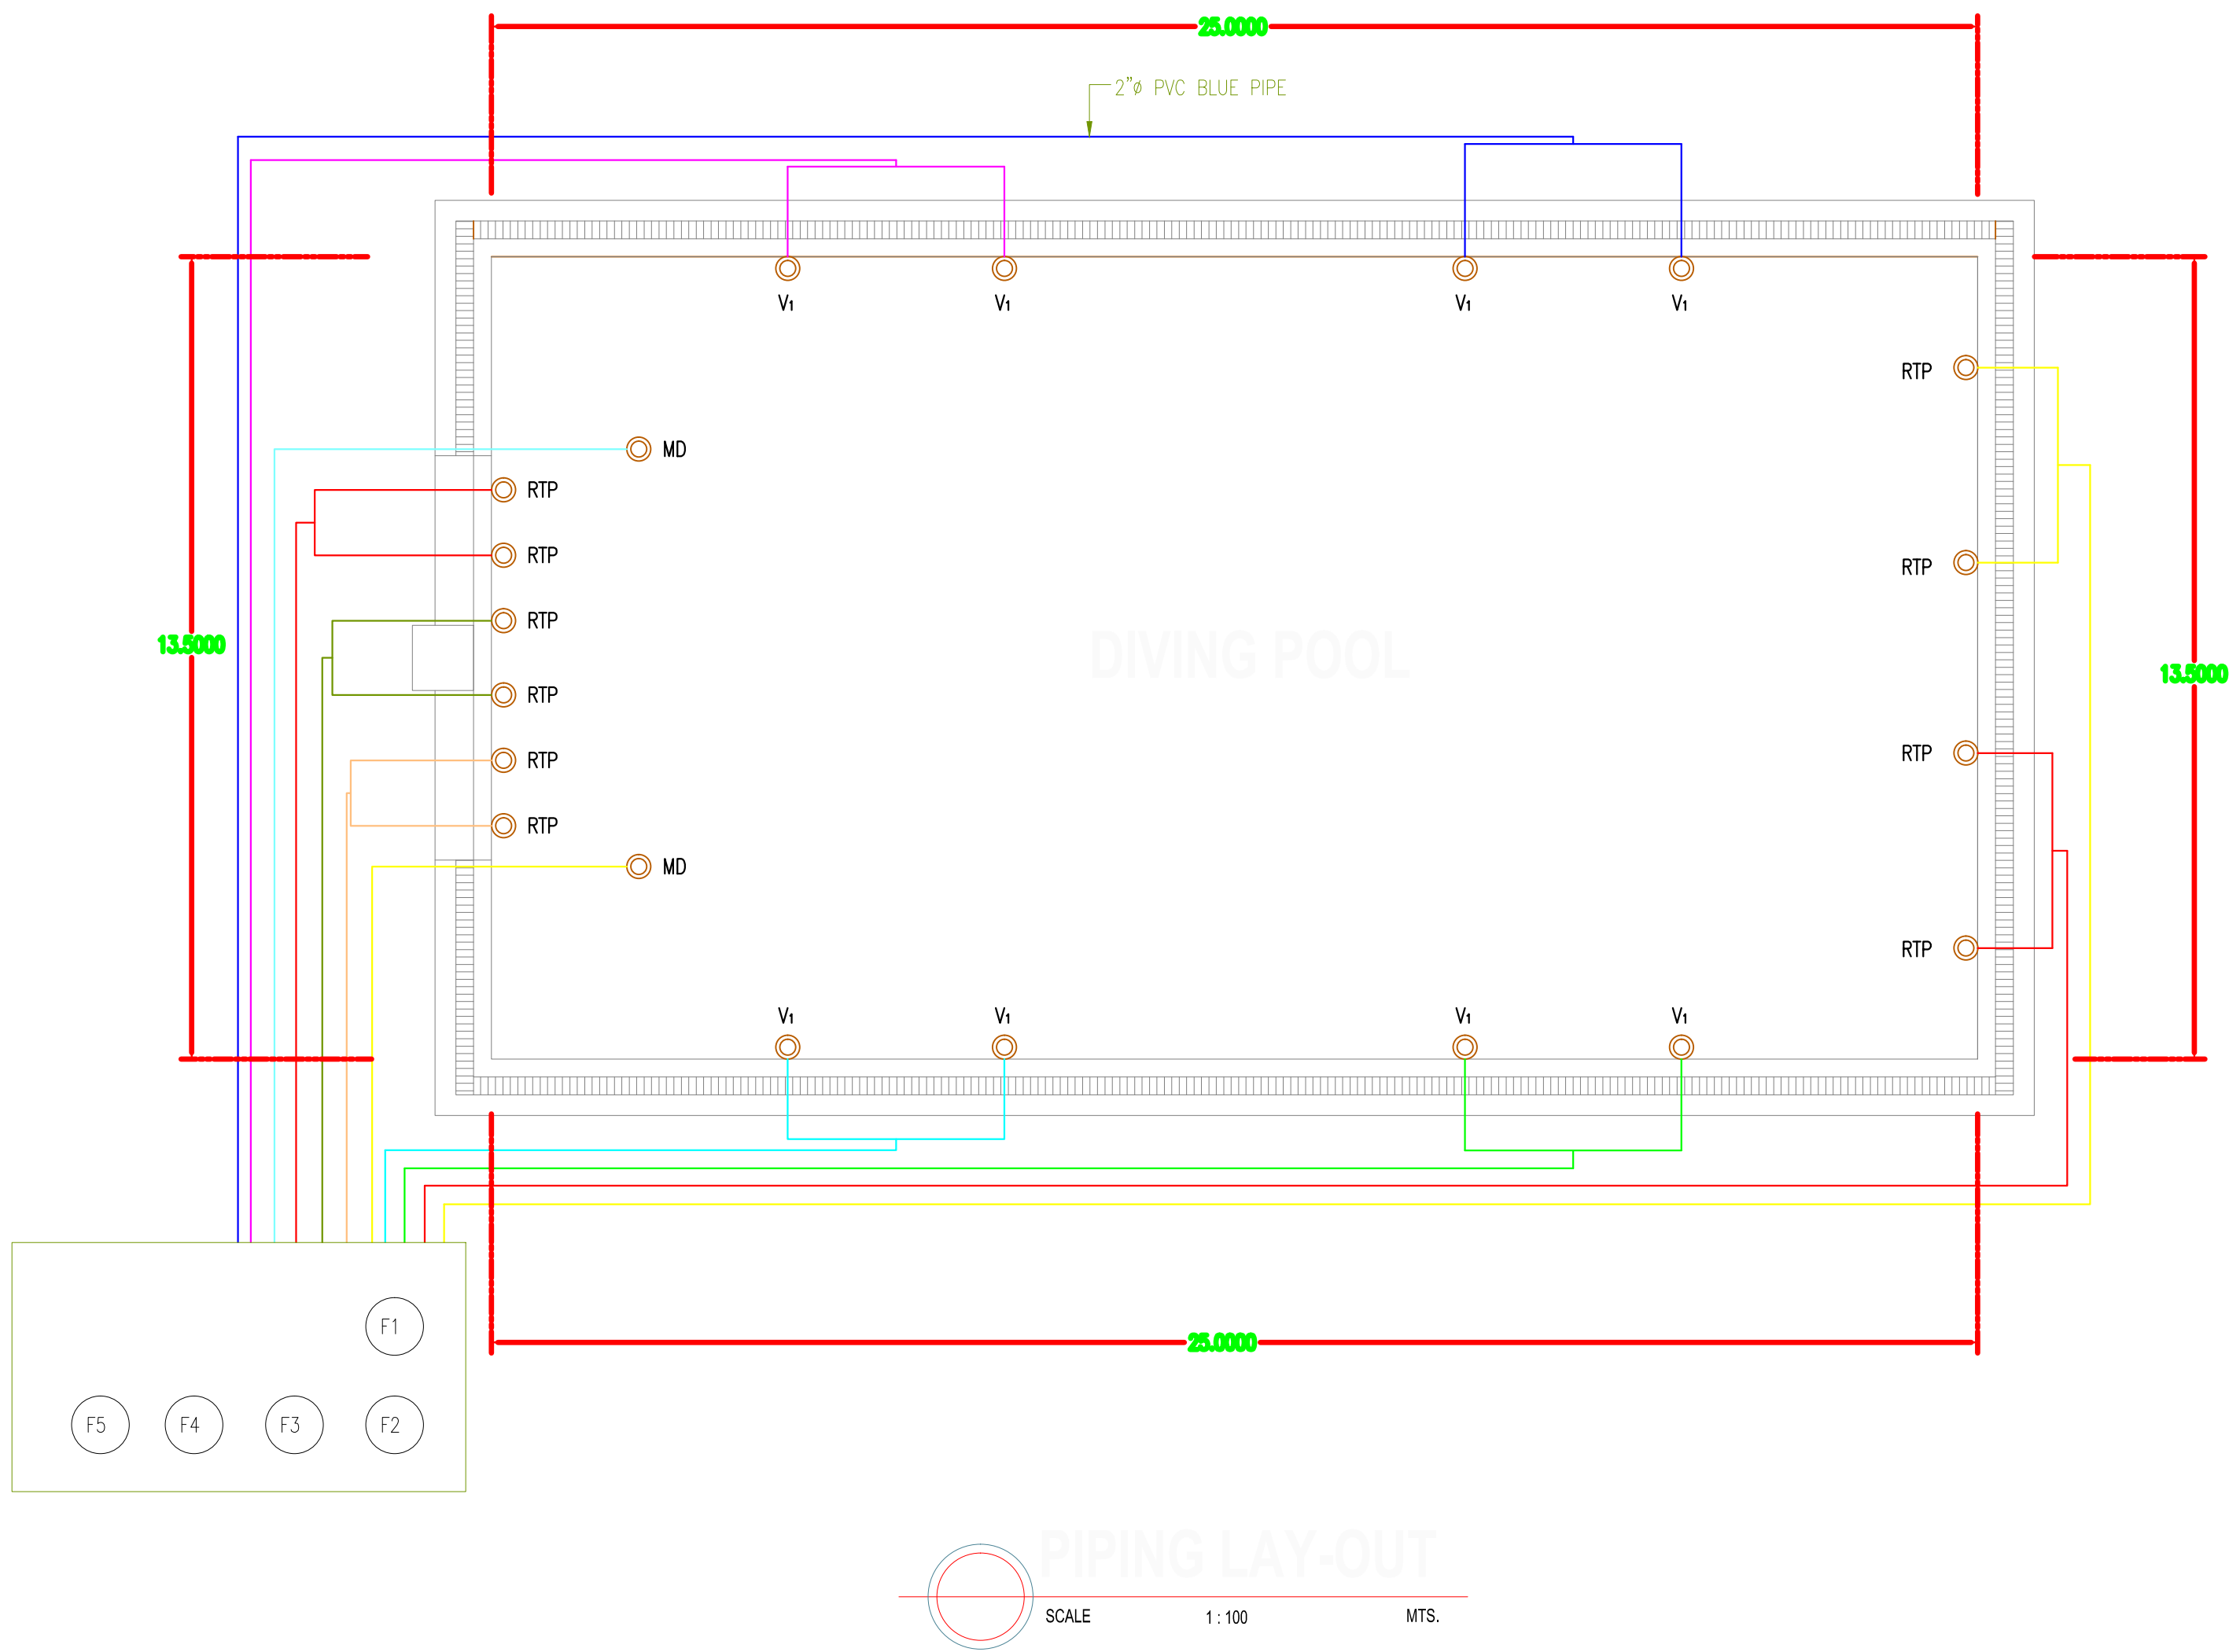

LEGENDS:

- MD - MAIN DRAIN
- RTP - RETURN TO POOL
- V1 - VACUUM


OWNER	PROJECT TITLE :	SUBMITTED BY :	RECOMMENDING APPROVAL :	APPROVED BY :	SHEET CONTENTS :	DESIGN BY :		SHEET NO :
 PHILIPPINE SPORTS COMMISSION RMSG, PABLO OCAMPO SR. ST., MALATE, MANILA	UPGRADING OF SWIMMING POOL, DIVING POOL, AND CONSTRUCTION OF NEW BLEACHERS, WARM UP POOL AND JACUZZI LOCATION: PHILSPORTS, ULTRA, MERALCO AVE., PASIG CITY	ENGR. PEDRO I. PINEDA JR. HEAD - ENGINEERING UNIT	DIR. MERLITA R. IBAY DEPUTY EXECUTIVE DIRECTOR	HON. WILLIAM I. RAMIREZ CHAIRMAN	AS SHOWN	DRAWN BY :		A 19
						CHECKED BY :		
						DATE :		
						APPROVED BY :		

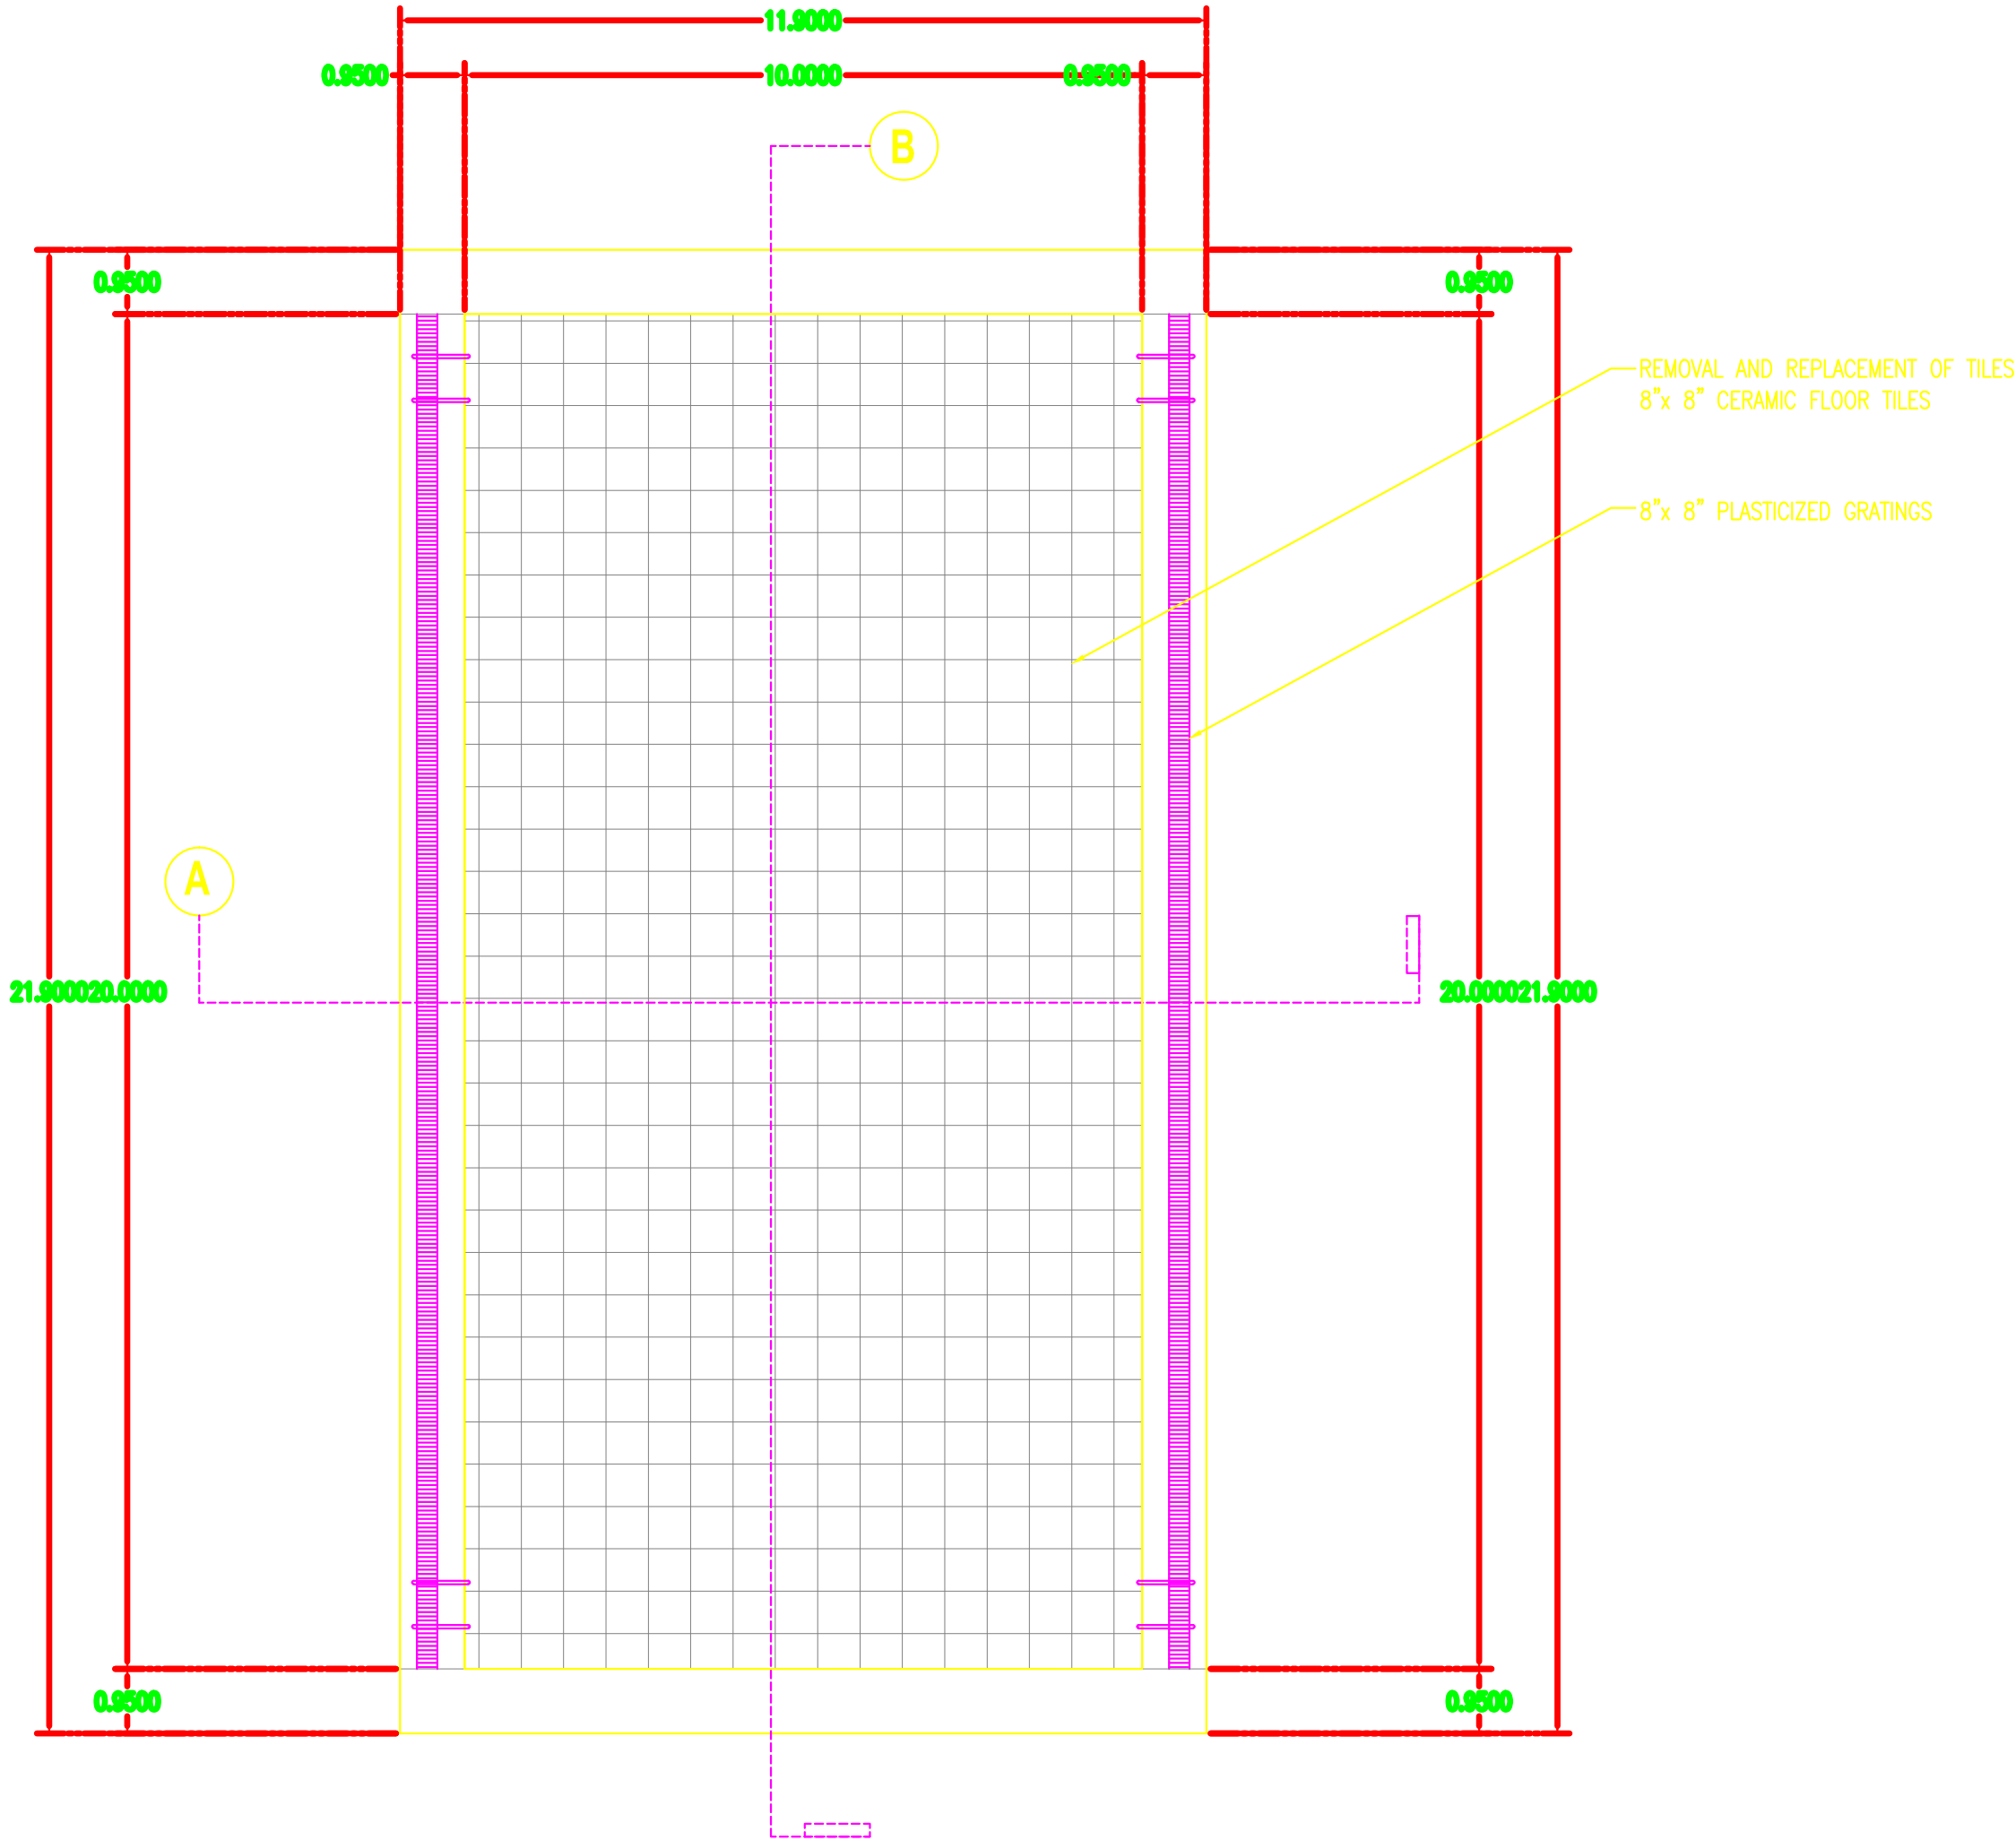

PROPOSED WARM-UP POOL PLAN


SCALE 1 : 100 MTS.

OWNER	PROJECT TITLE :	SUBMITTED BY :	RECOMMENDING APPROVAL :	APPROVED BY :	SHEET CONTENTS :	DESIGN BY :		SHEET NO :
 PHILIPPINE SPORTS COMMISSION RMSG, PABLO OCAMPO SR. ST., MALATE, MANILA	UPGRADING OF SWIMMING POOL, DIVING POOL, AND CONSTRUCTION OF NEW BLEACHERS, WARM UP POOL AND JACUZZI LOCATION: PHILSPORTS, ULTRA, MERALCO AVE., PASIG CITY	ENGR. PEDRO I. PINEDA JR. HEAD - ENGINEERING UNIT	DIR. MERLITA R. IBAY DEPUTY EXECUTIVE DIRECTOR	HON. WILLIAM I. RAMIREZ CHAIRMAN	AS SHOWN	DRAWN BY :		A 20
						CHECKED BY :		
						DATE :		
						APPROVED BY :		

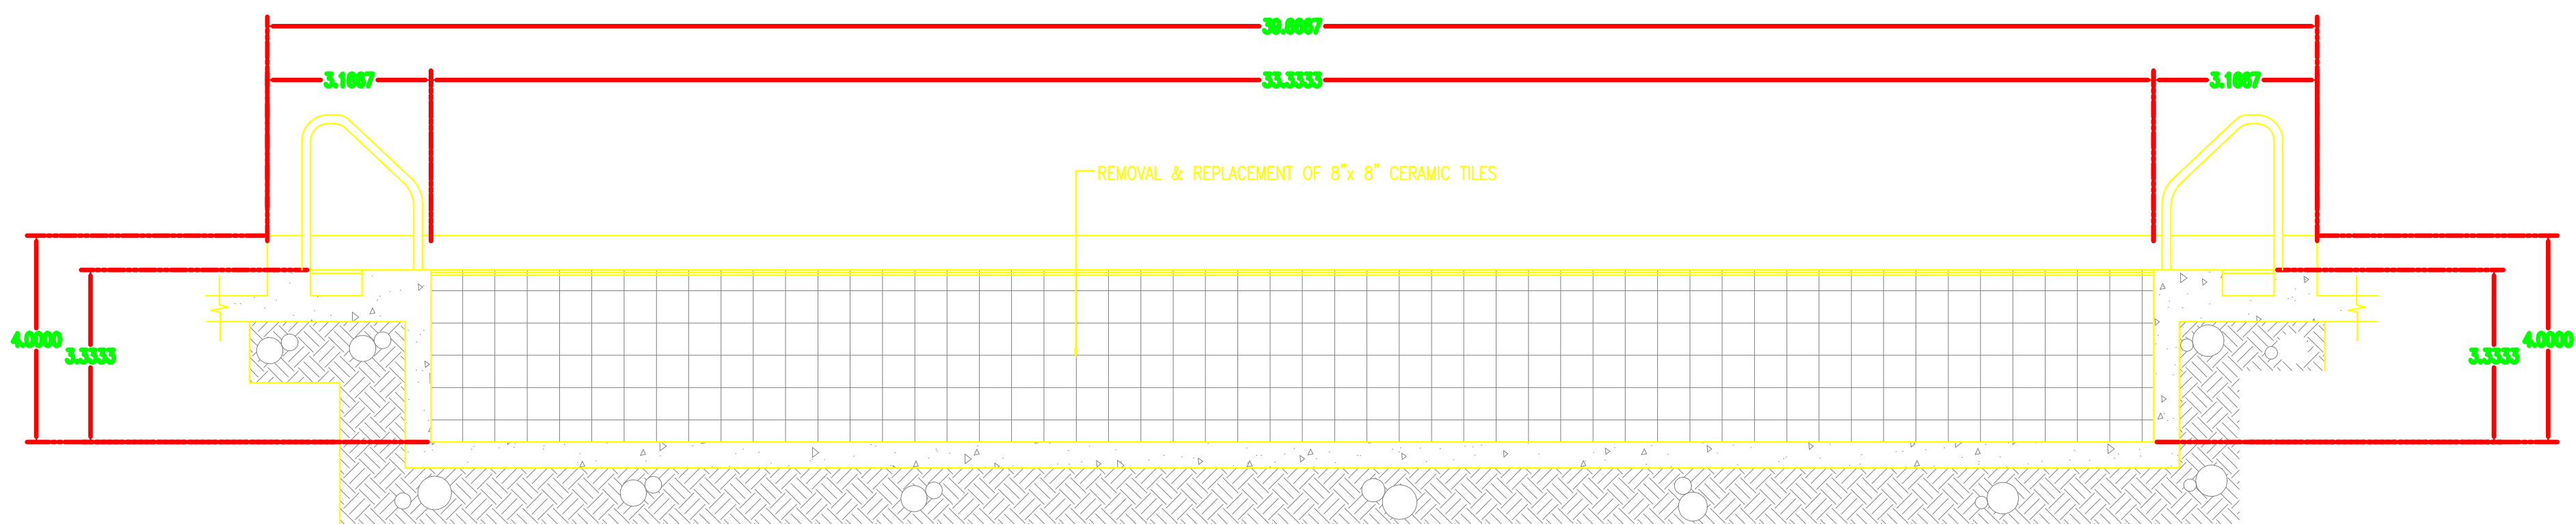

SECTION THRU "A"













SCALE 1:30 MTS.

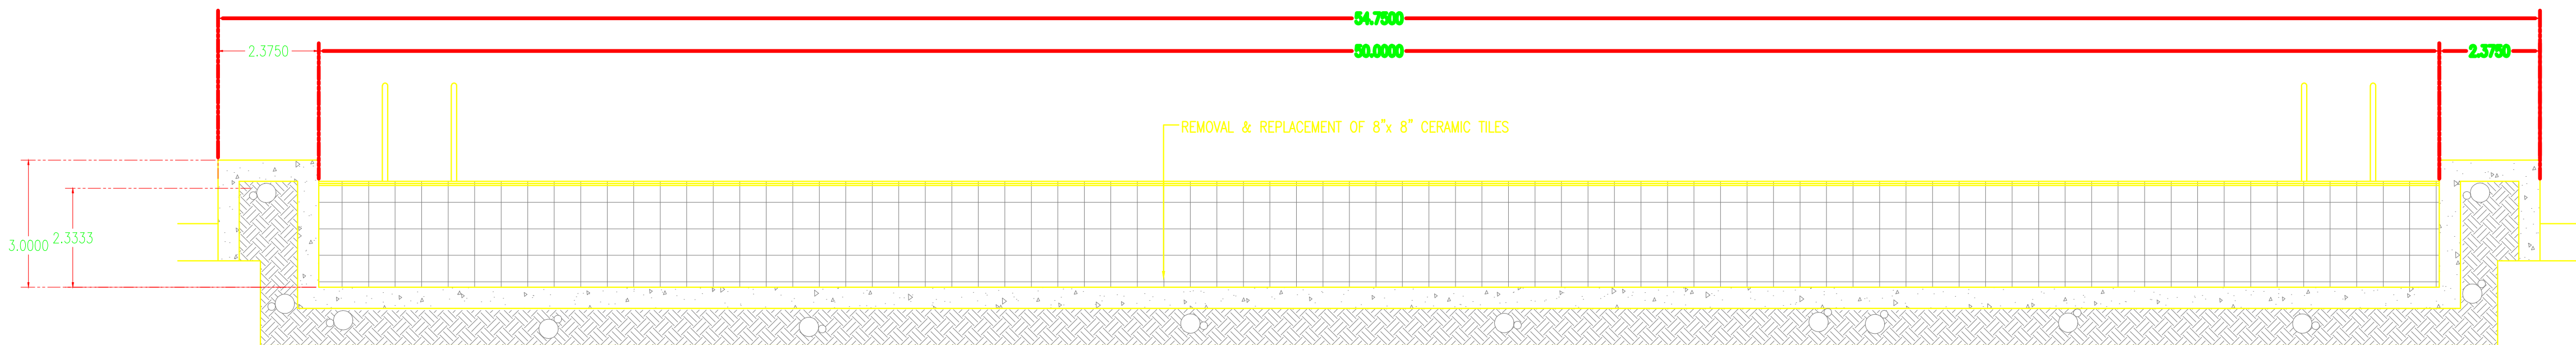

SECTION THRU "B"

SCALE 1:40 MTS.

OWNER	PROJECT TITLE :	SUBMITTED BY :	RECOMMENDING APPROVAL :	APPROVED BY :	SHEET CONTENTS :	DESIGN BY :		SHEET NO :
 PHILIPPINE SPORTS COMMISSION RMSC, PABLO OCAMPO SR. ST., MALATE, MANILA	UPGRADING OF SWIMMING POOL, DIVING POOL, AND CONSTRUCTION OF NEW BLEACHERS, WARM UP POOL AND JACUZZI LOCATION: PHILSPORTS, ULTRA, MERALCO AVE., PASIG CITY	ENGR. PEDRO I. PINEDA JR. HEAD - ENGINEERING UNIT	DIR. MERLITA R. IBAY DEPUTY EXECUTIVE DIRECTOR	HON. WILLIAM I. RAMIREZ CHAIRMAN	AS SHOWN	DRAWN BY :		A 21
						CHECKED BY :		
						DATE :		
						APPROVED BY :		

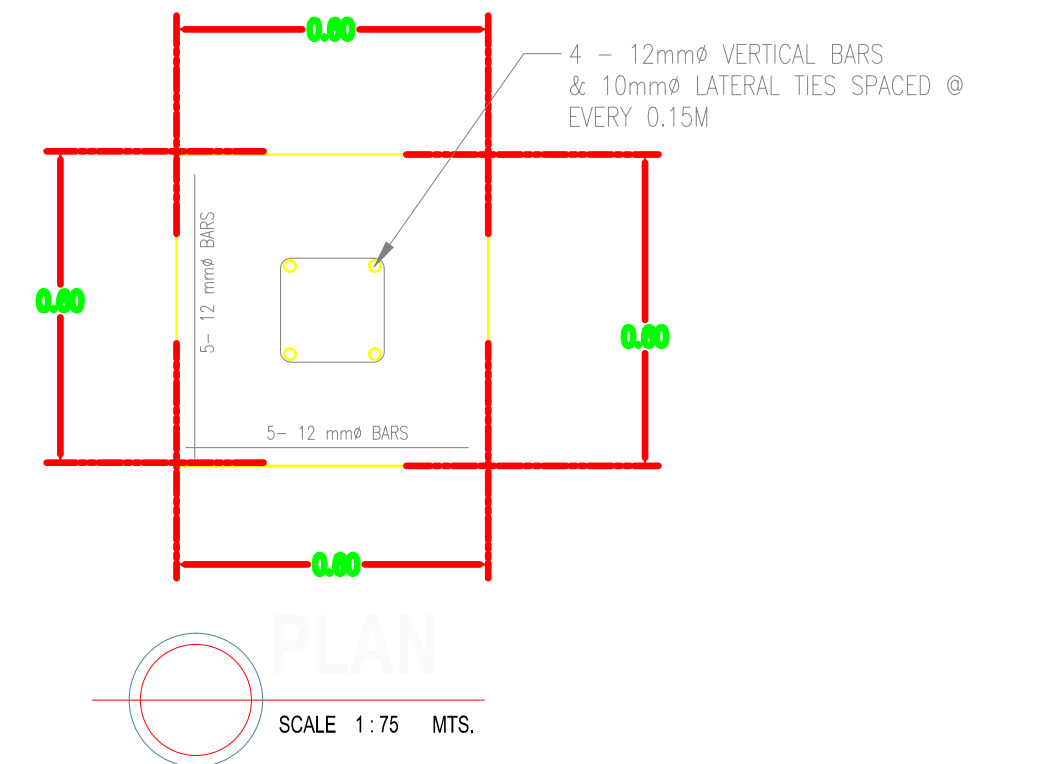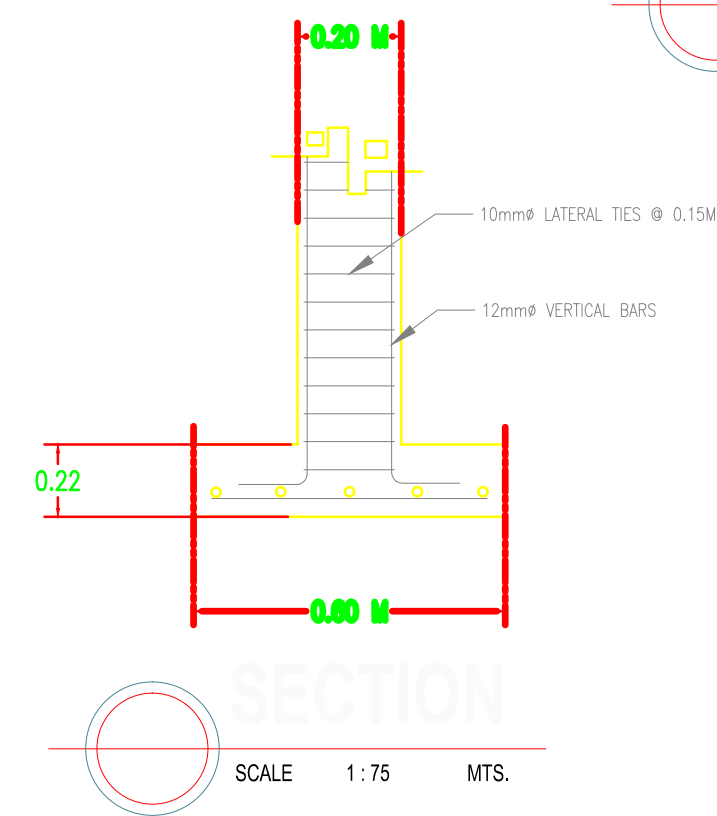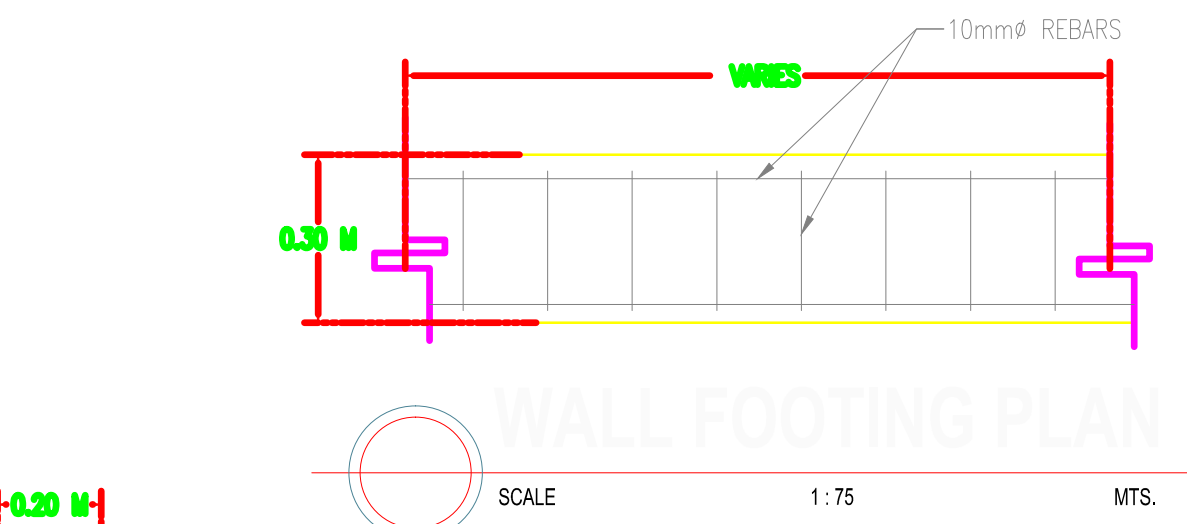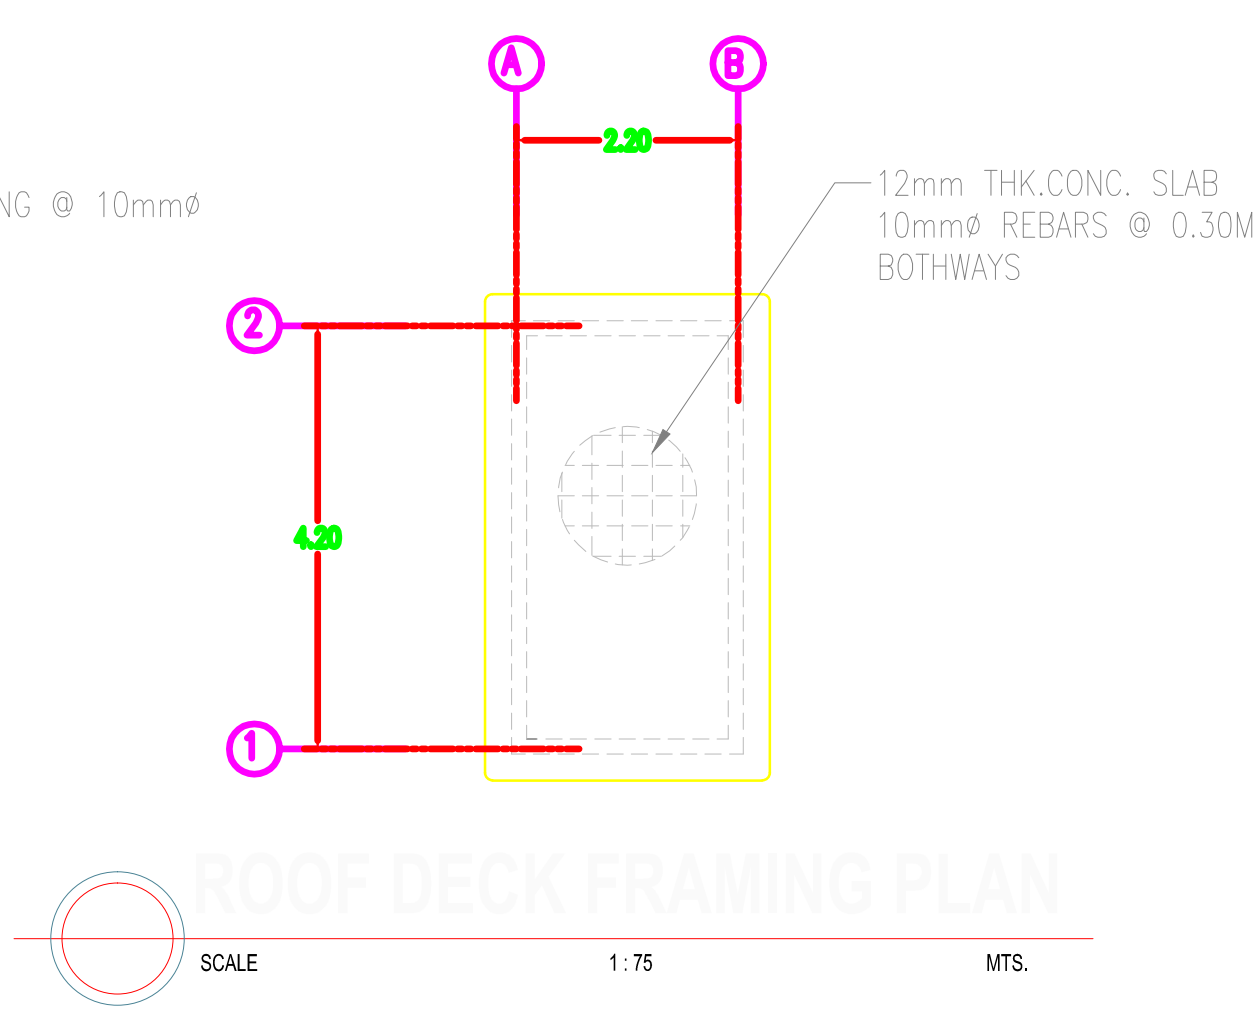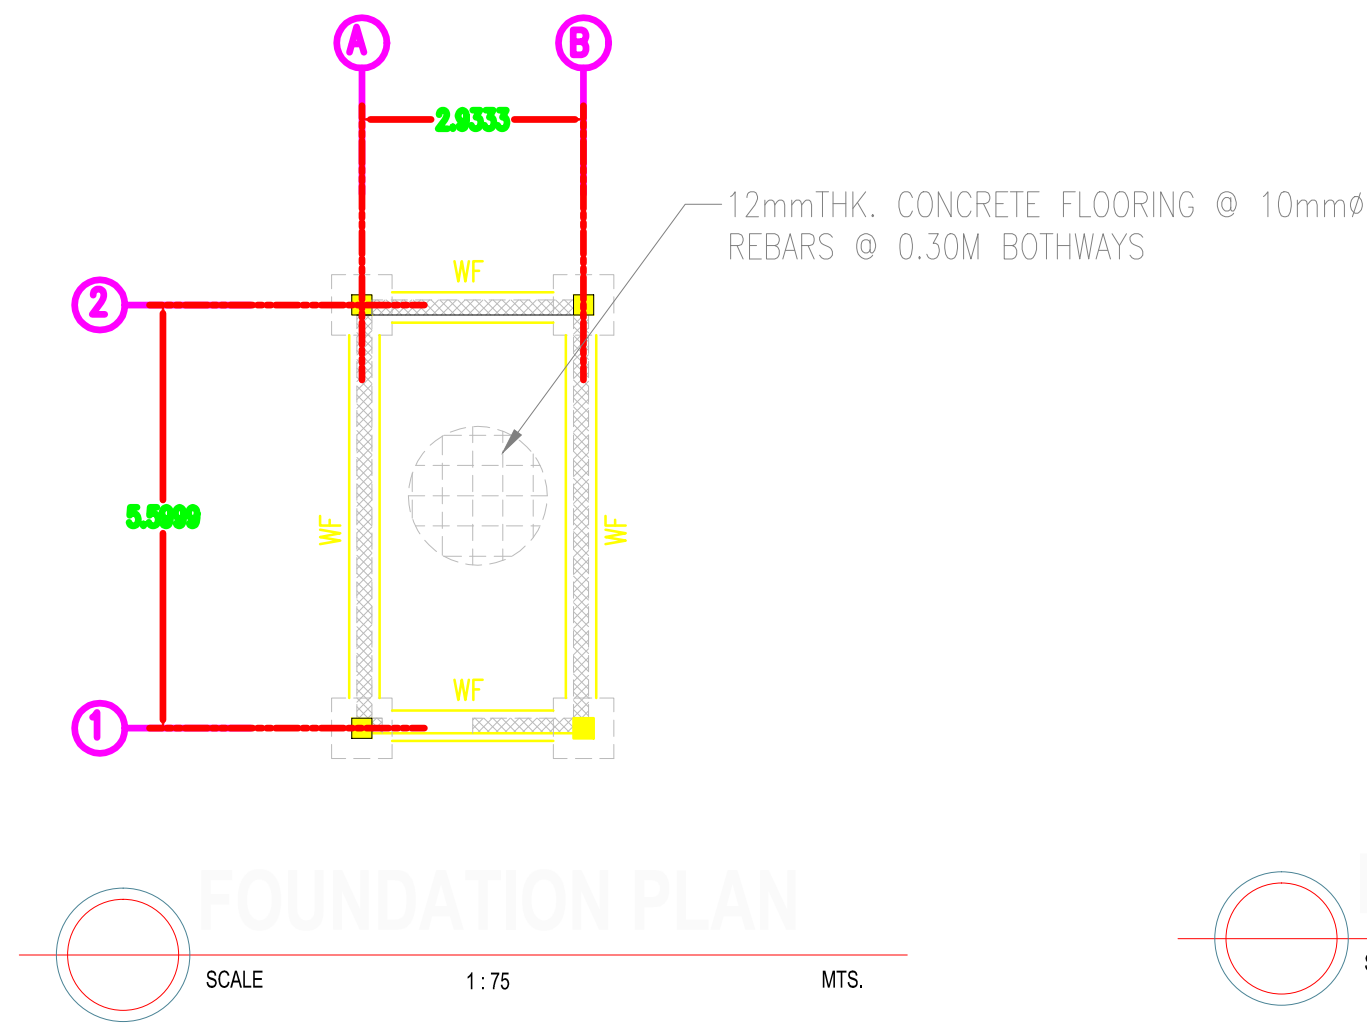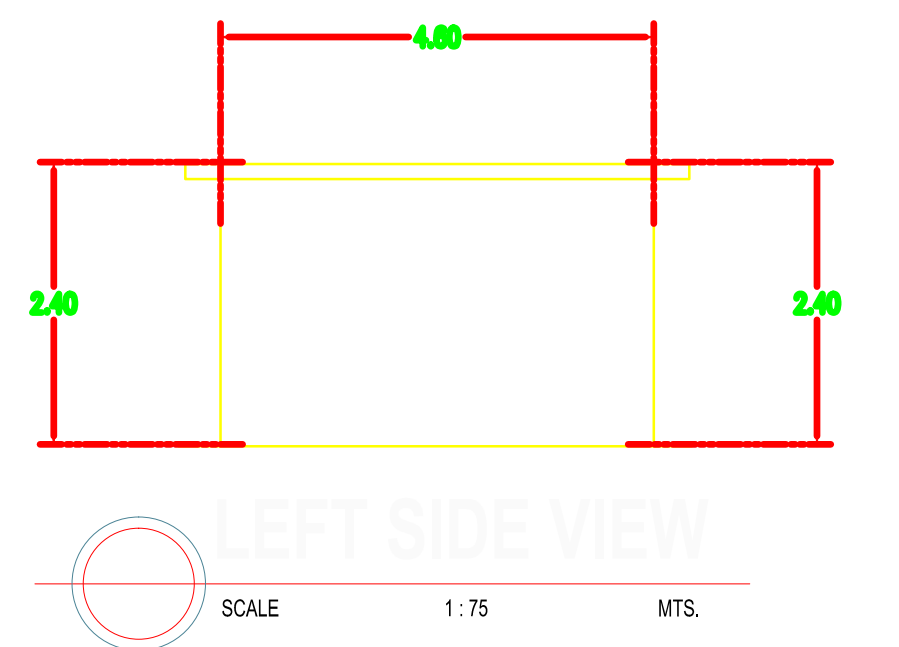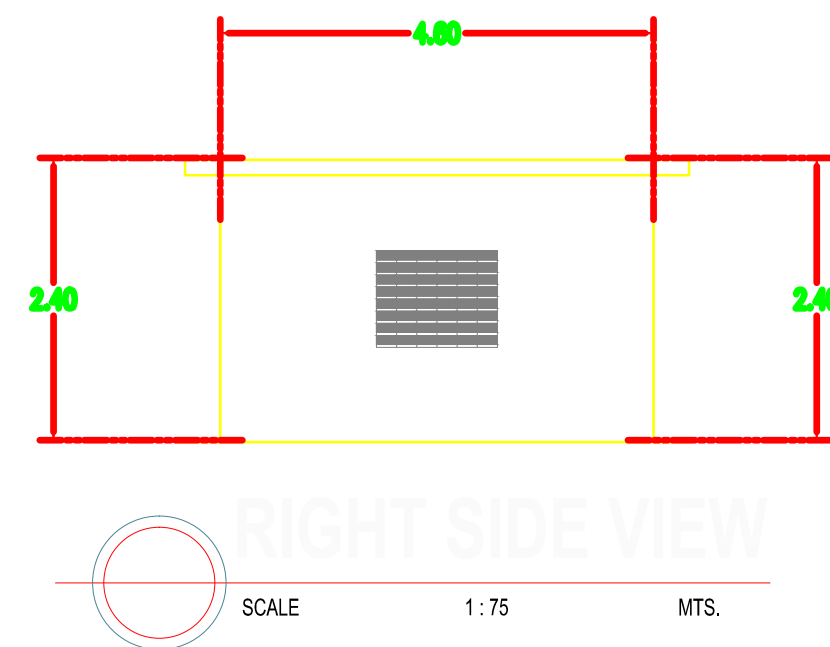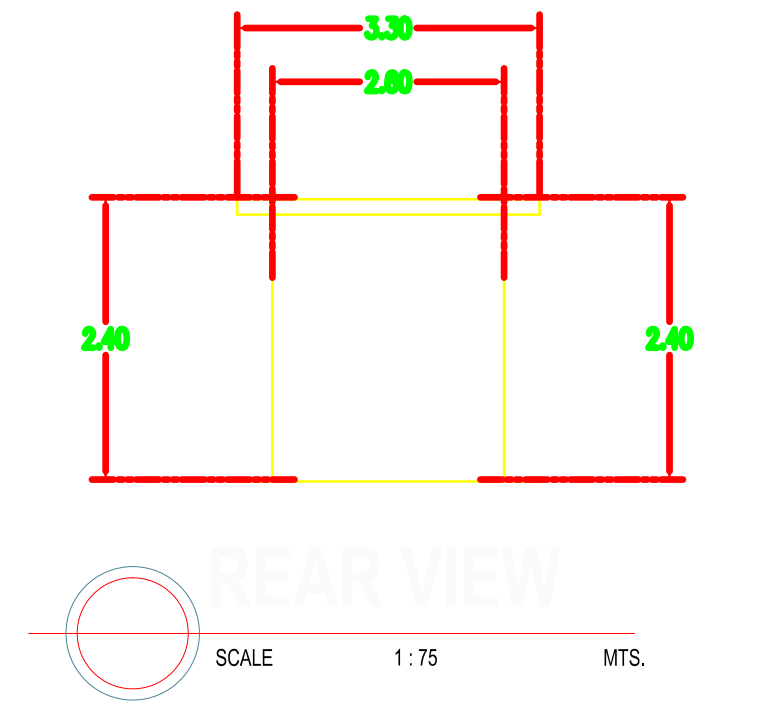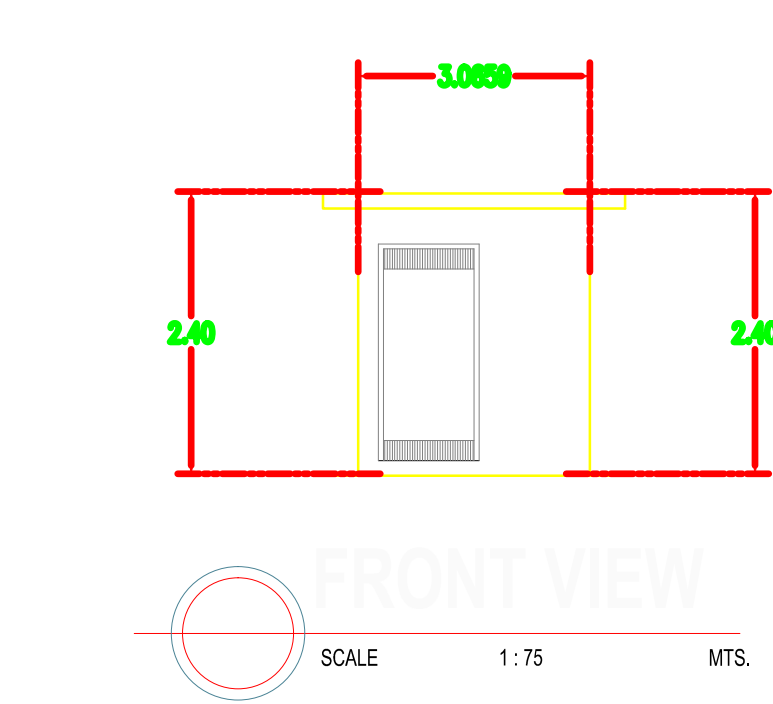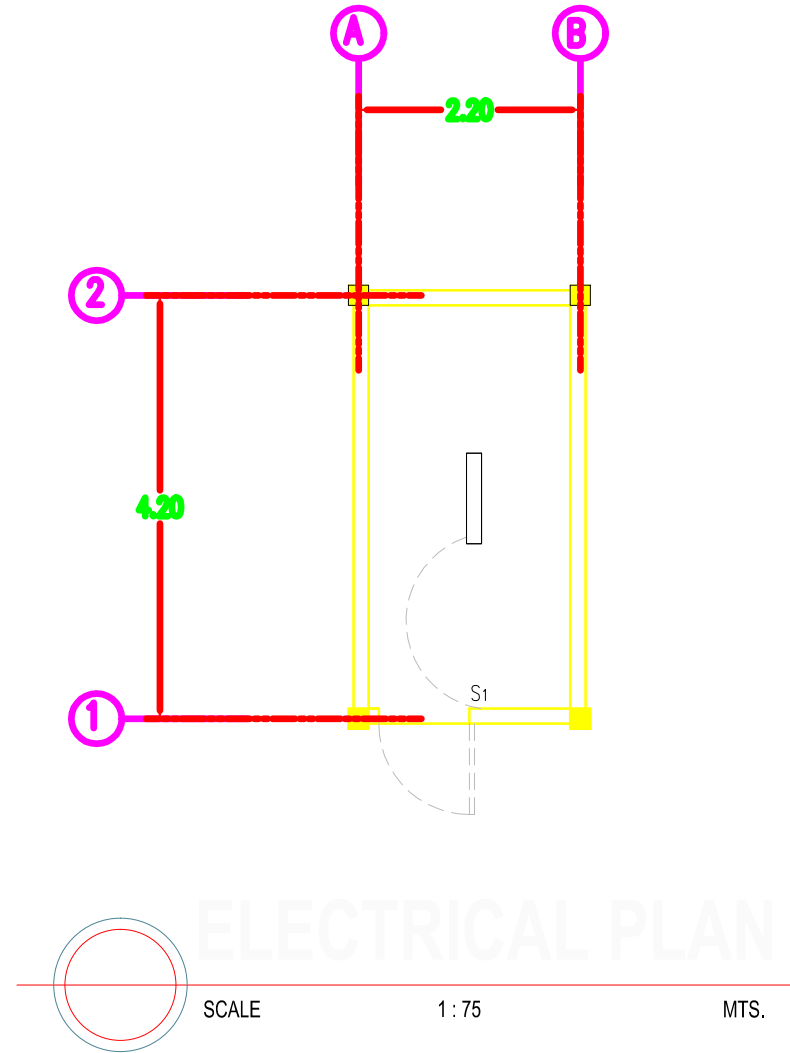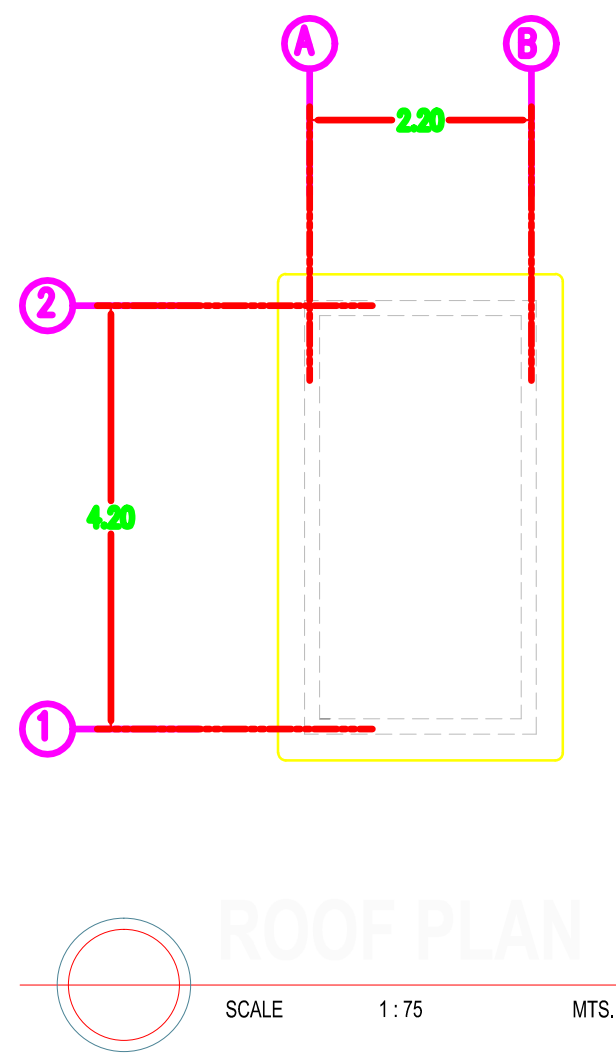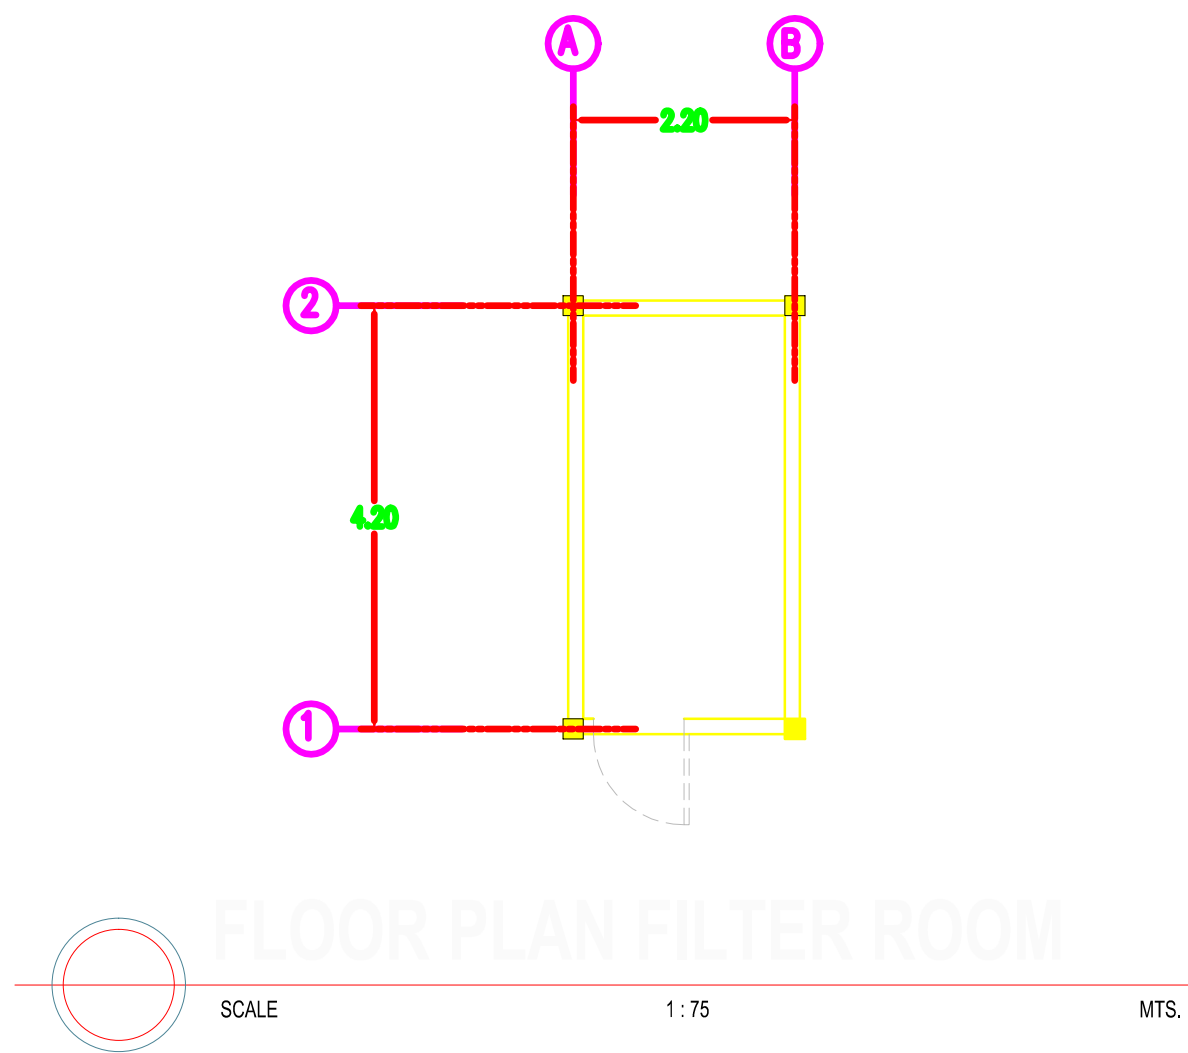

OWNER	PROJECT TITLE :	SUBMITTED BY :	RECOMMENDING APPROVAL :	APPROVED BY :	SHEET CONTENTS :	DESIGN BY :		SHEET NO :
PHILIPPINE SPORTS COMMISSION RMSC, PABLO OCAMPO SR. ST., MALATE, MANILA	UPGRADING OF SWIMMING POOL, DIVING POOL, AND CONSTRUCTION OF NEW BLEACHERS, WARM UP POOL AND JACUZZI LOCATION: PHILSPORTS, ULTRA, MERALCO AVE., PASIG CITY	ENGR. PEDRO I. PINEDA JR. HEAD - ENGINEERING UNIT	DIR. MERLITA R. IBAY DEPUTY EXECUTIVE DIRECTOR	HON. WILLIAM I. RAMIREZ CHAIRMAN	AS SHOWN	DESIGN BY :		A 22
						DRAWN BY :		
						CHECKED BY :		
						DATE :		
						APPROVED BY :		