





PERSPECTIVE





PERSPECTIVE

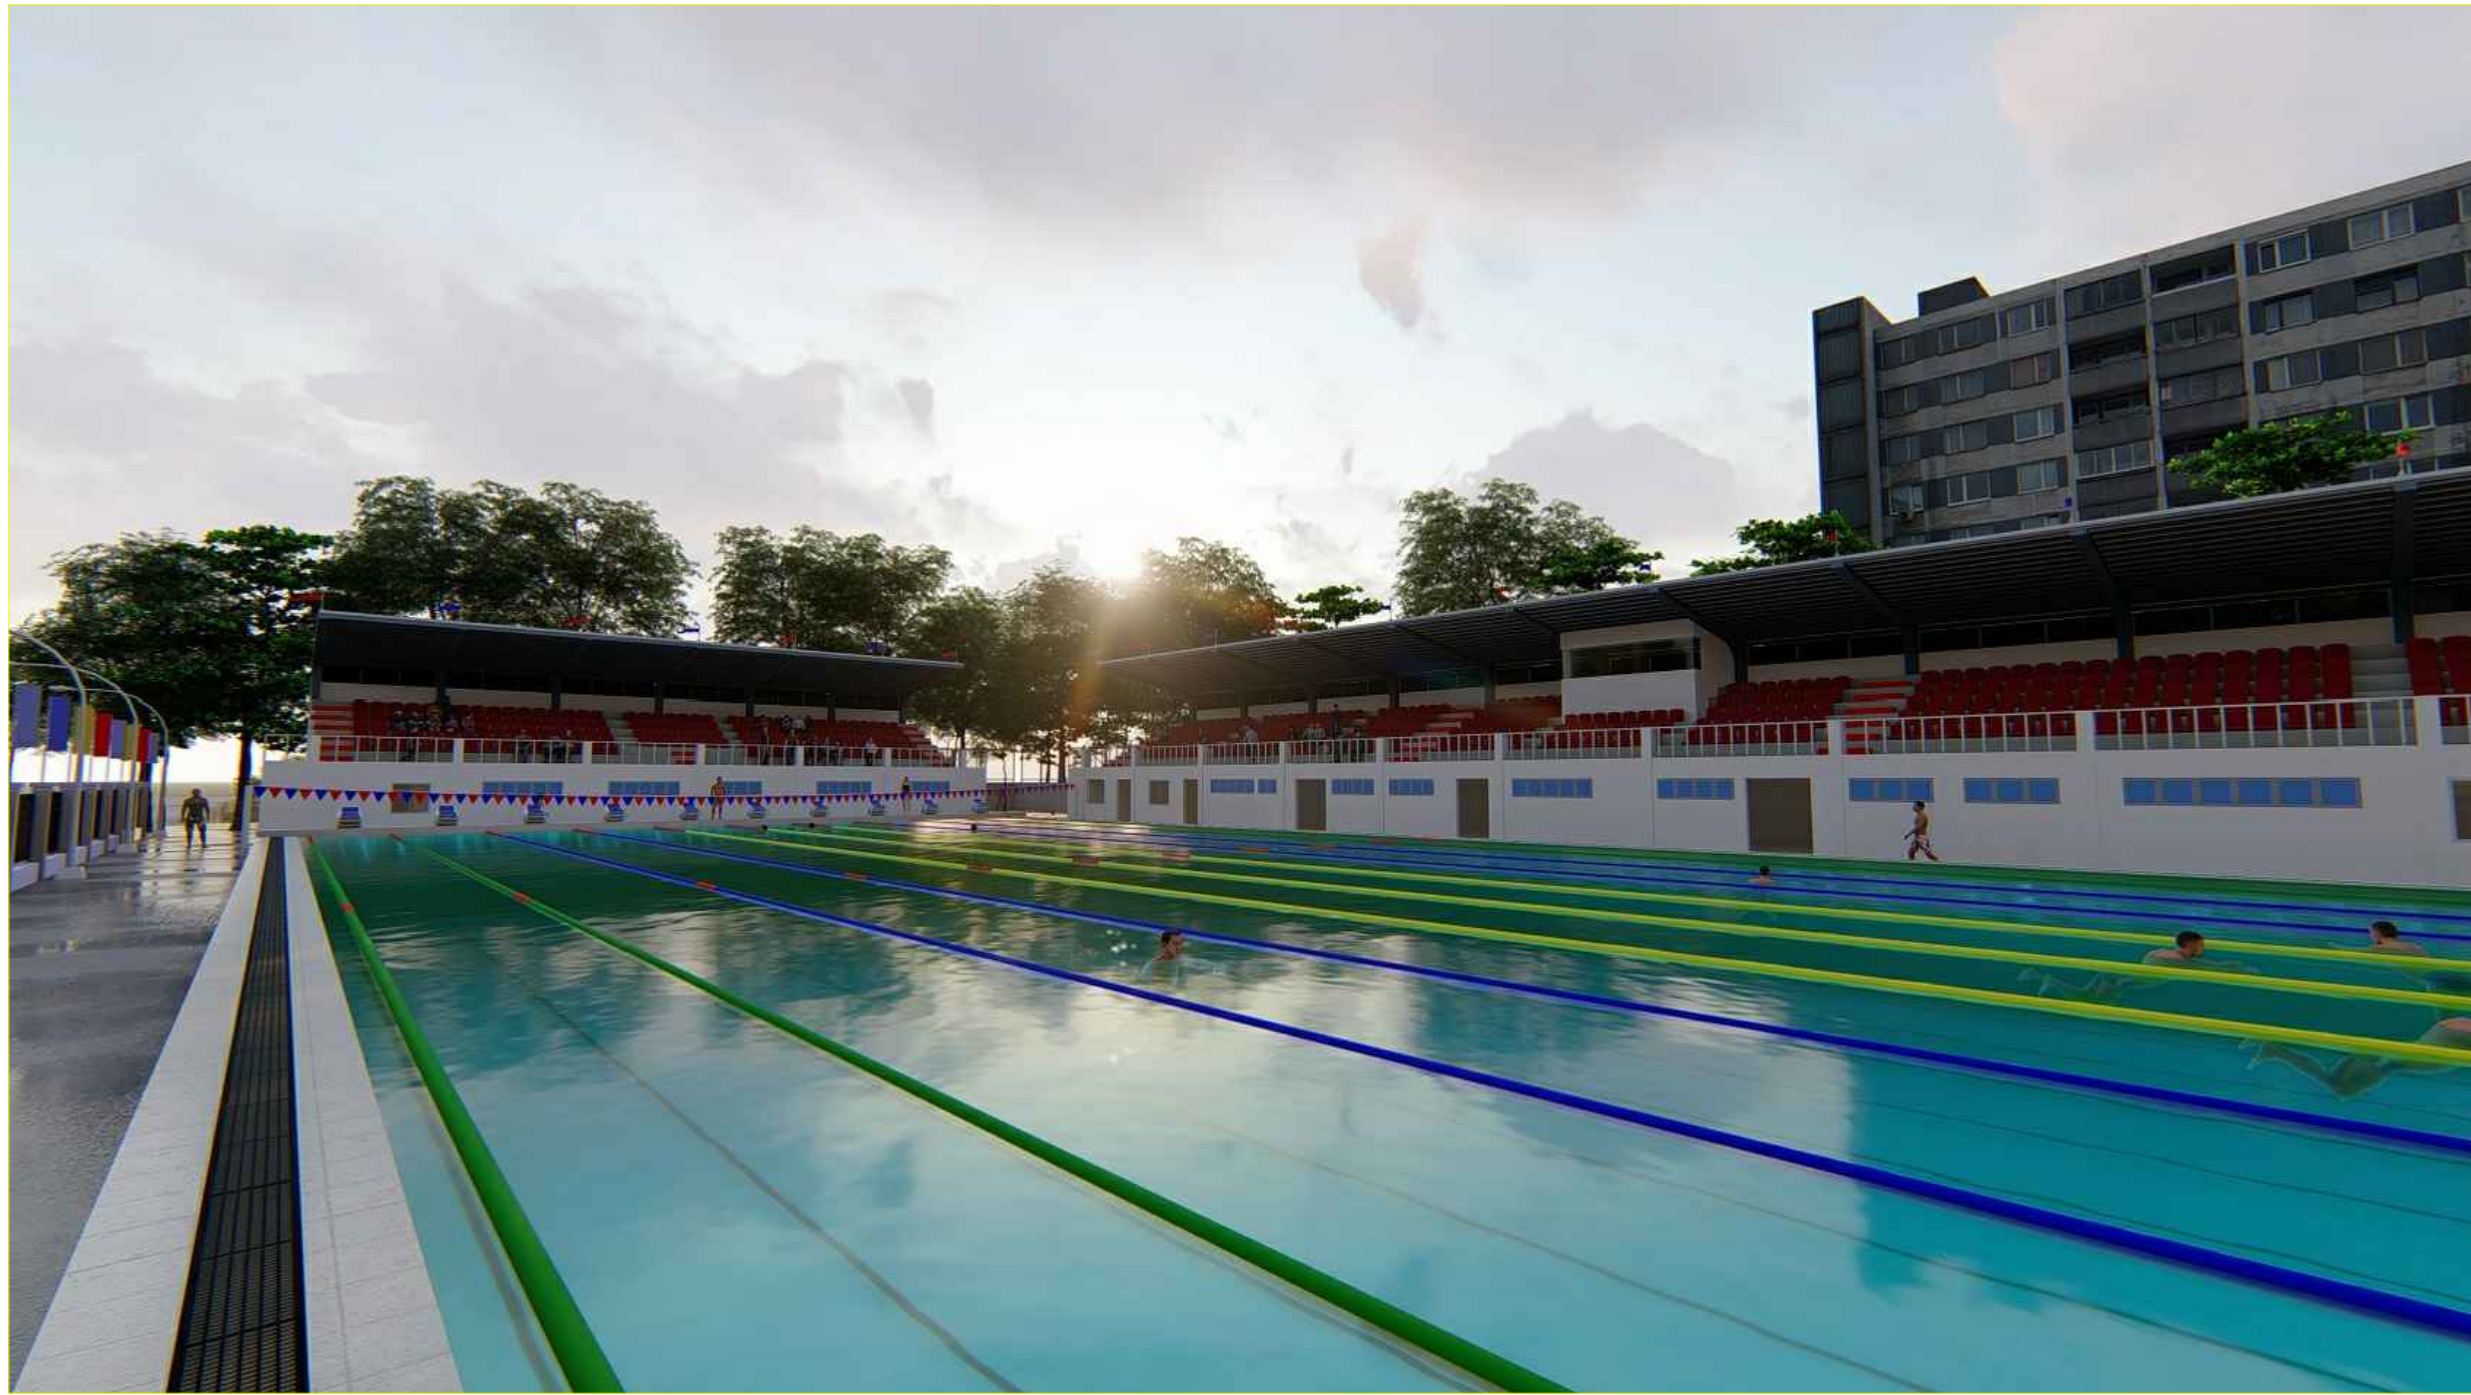

 PERSPECTIVE

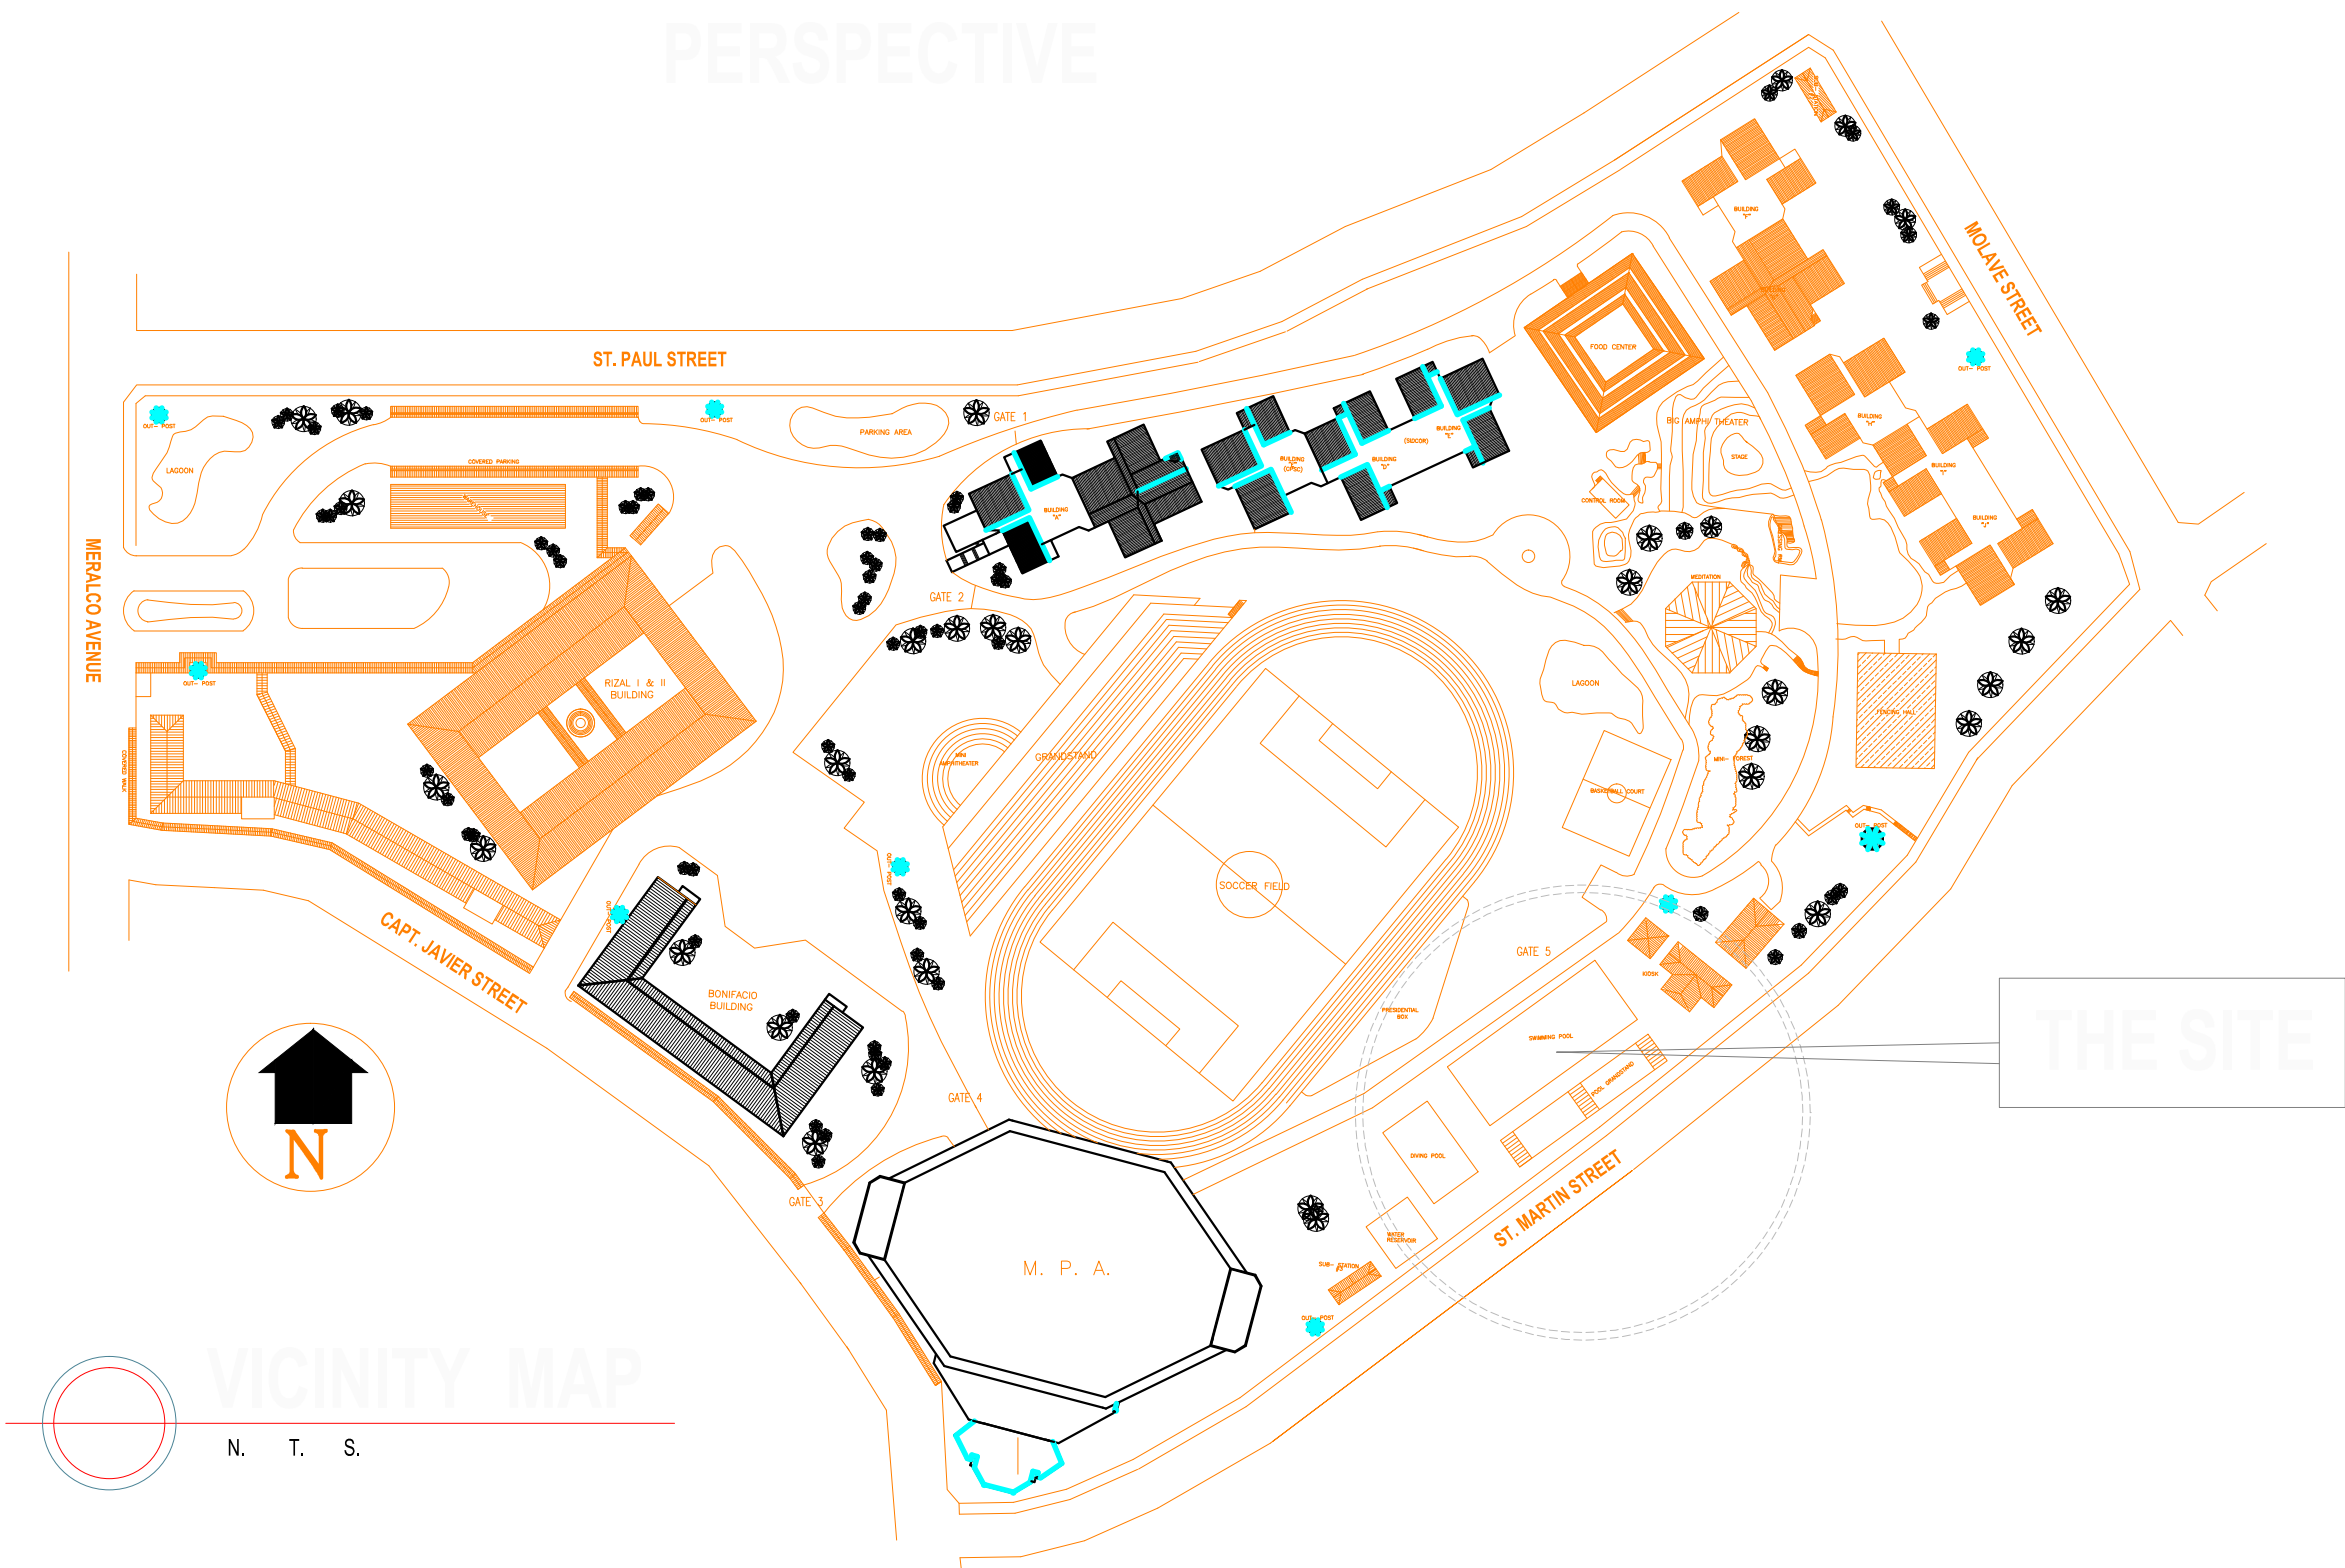


OWNER	PROJECT TITLE :	SUBMITTED BY :	RECOMMENDING APPROVAL :	APPROVED BY :	SHEET CONTENTS :	DESIGN BY :		SHEET NO :
 PHILIPPINE SPORTS COMMISSION RMSC, PABLO OCAMPO SR. ST., MALATE, MANILA	UPGRADING OF SWIMMING POOL, DIVING POOL, AND CONSTRUCTION OF NEW BLEACHERS, WARM UP POOL AND JACUZZI LOCATION: PHILSPORTS, ULTRA, MERALCO AVE., PASIG CITY	ENGR. PEDRO I. PINEDA JR. HEAD - ENGINEERING UNIT	DIR. MERLITA R. IBAY DEPUTY EXECUTIVE DIRECTOR	HON. WILLIAM I. RAMIREZ CHAIRMAN	AS SHOWN	DESIGN BY :		A 1
						DRAWN BY :		
						CHECKED BY :		
						DATE :		
						APPROVED BY :		

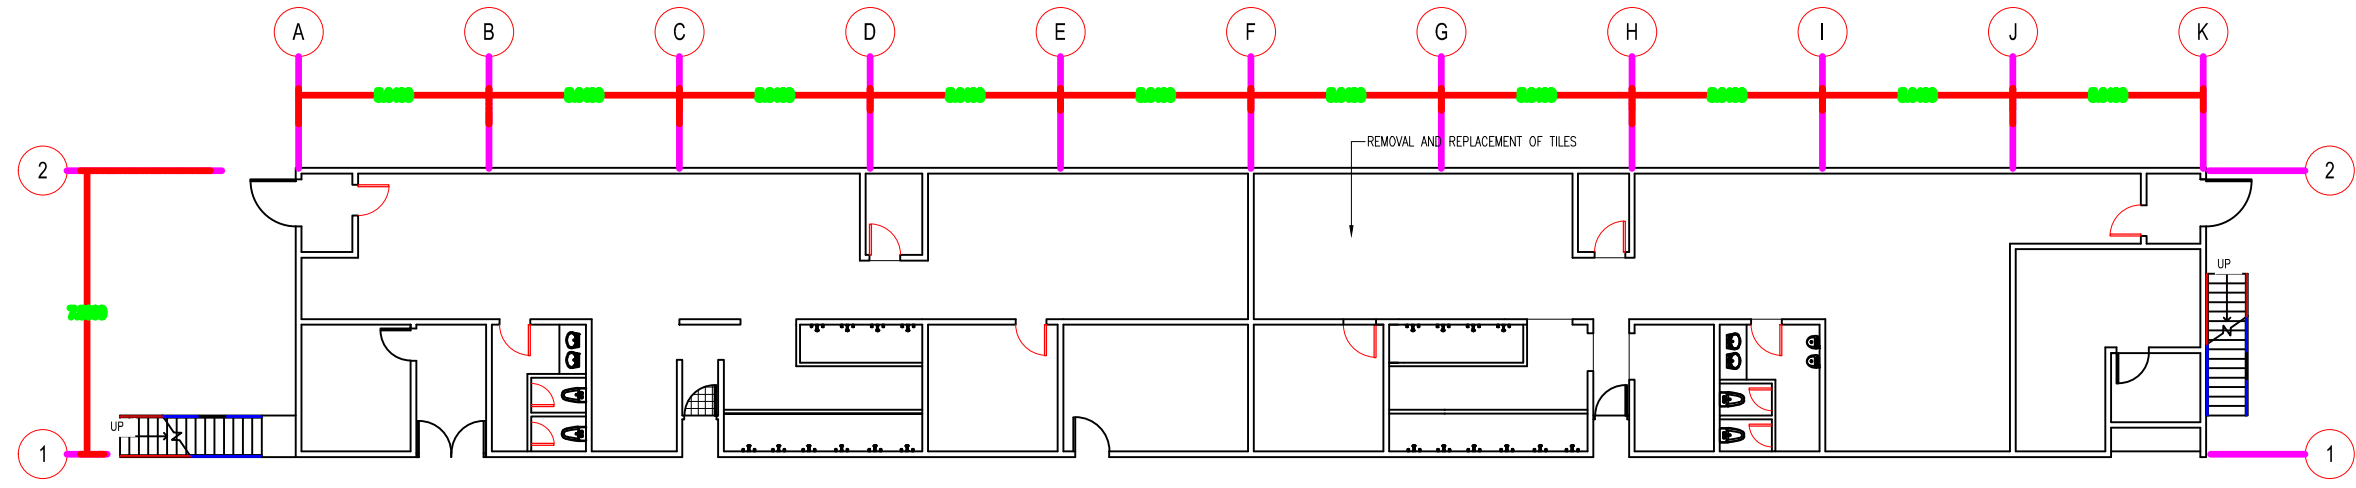

EXISTING GROUND FLOOR PLAN


SCALE 1 : 100 MTS.

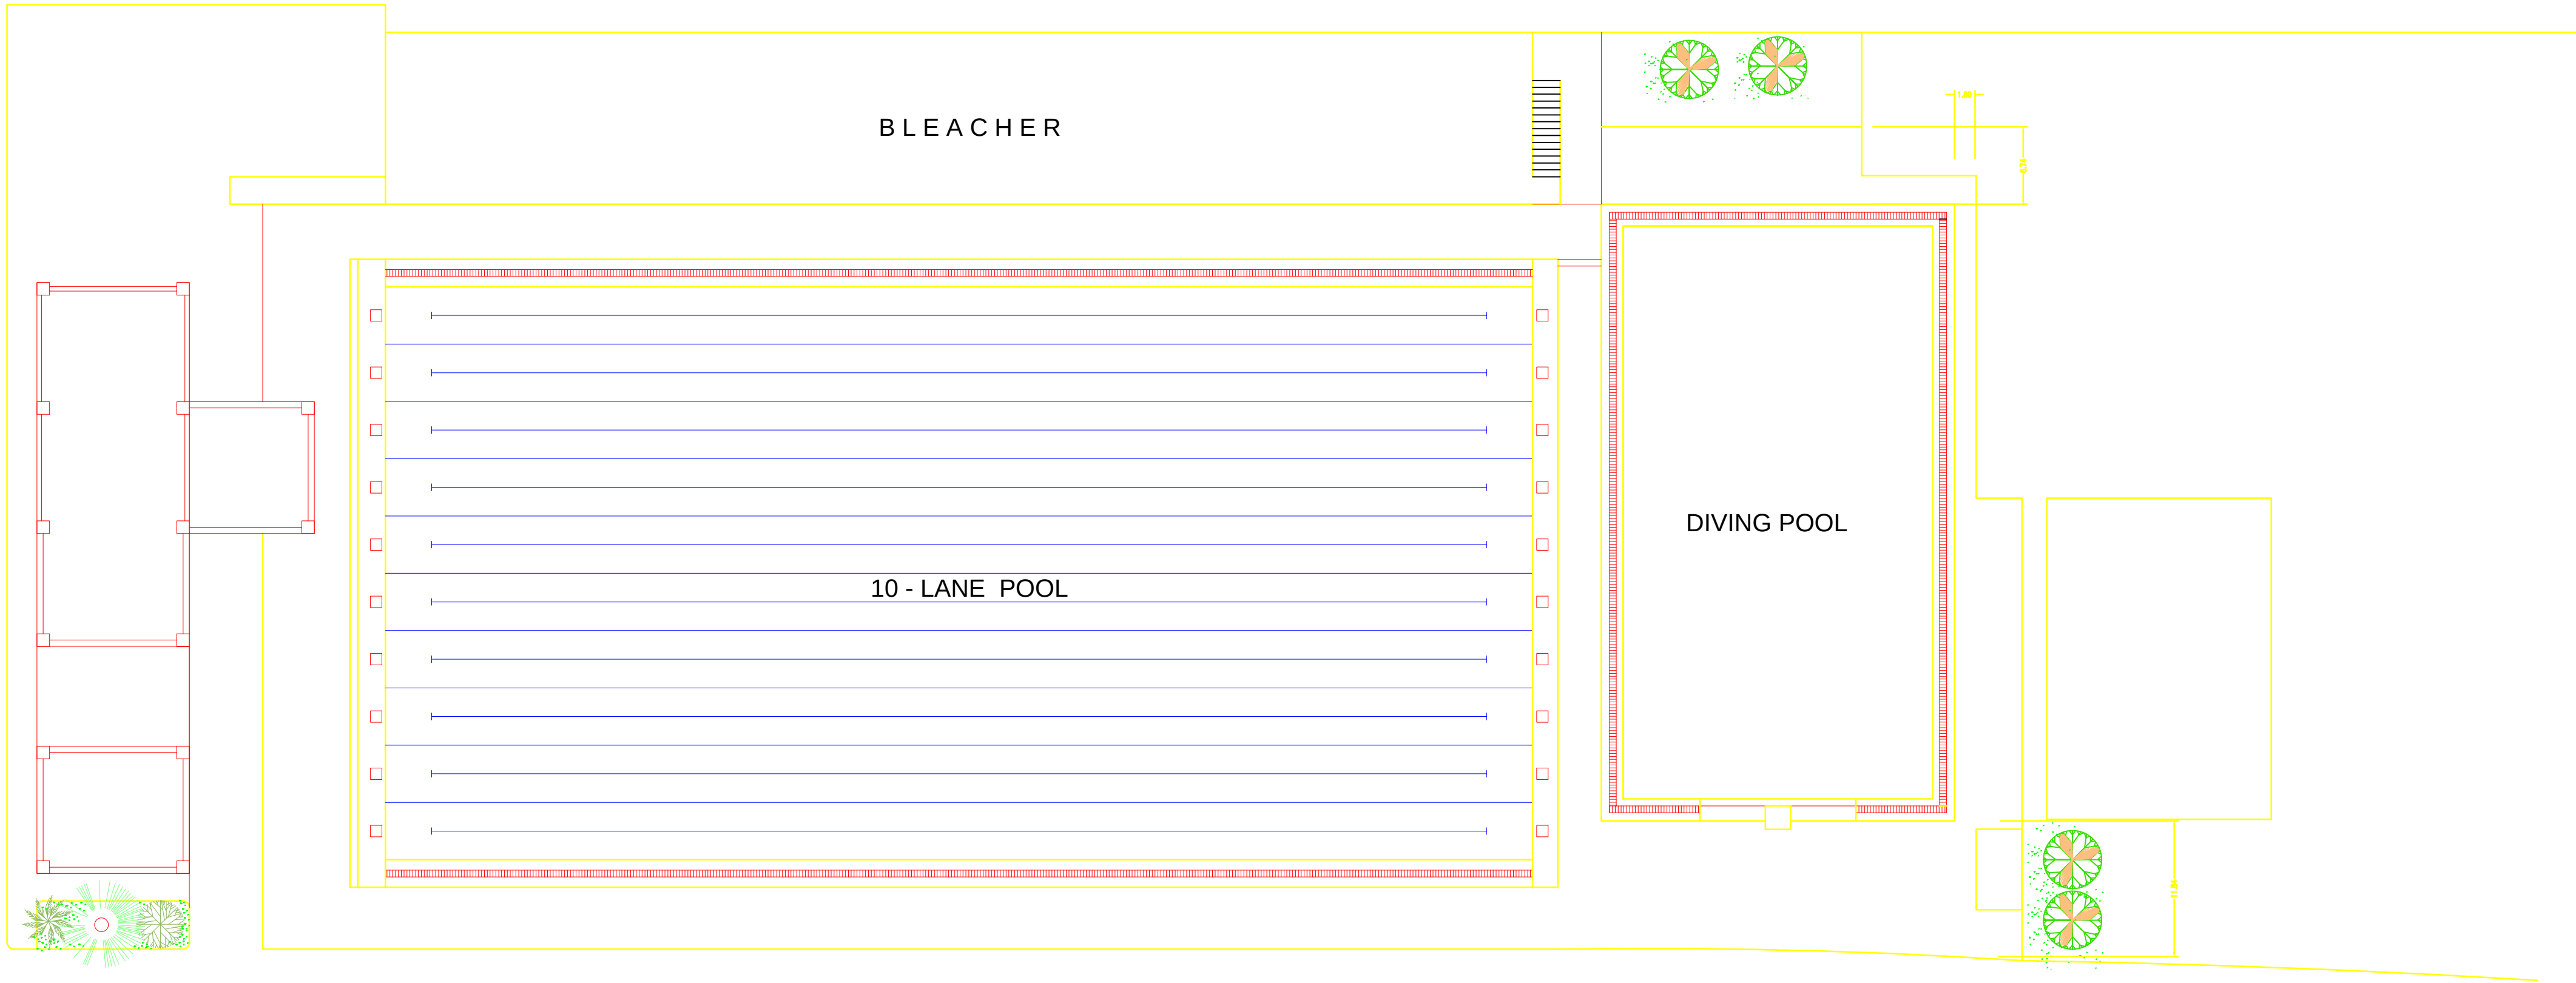



EXISTING BLEACHERS FLOOR PLAN

SCALE 1 : 100 MTS.

OWNER	PROJECT TITLE :	SUBMITTED BY :	RECOMMENDING APPROVAL :	APPROVED BY :	SHEET CONTENTS :	DESIGN BY :		SHEET NO :
 PHILIPPINE SPORTS COMMISSION RMSG, PABLO OCAMPO SR. ST., MALATE, MANILA	UPGRADING OF SWIMMING POOL, DIVING POOL, AND CONSTRUCTION OF NEW BLEACHERS, WARM UP POOL AND JACUZZI LOCATION: PHILSPORTS, ULTRA, MERALCO AVE., PASIG CITY	ENGR. PEDRO I. PINEDA JR. HEAD - ENGINEERING UNIT	DIR. MERLITA R. IBAY DEPUTY EXECUTIVE DIRECTOR	HON. WILLIAM I. RAMIREZ CHAIRMAN	AS SHOWN	DRAWN BY :		A 2
						CHECKED BY :		
						DATE :		
						APPROVED BY :		

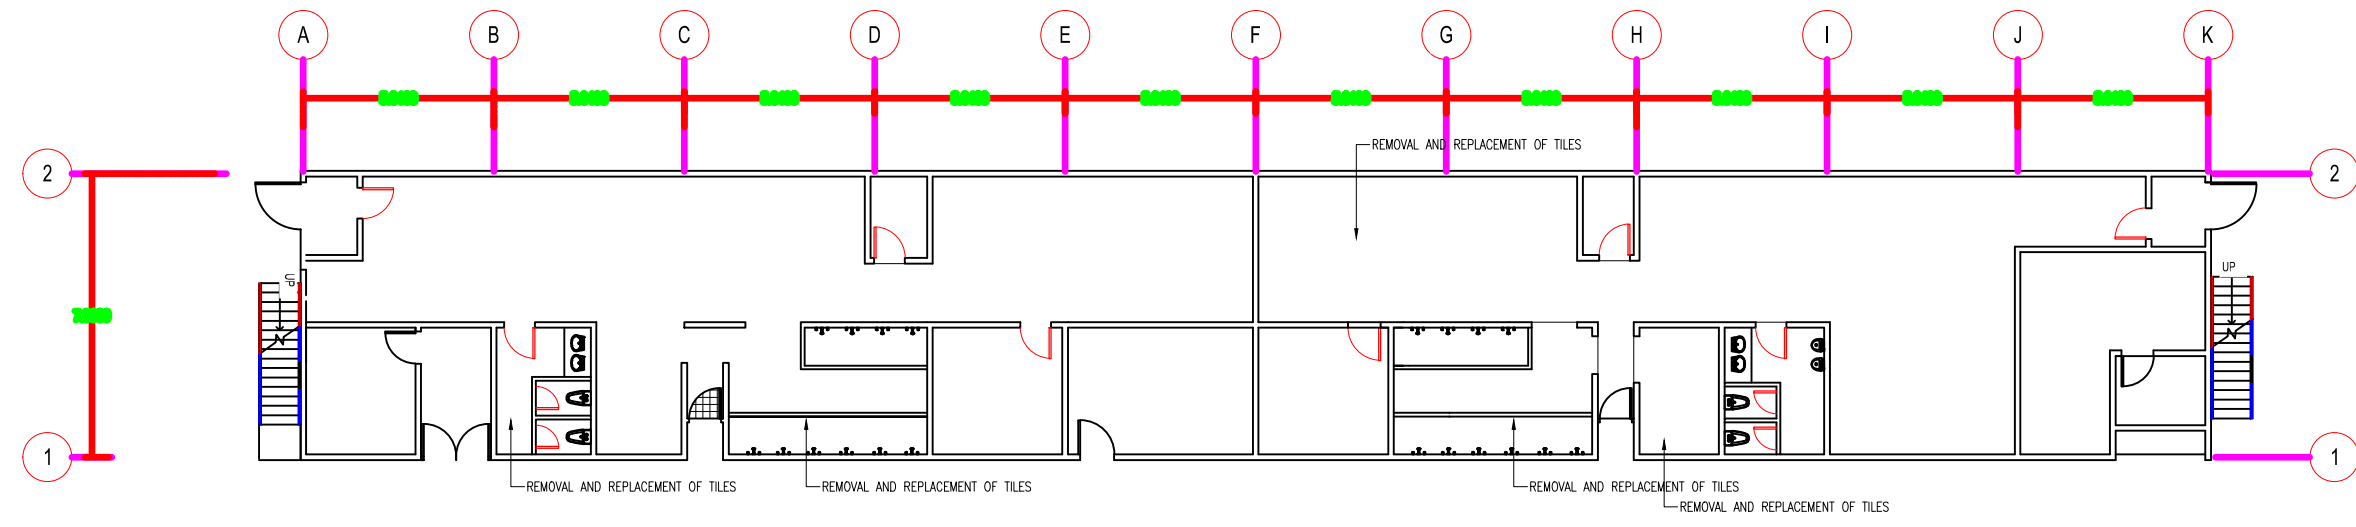


PROPOSED GROUND FLOOR PLAN
SCALE 1:100 MTS.

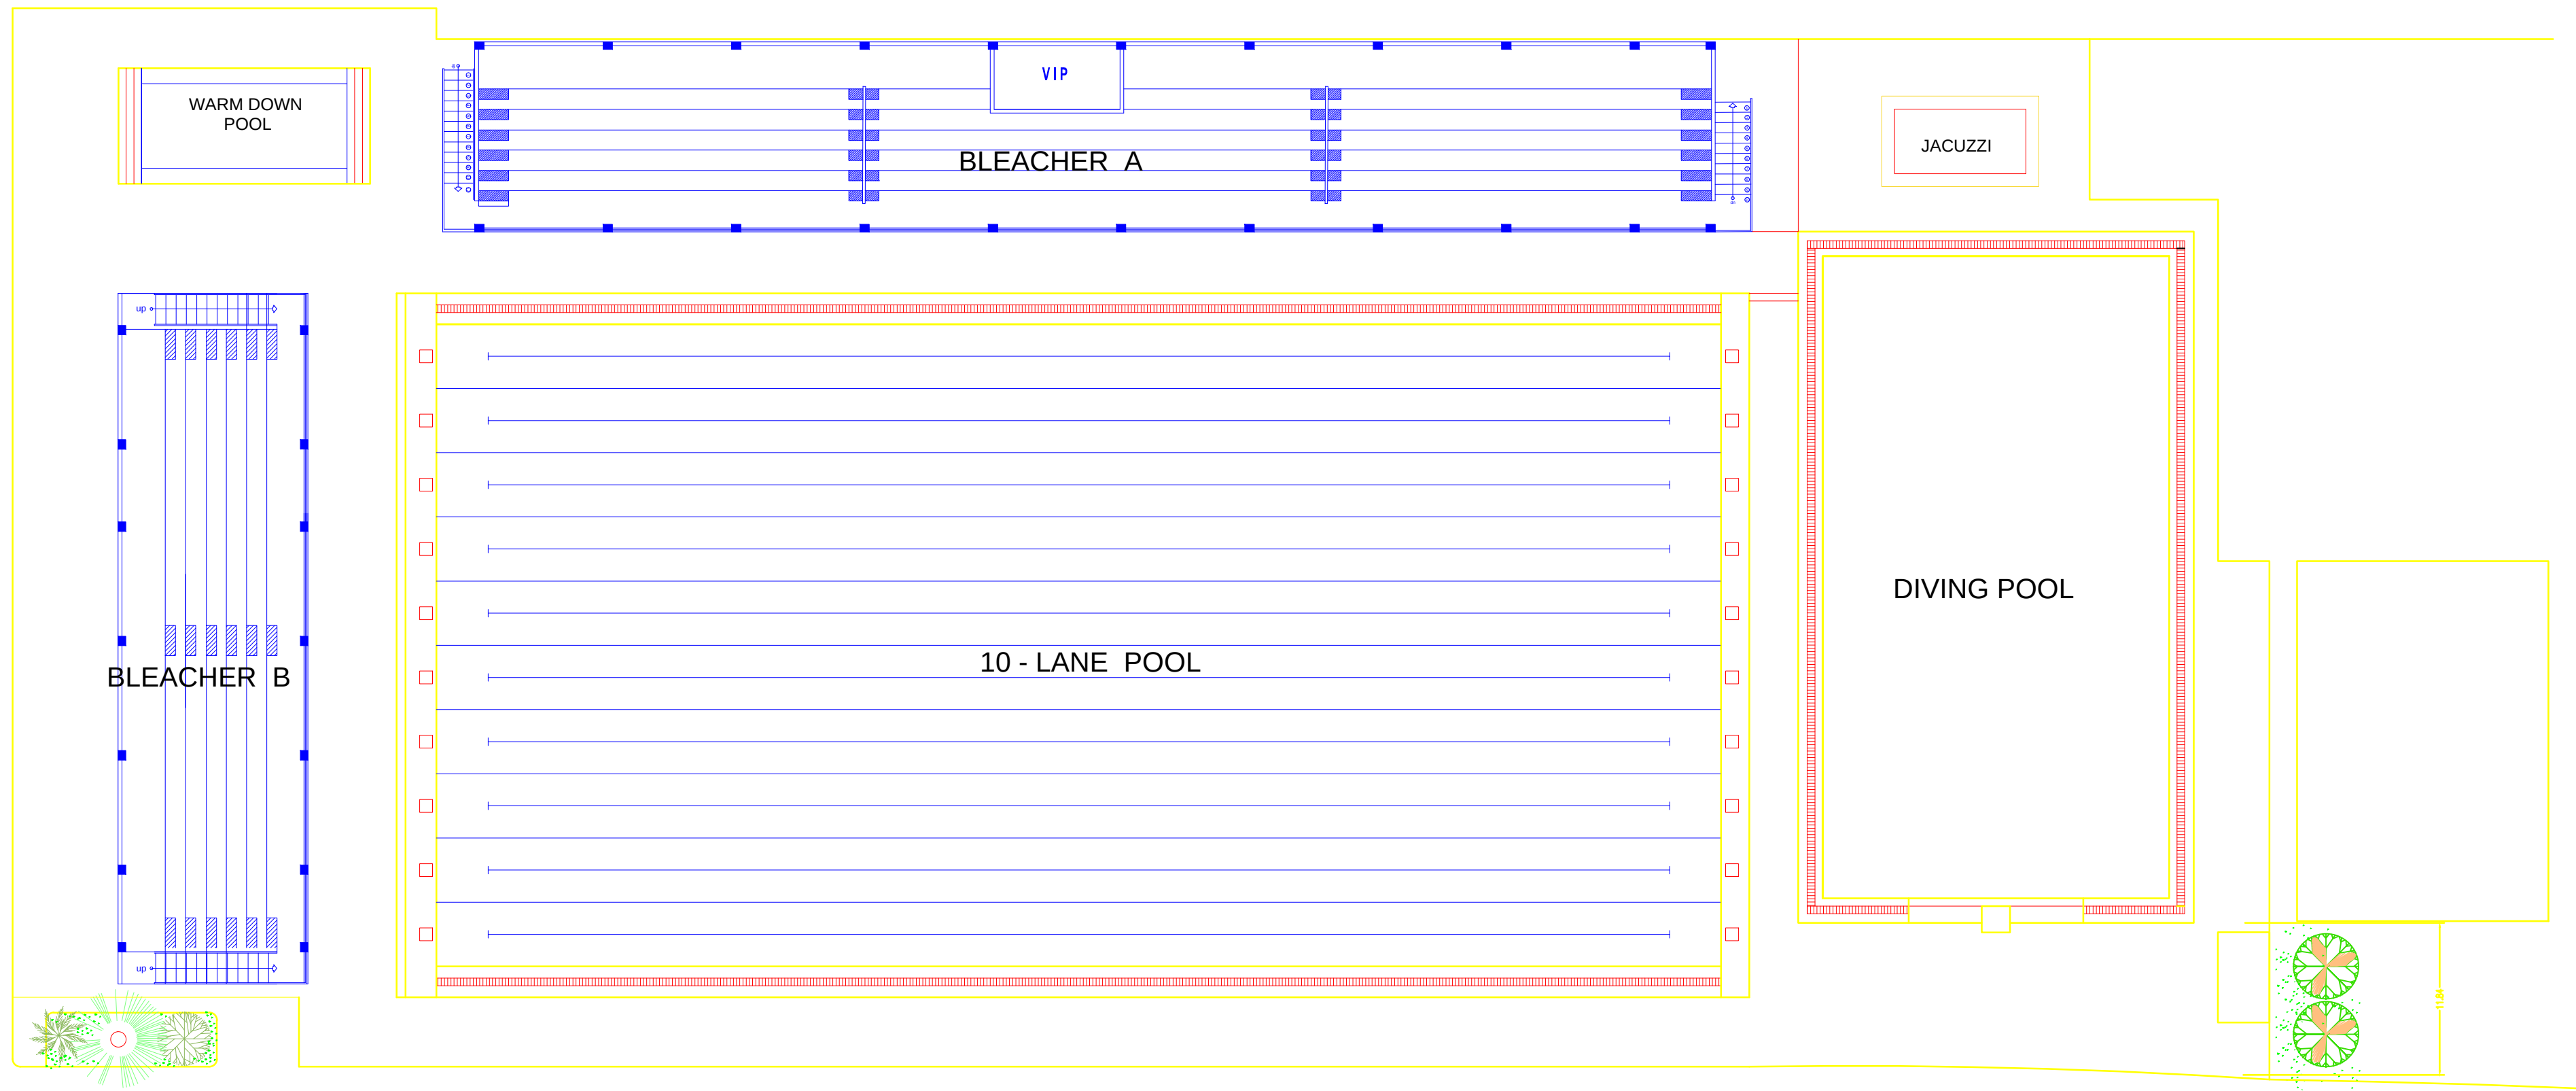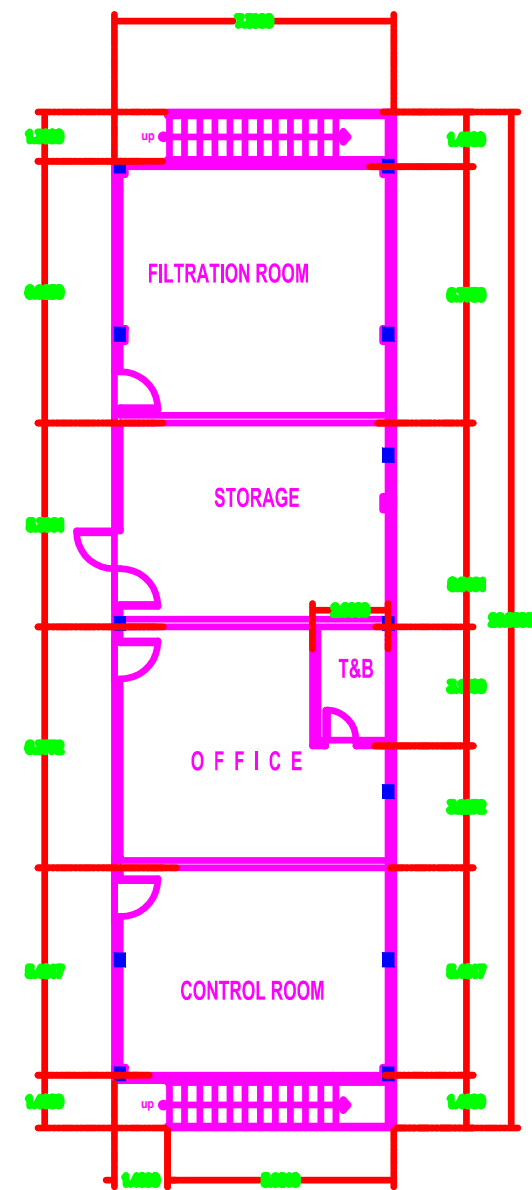


PROPOSED BLEACHERS FLOOR PLAN
SCALE 1:100 MTS.

PROPOSED GROUND FLOOR PLAN
SCALE 1:100 MTS.


OWNER	PROJECT TITLE :	SUBMITTED BY :	RECOMMENDING APPROVAL :	APPROVED BY :	SHEET CONTENTS :	DESIGN BY :		SHEET NO :
PHILIPPINE SPORTS COMMISSION RMSC, PABLO OCAMPO SR. ST., MALATE, MANILA	UPGRADING OF SWIMMING POOL, DIVING POOL, AND CONSTRUCTION OF NEW BLEACHERS, WARM UP POOL AND JACUZZI LOCATION: PHILSPORTS, ULTRA, MERALCO AVE., PASIG CITY	ENGR. PEDRO I. PINEDA JR. HEAD - ENGINEERING UNIT	DIR. MERLITA R. IBAY DEPUTY EXECUTIVE DIRECTOR	HON. WILLIAM I. RAMIREZ CHAIRMAN	AS SHOWN	DRAWN BY :		A 3
						CHECKED BY :		
						DATE :		
						APPROVED BY :		

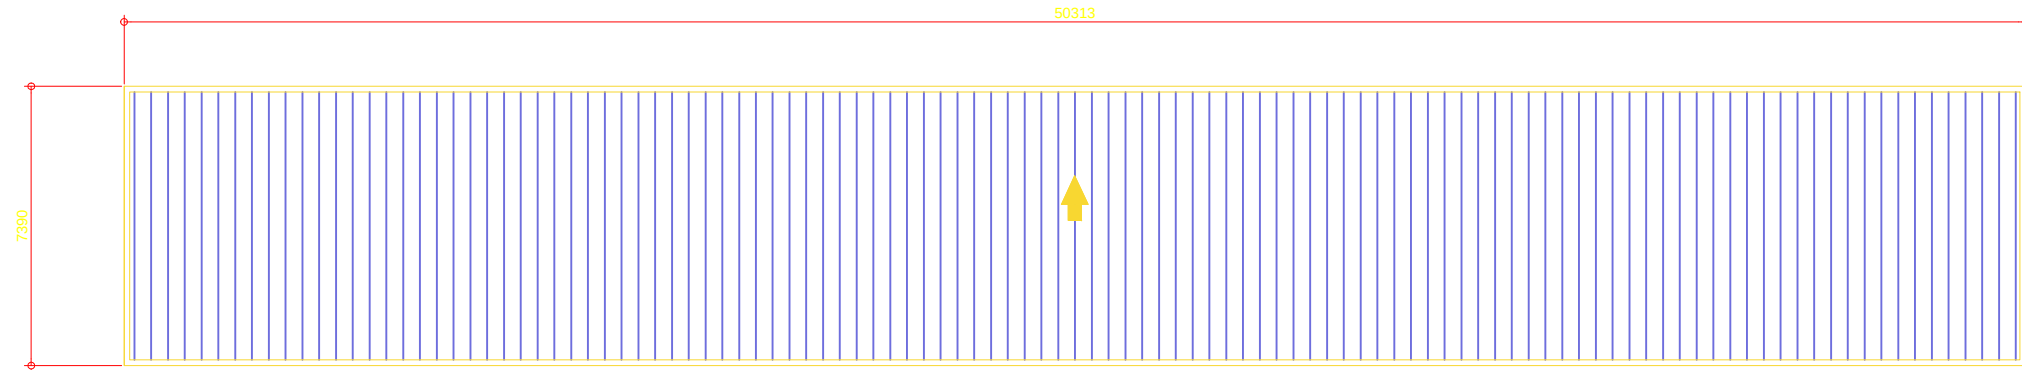


ROOF PLAN
SCALE 1:100 MTS.

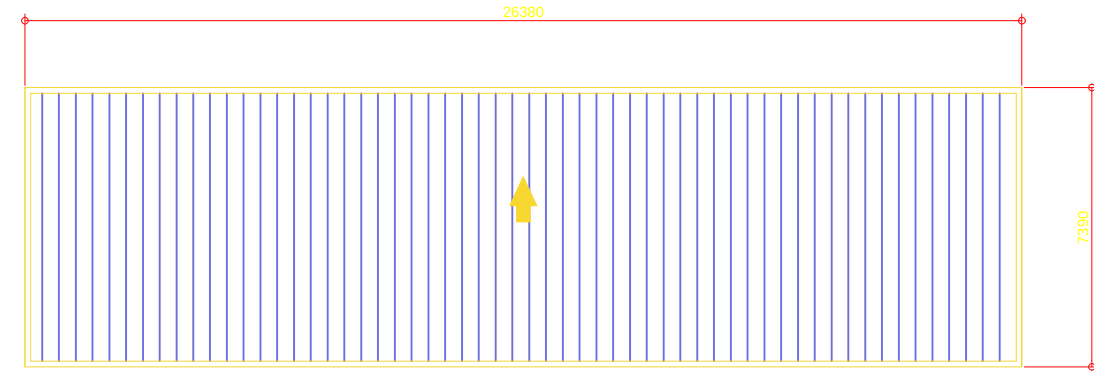


PROPOSED BLEACHER B
ROOF PLAN
SCALE 1:100 MTS.

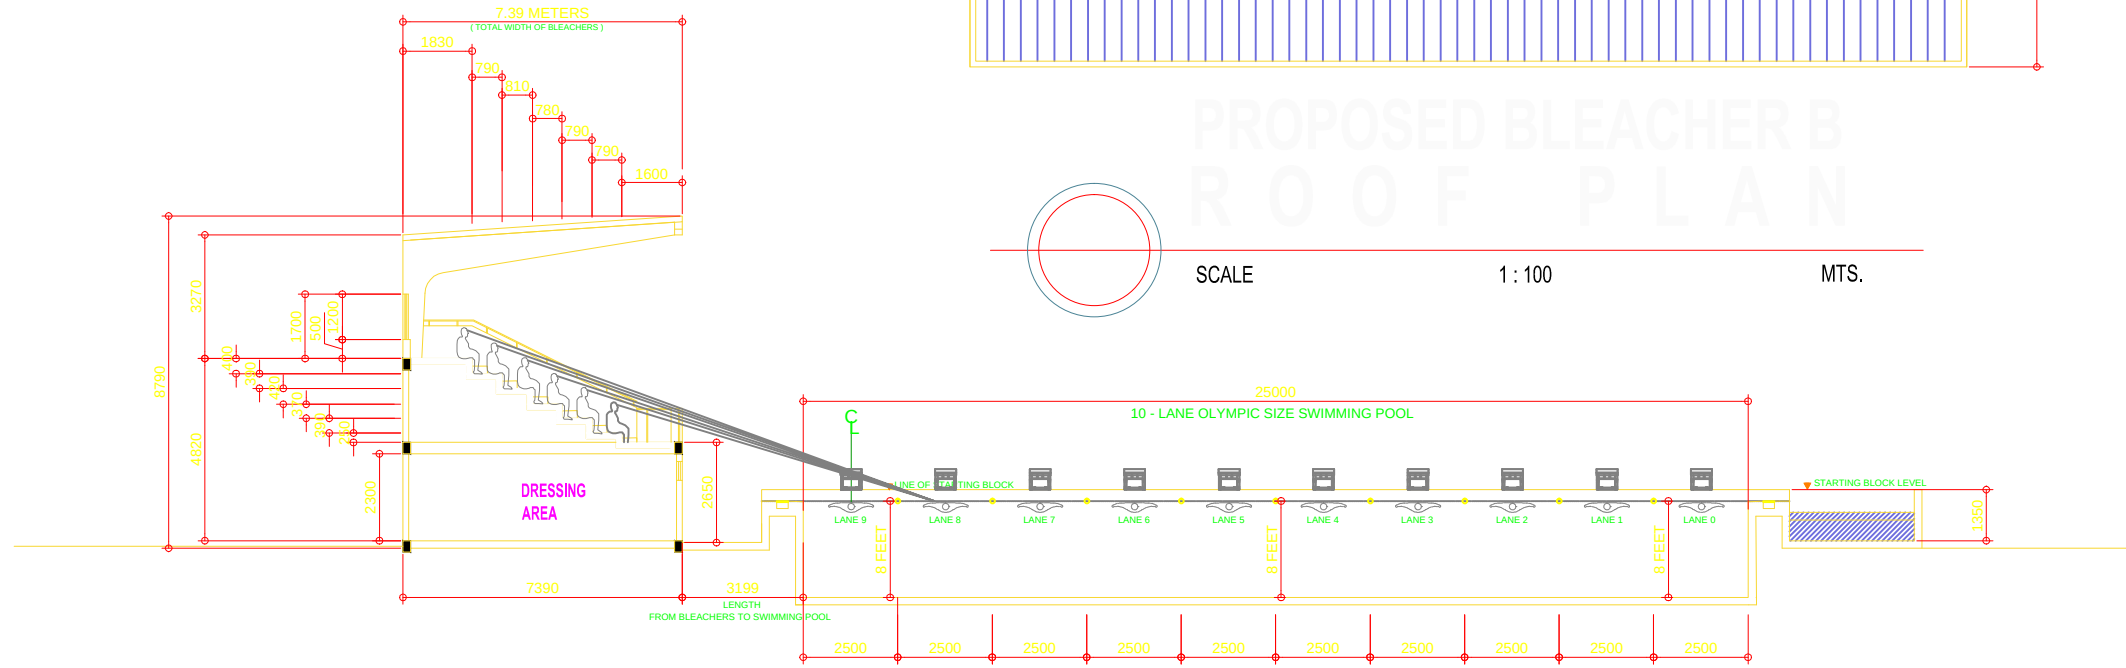


PROPOSED CROSS SECTION OF AQUATIC CENTER
SCALE 1:100 MTS.

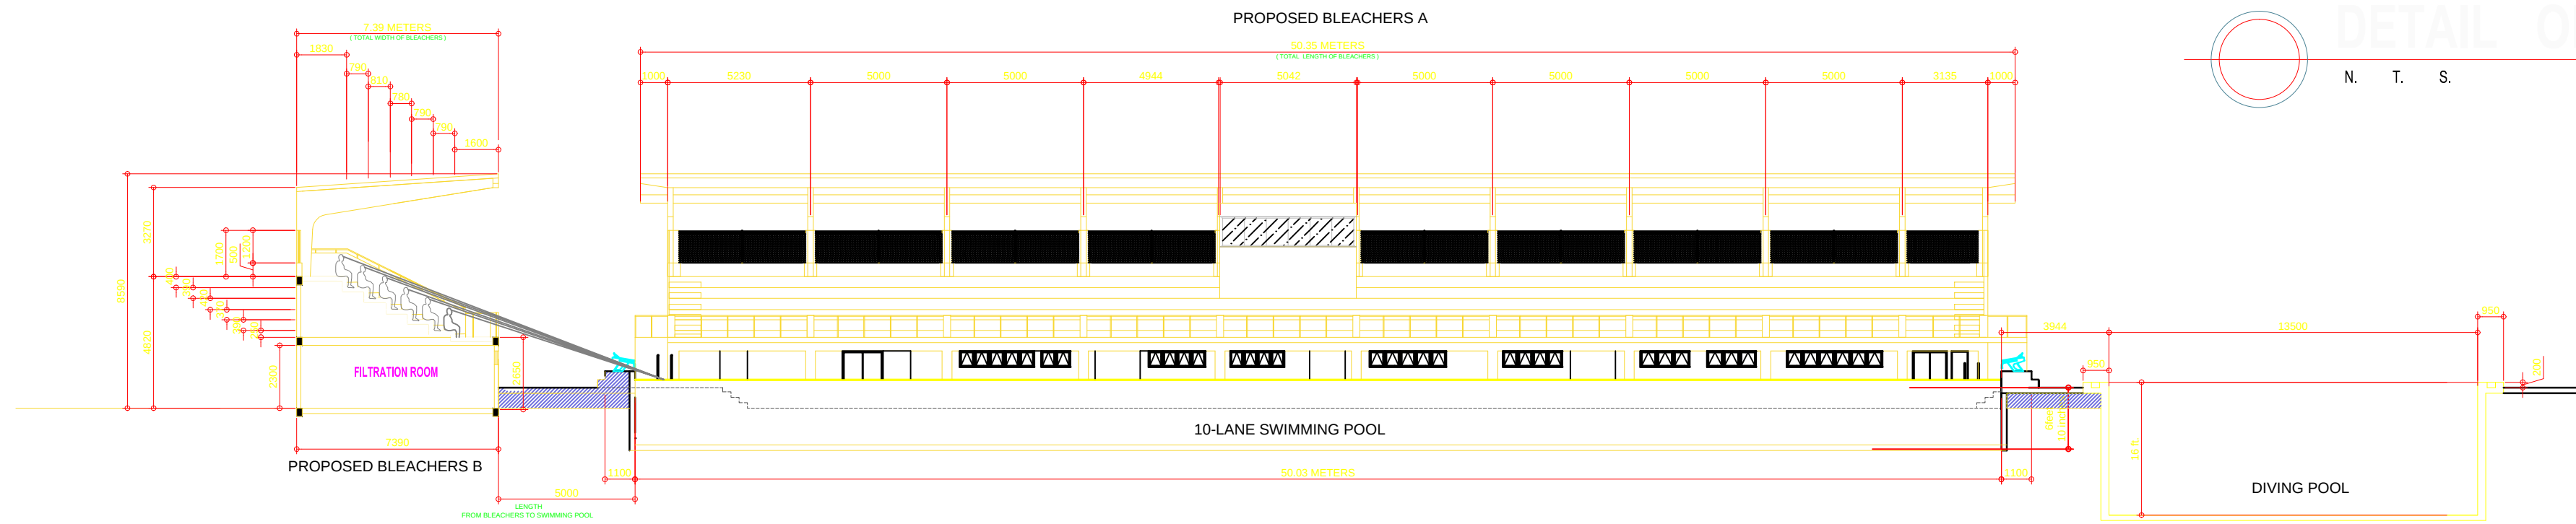


PROPOSED LONGITUDINAL SECTION OF AQUATIC CENTER
SCALE 1:100 MTS.

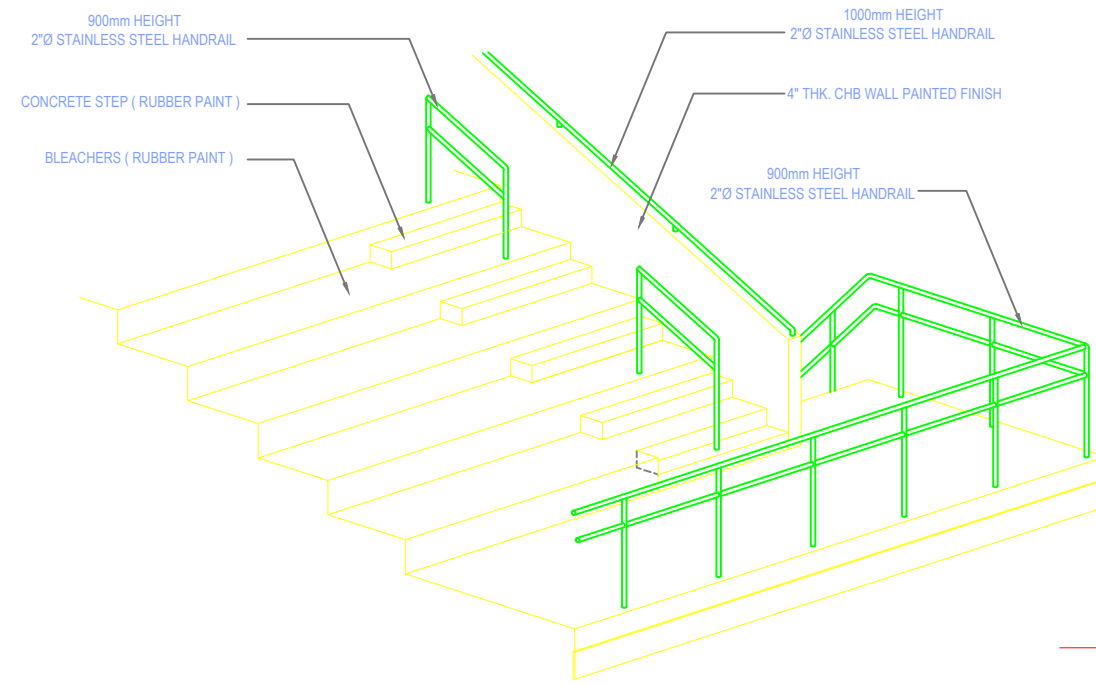


ISOMETRIC VIEW OF BLEACHERS
N. T. S.

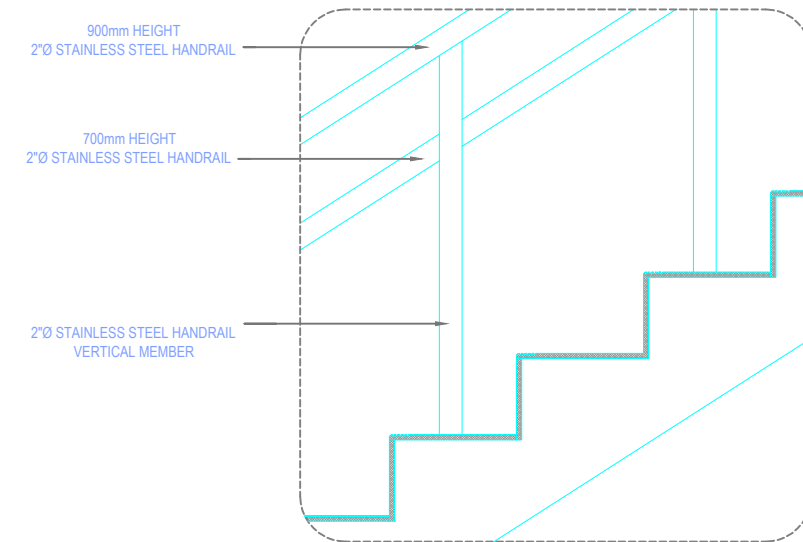

DETAIL OF RAILING
N. T. S.

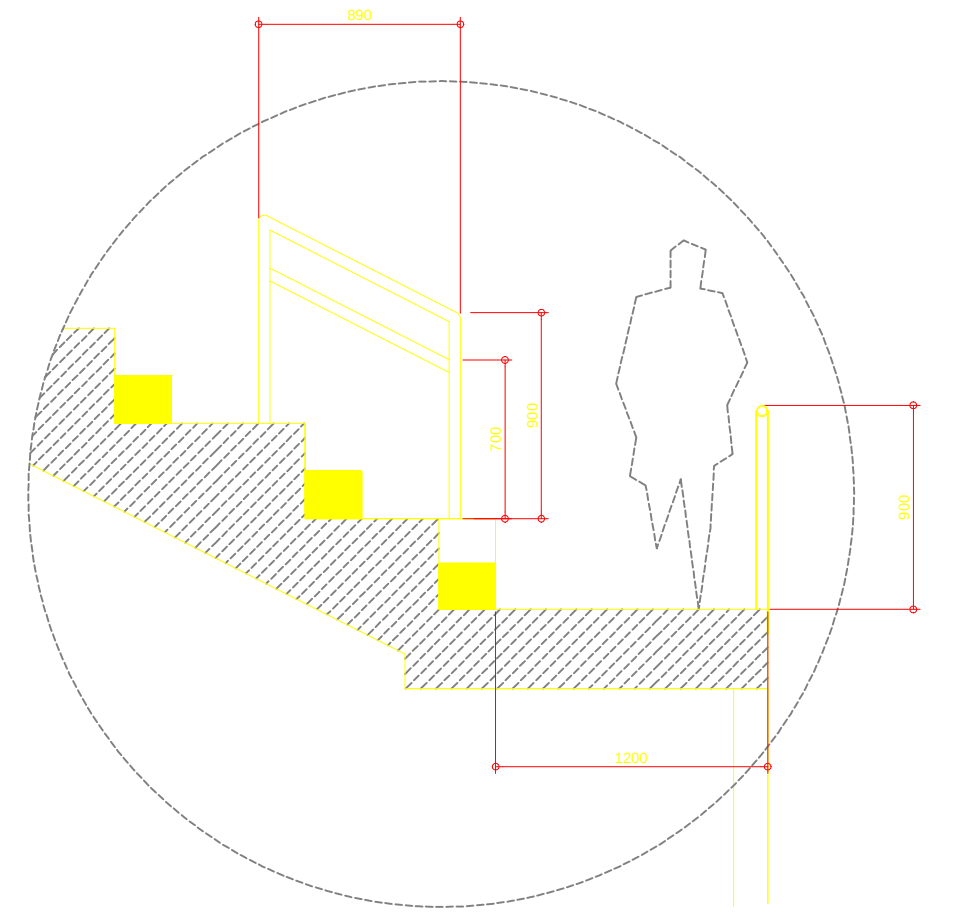



DETAIL OF RAILING @ BLEACHERS STEP
SCALE 1:15 MTS.

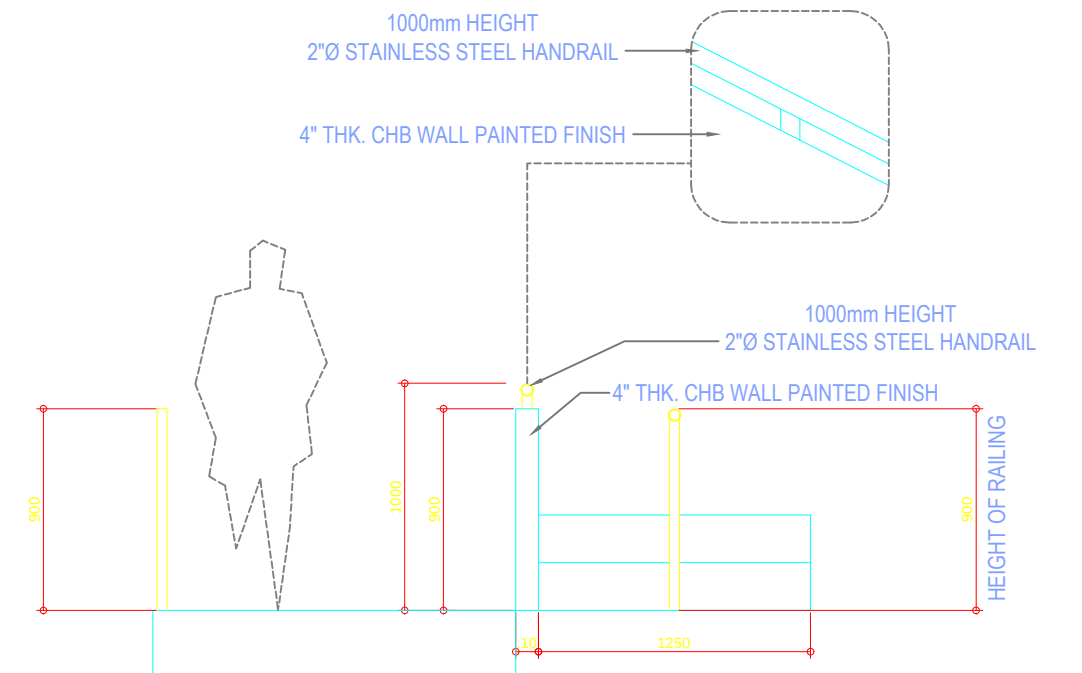


AREA OF BLEACHERS RAILING
SCALE 1:15 MTS.

OWNER	PROJECT TITLE :	SUBMITTED BY :	RECOMMENDING APPROVAL :	APPROVED BY :	SHEET CONTENTS :	DESIGN BY :		SHEET NO :
 PHILIPPINE SPORTS COMMISSION RMSC, PABLO OCAMPO SR. ST., MALATE, MANILA	UPGRADING OF SWIMMING POOL, DIVING POOL, AND CONSTRUCTION OF NEW BLEACHERS, WARM UP POOL AND JACUZZI LOCATION: PHILSPORTS, ULTRA, MERALCO AVE., PASIG CITY	ENGR. PEDRO I. PINEDA JR. HEAD - ENGINEERING UNIT	DIR. MERLITA R. IBAY DEPUTY EXECUTIVE DIRECTOR	HON. WILLIAM I. RAMIREZ CHAIRMAN	AS SHOWN	DRAWN BY :		A 4
						CHECKED BY :		
						DATE :		
						APPROVED BY :		

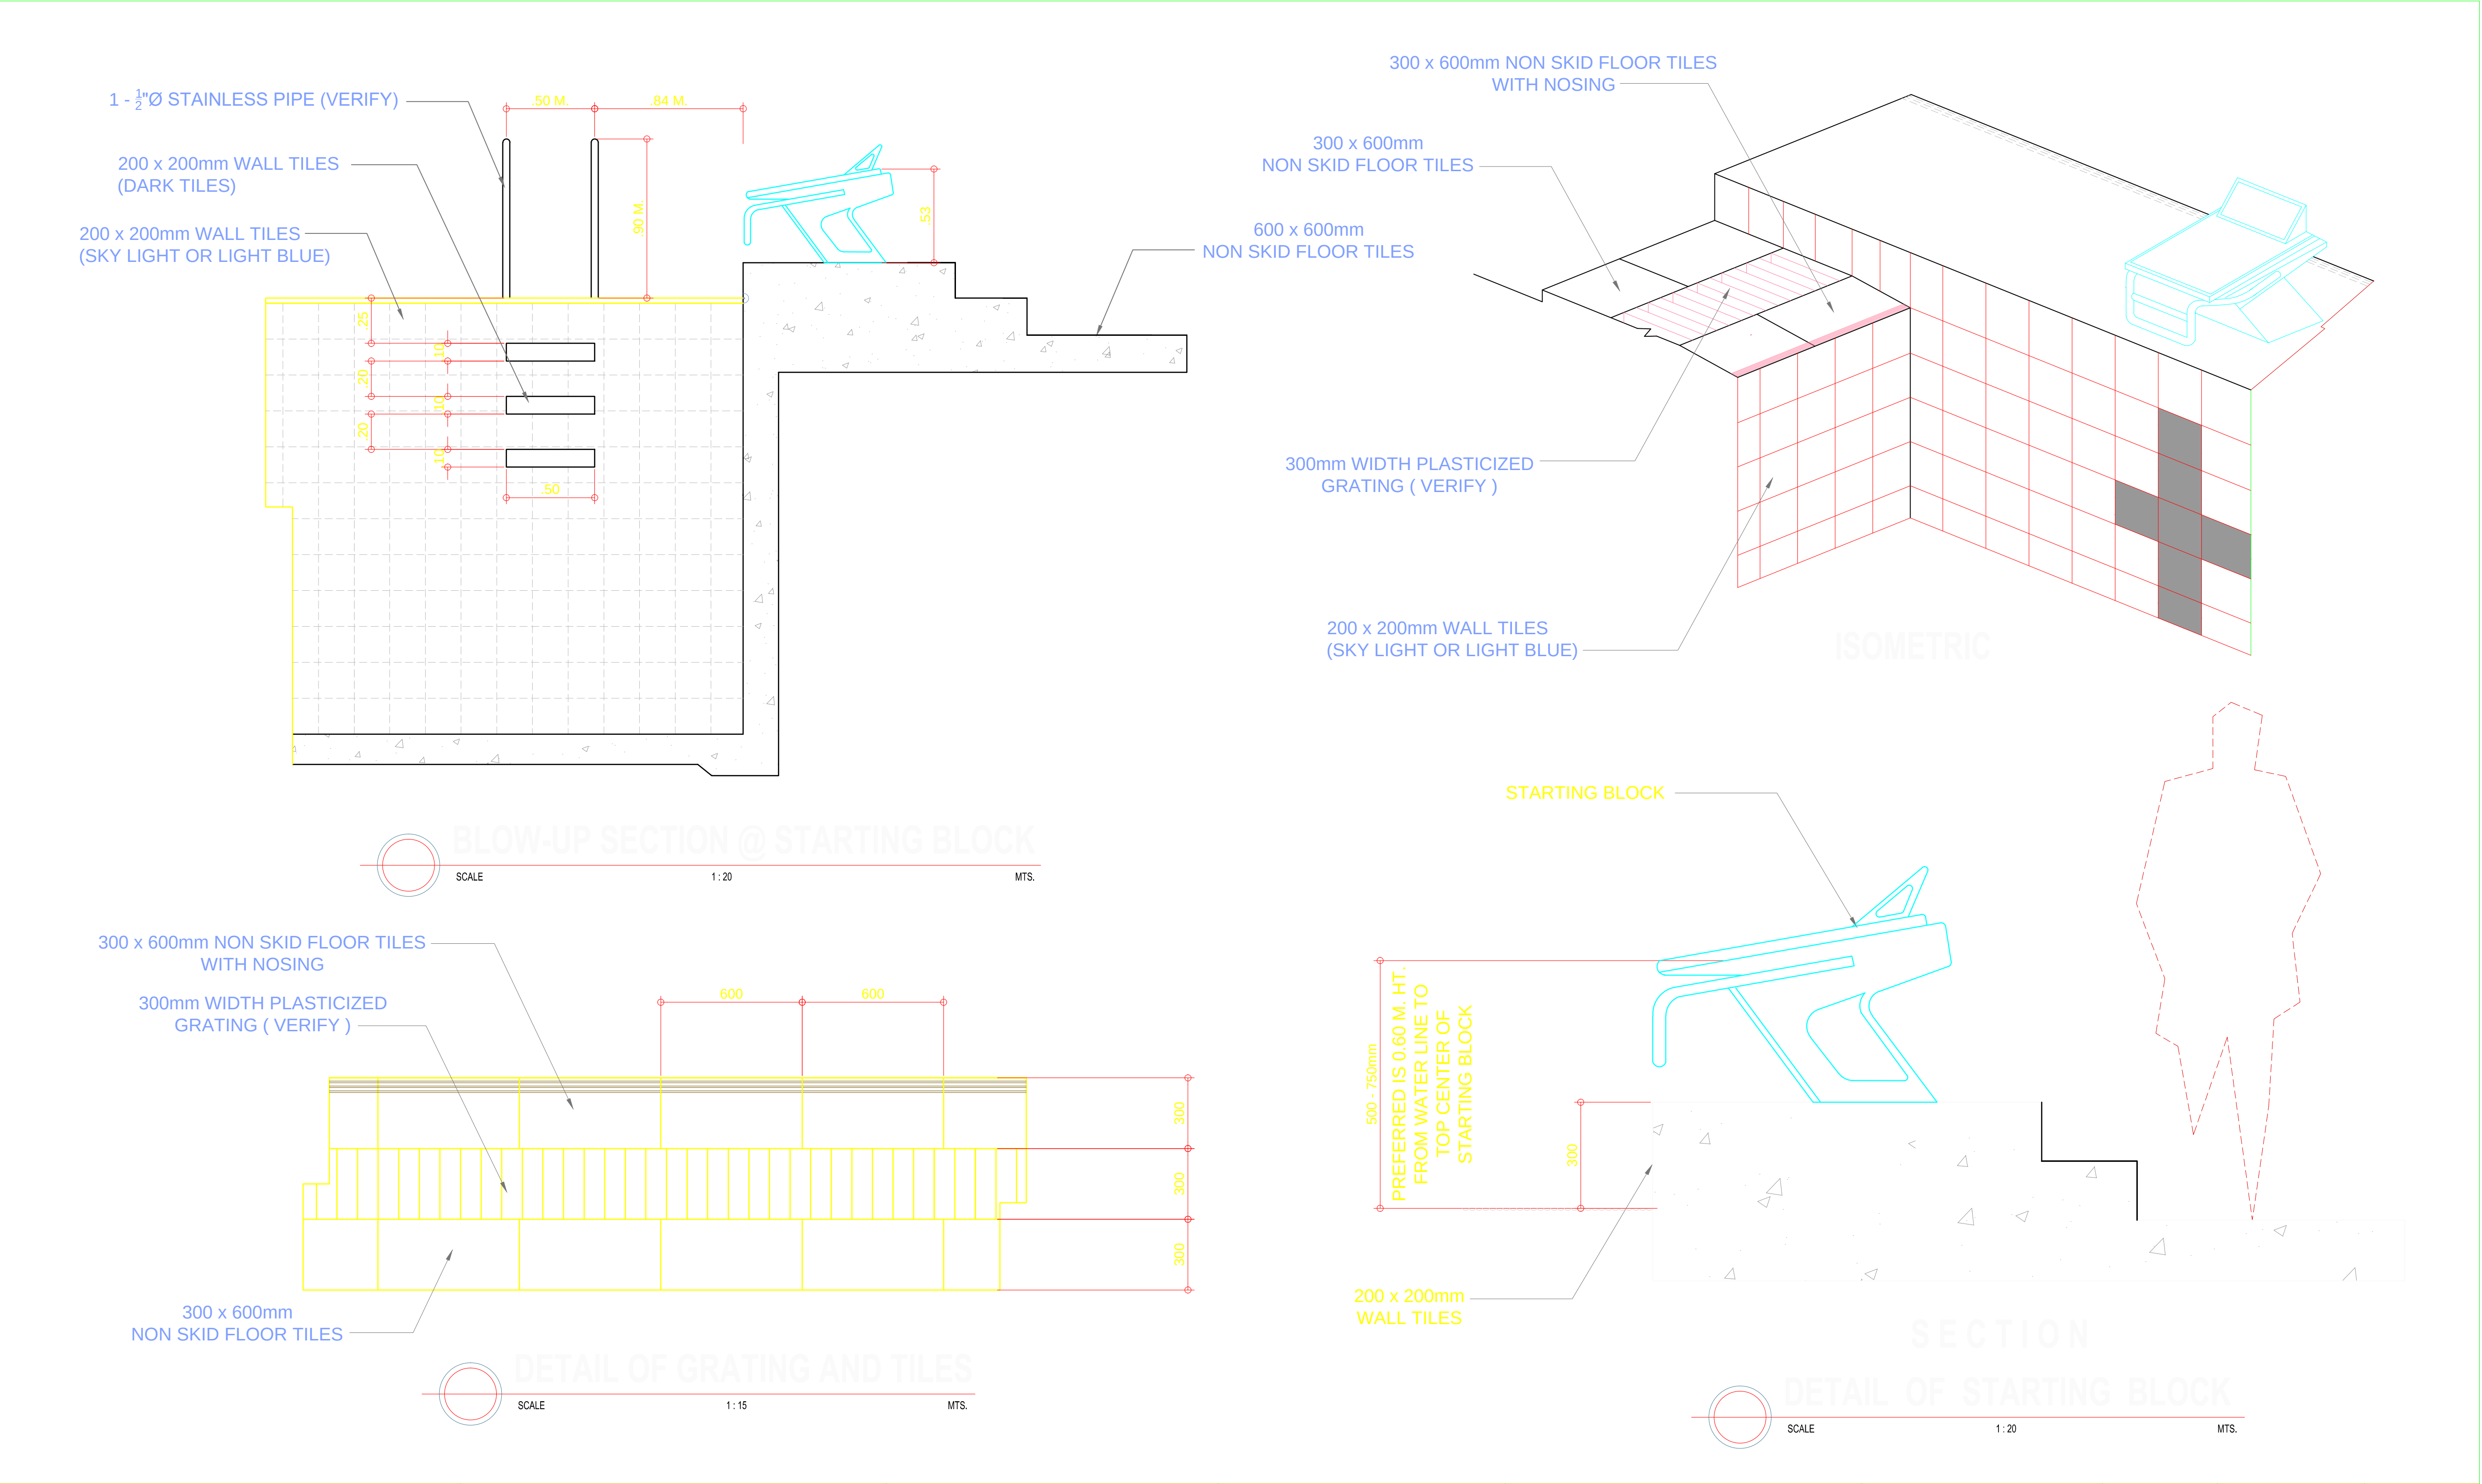

 OWNER	PROJECT TITLE :	SUBMITTED BY :	RECOMMENDING APPROVAL :	APPROVED BY :	SHEET CONTENTS :	DESIGN BY :	SHEET NO :
 PHILIPPINE SPORTS COMMISSION RMSC, PABLO OCAMPO SR. ST., MALATE, MANILA	UPGRADING OF SWIMMING POOL, DIVING POOL, AND CONSTRUCTION OF NEW BLEACHERS, WARM UP POOL AND JACUZZI LOCATION: PHILSPORTS, ULTRA, MERALCO AVE., PASIG CITY	ENGR. PEDRO I. PINEDA JR. HEAD - ENGINEERING UNIT	DIR. MERLITA R. IBAY DEPUTY EXECUTIVE DIRECTOR	HON. WILLIAM I. RAMIREZ CHAIRMAN	AS SHOWN	DRAWN BY :	A 6
						CHECKED BY :	
						DATE :	
						APPROVED BY :	




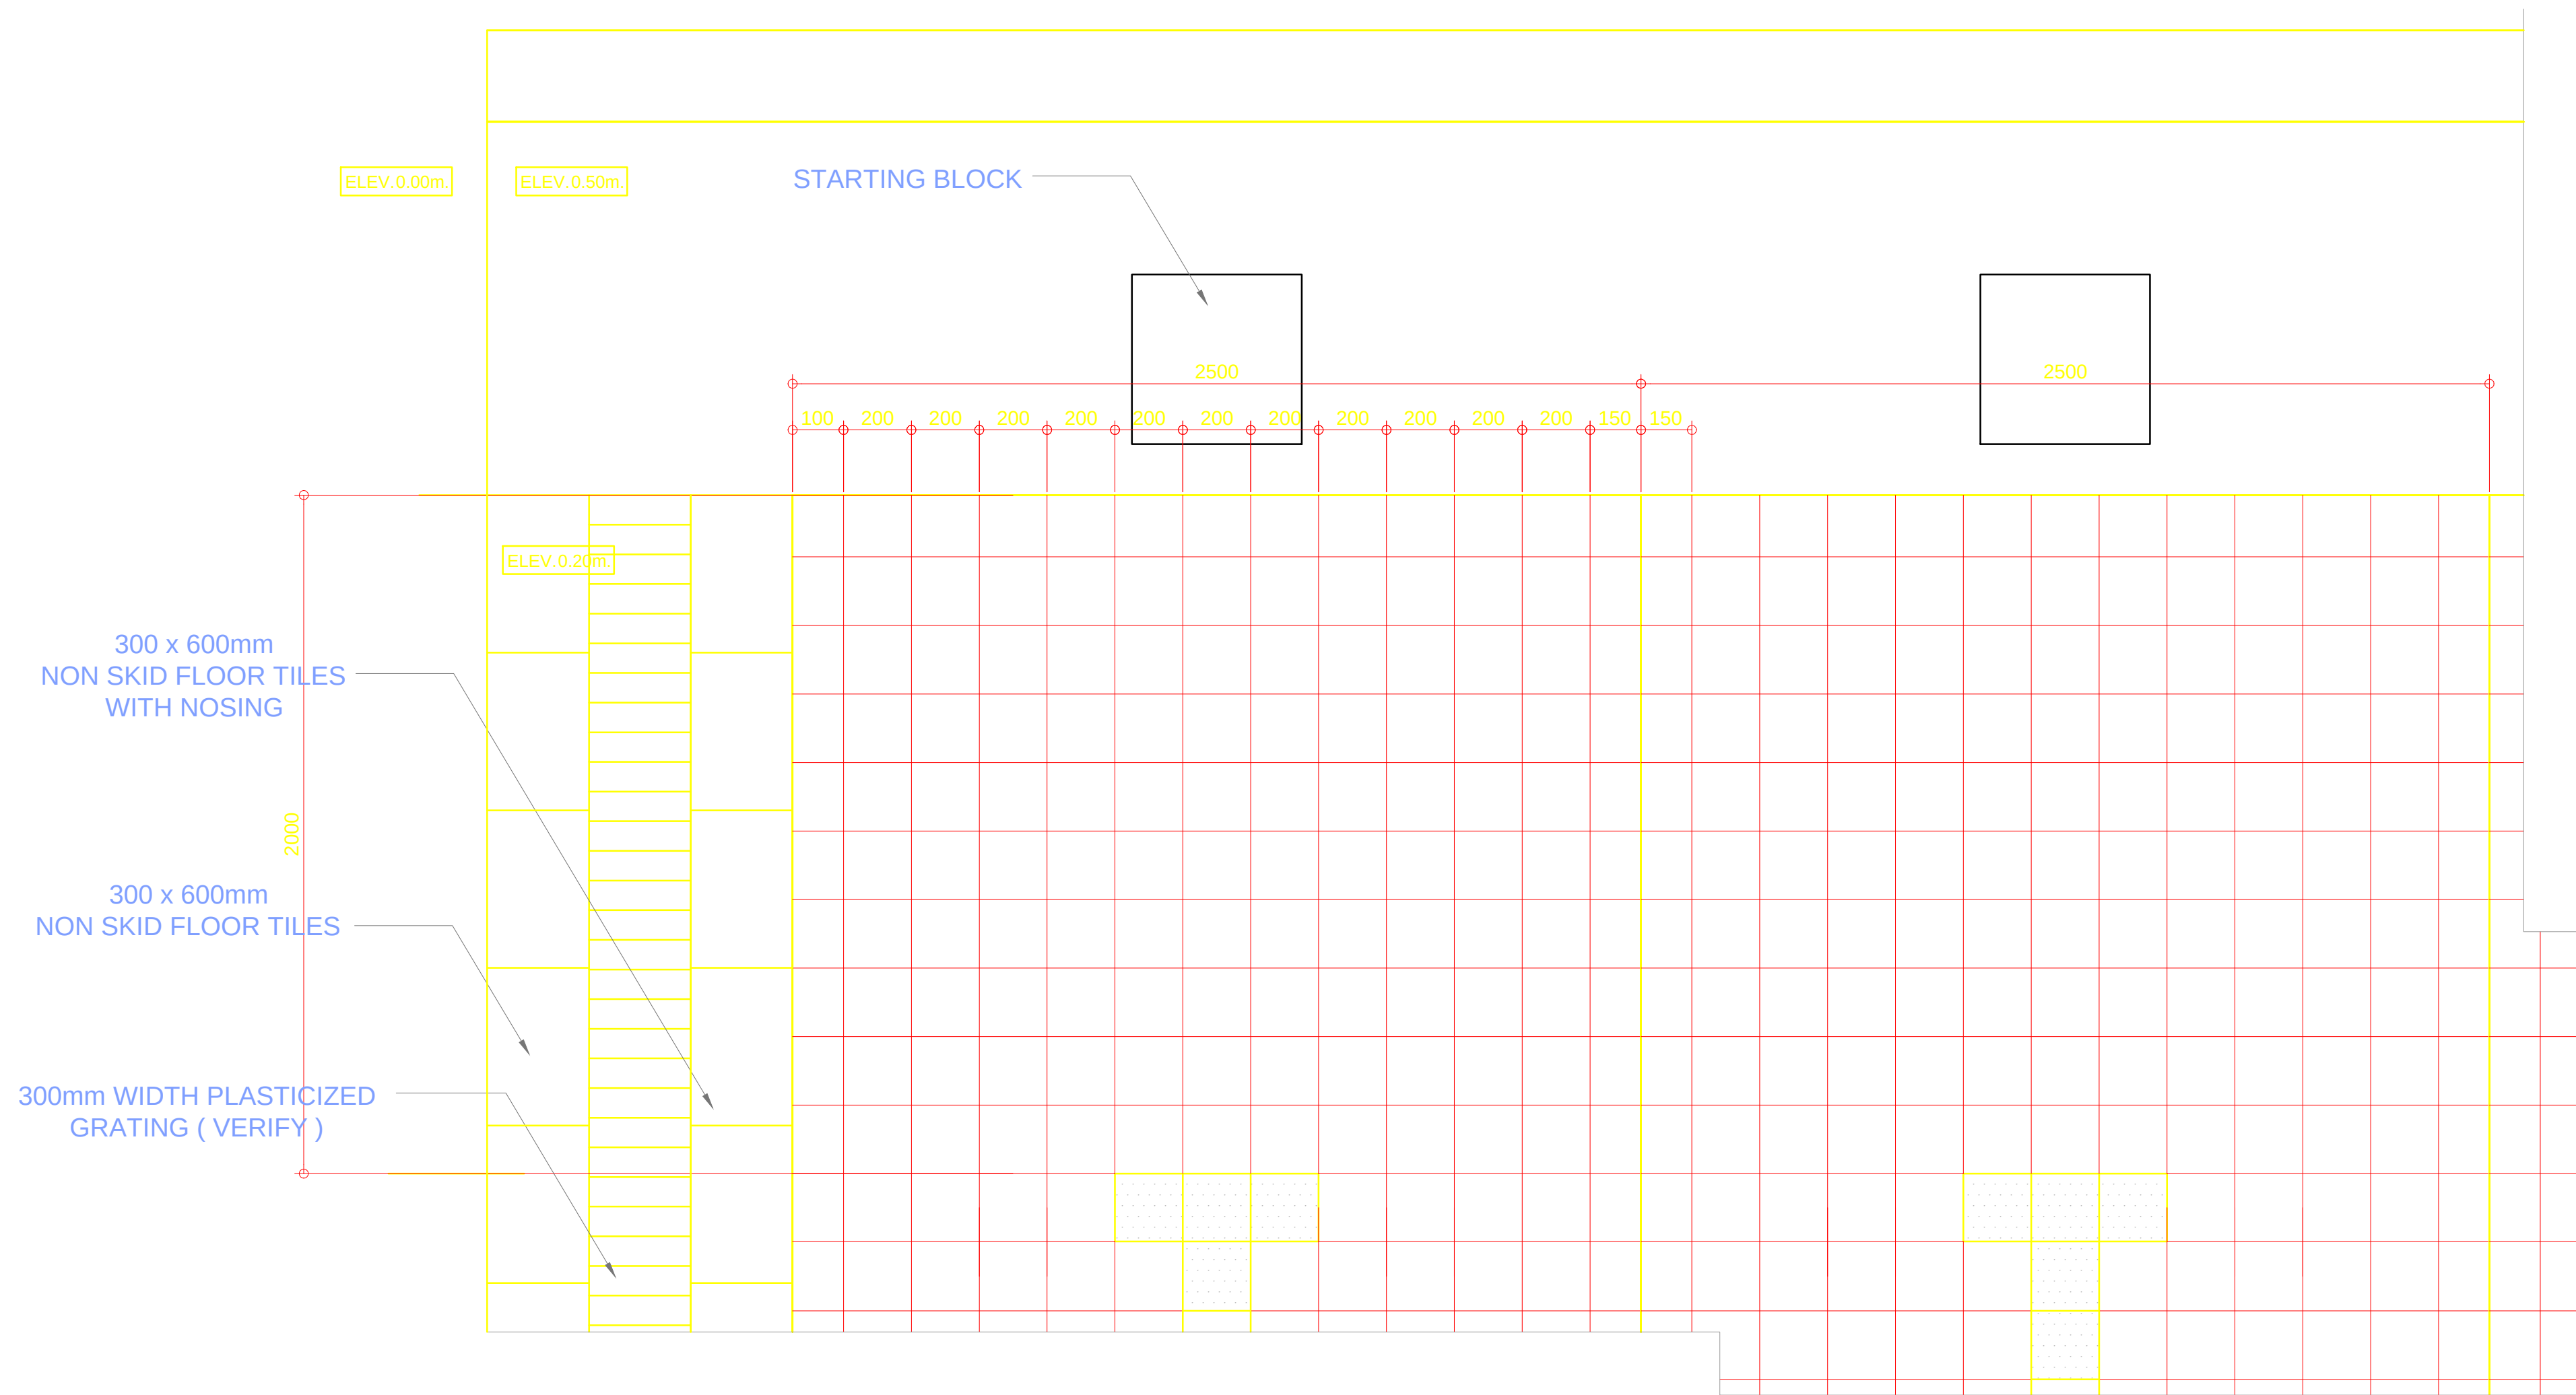


BLOW - UP PLAN OF FLOOR TILE LAYOUT AND STARTING BLOCK
SCALE 1:15 MTS.


OWNER	PROJECT TITLE :	SUBMITTED BY :	RECOMMENDING APPROVAL :	APPROVED BY :	SHEET CONTENTS :	DESIGN BY :		SHEET NO :
 PHILIPPINE SPORTS COMMISSION RMSG, PABLO OCAMPO SR. ST., MALATE, MANILA PHILIPPINE SPORTS COMMISSION	UPGRADING OF SWIMMING POOL, DIVING POOL, AND CONSTRUCTION OF NEW BLEACHERS, WARM UP POOL AND JACUZZI LOCATION: PHILSPORTS, ULTRA, MERALCO AVE., PASIG CITY	ENGR. PEDRO I. PINEDA JR. HEAD - ENGINEERING UNIT	DIR. MERLITA R. IBAY DEPUTY EXECUTIVE DIRECTOR	HON. WILLIAM I. RAMIREZ CHAIRMAN	AS SHOWN	DRAWN BY :		A 7
						CHECKED BY :		
						DATE :		
						APPROVED BY :		




OWNER	PROJECT TITLE :	SUBMITTED BY :	RECOMMENDING APPROVAL :	APPROVED BY :	SHEET CONTENTS :	DESIGN BY :	SHEET NO :
 PHILIPPINE SPORTS COMMISSION RMSC, PABLO OCAMPO SR. ST., MALATE, MANILA	UPGRADING OF SWIMMING POOL, DIVING POOL, AND CONSTRUCTION OF NEW BLEACHERS, WARM UP POOL AND JACUZZI LOCATION: PHILSPORTS, ULTRA, MERALCO AVE., PASIG CITY	ENGR. PEDRO I. PINEDA JR. HEAD - ENGINEERING UNIT	DIR. MERLITA R. IBAY DEPUTY EXECUTIVE DIRECTOR	HON. WILLIAM I. RAMIREZ CHAIRMAN	AS SHOWN	DRAWN BY :	A 8
						CHECKED BY :	
						DATE :	
						APPROVED BY :	

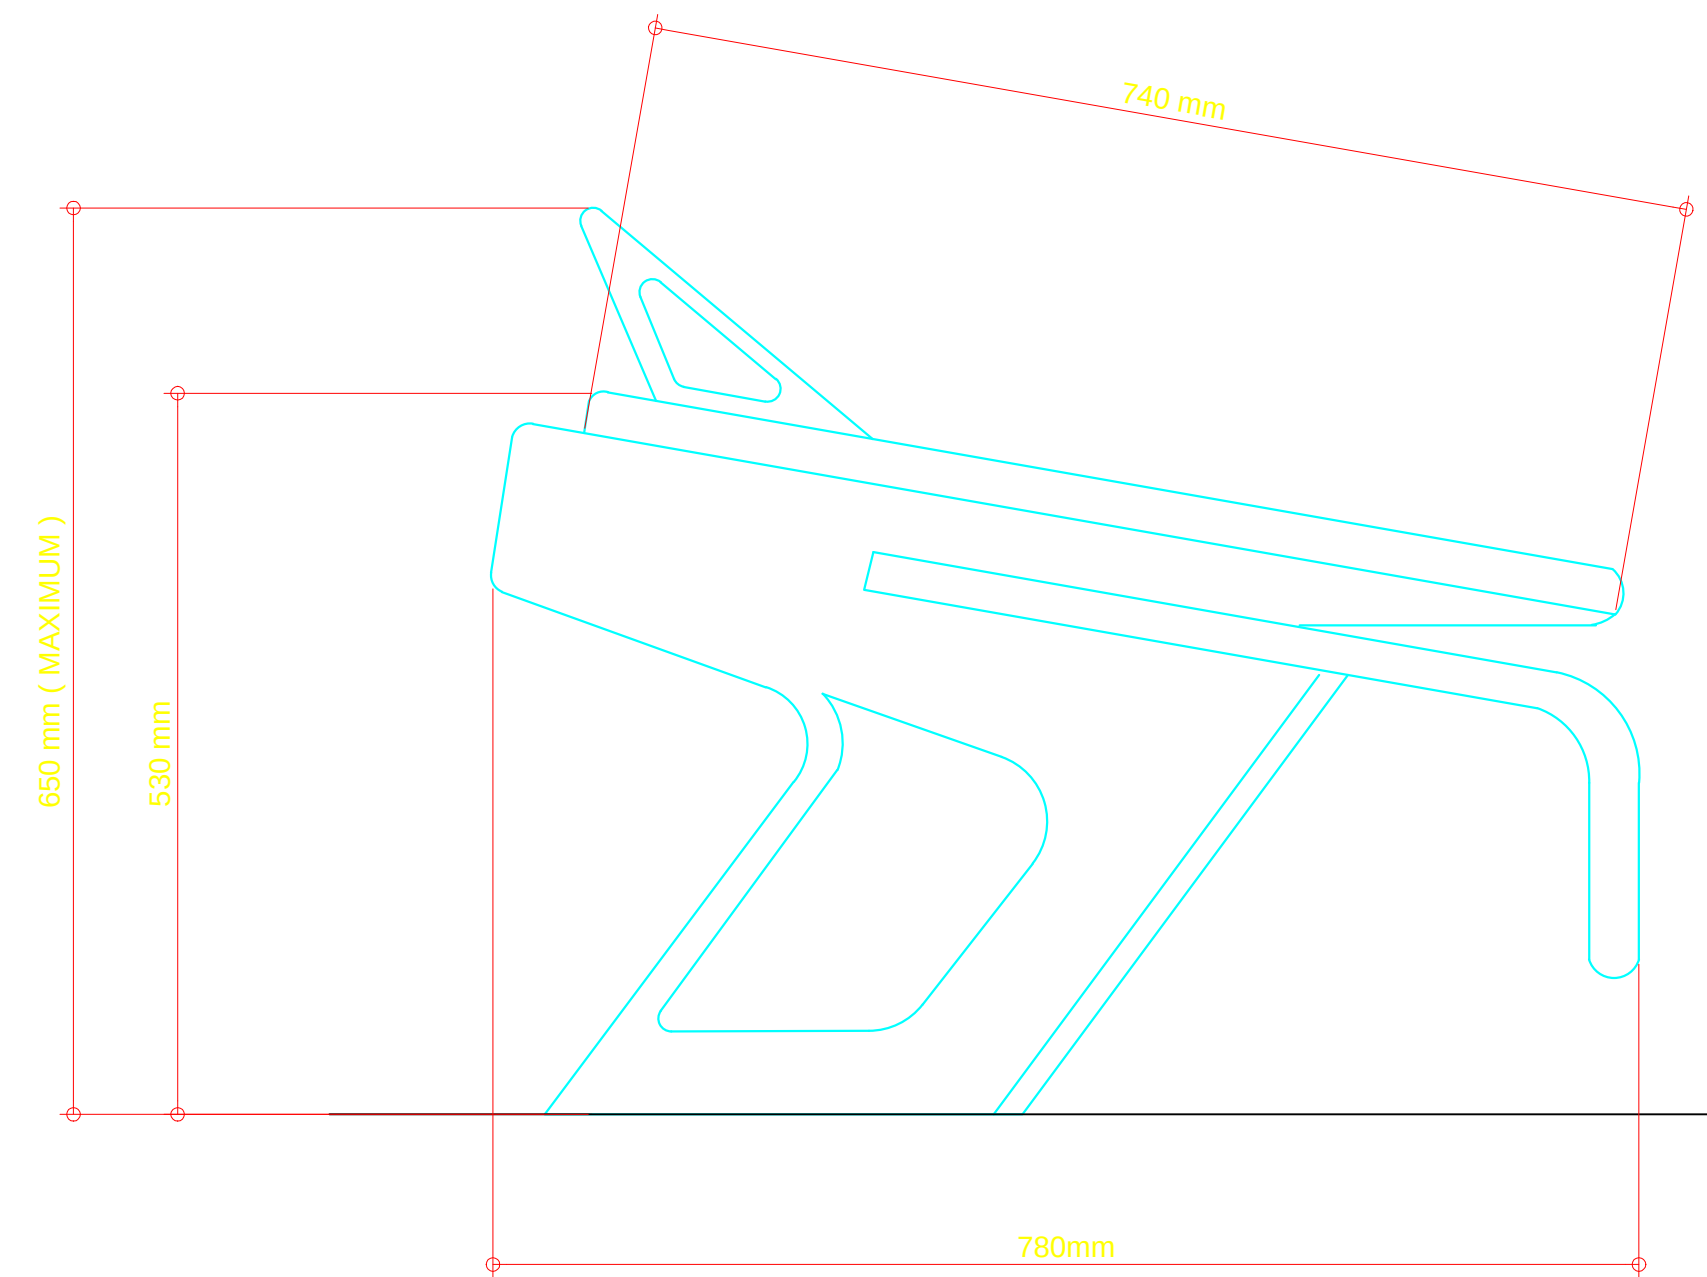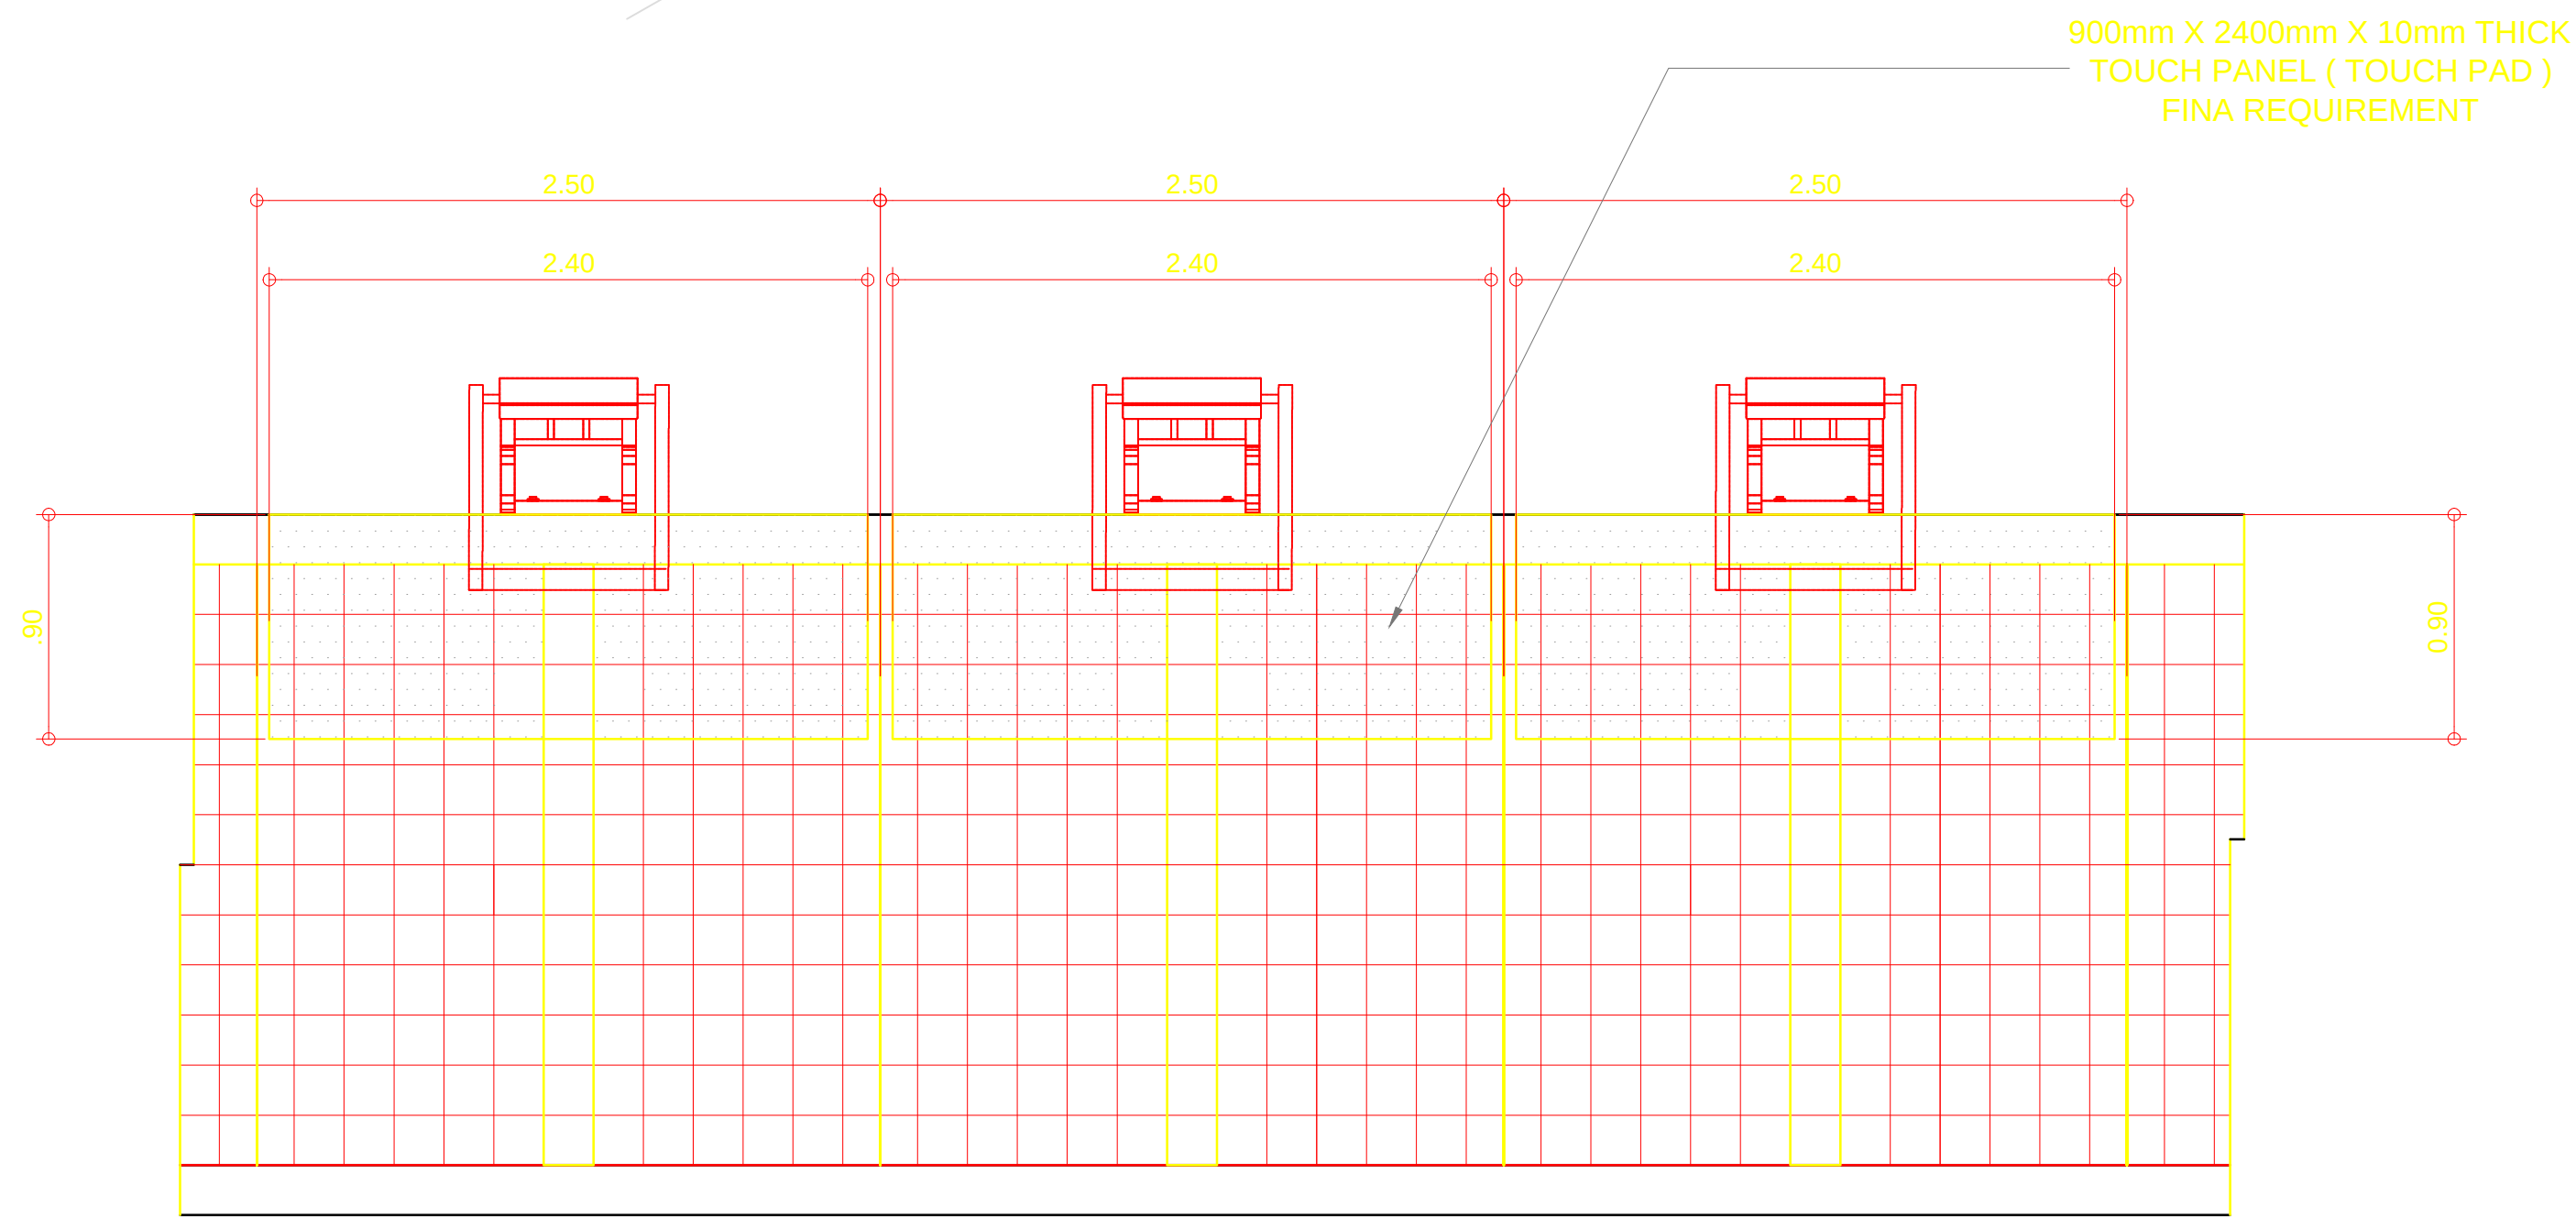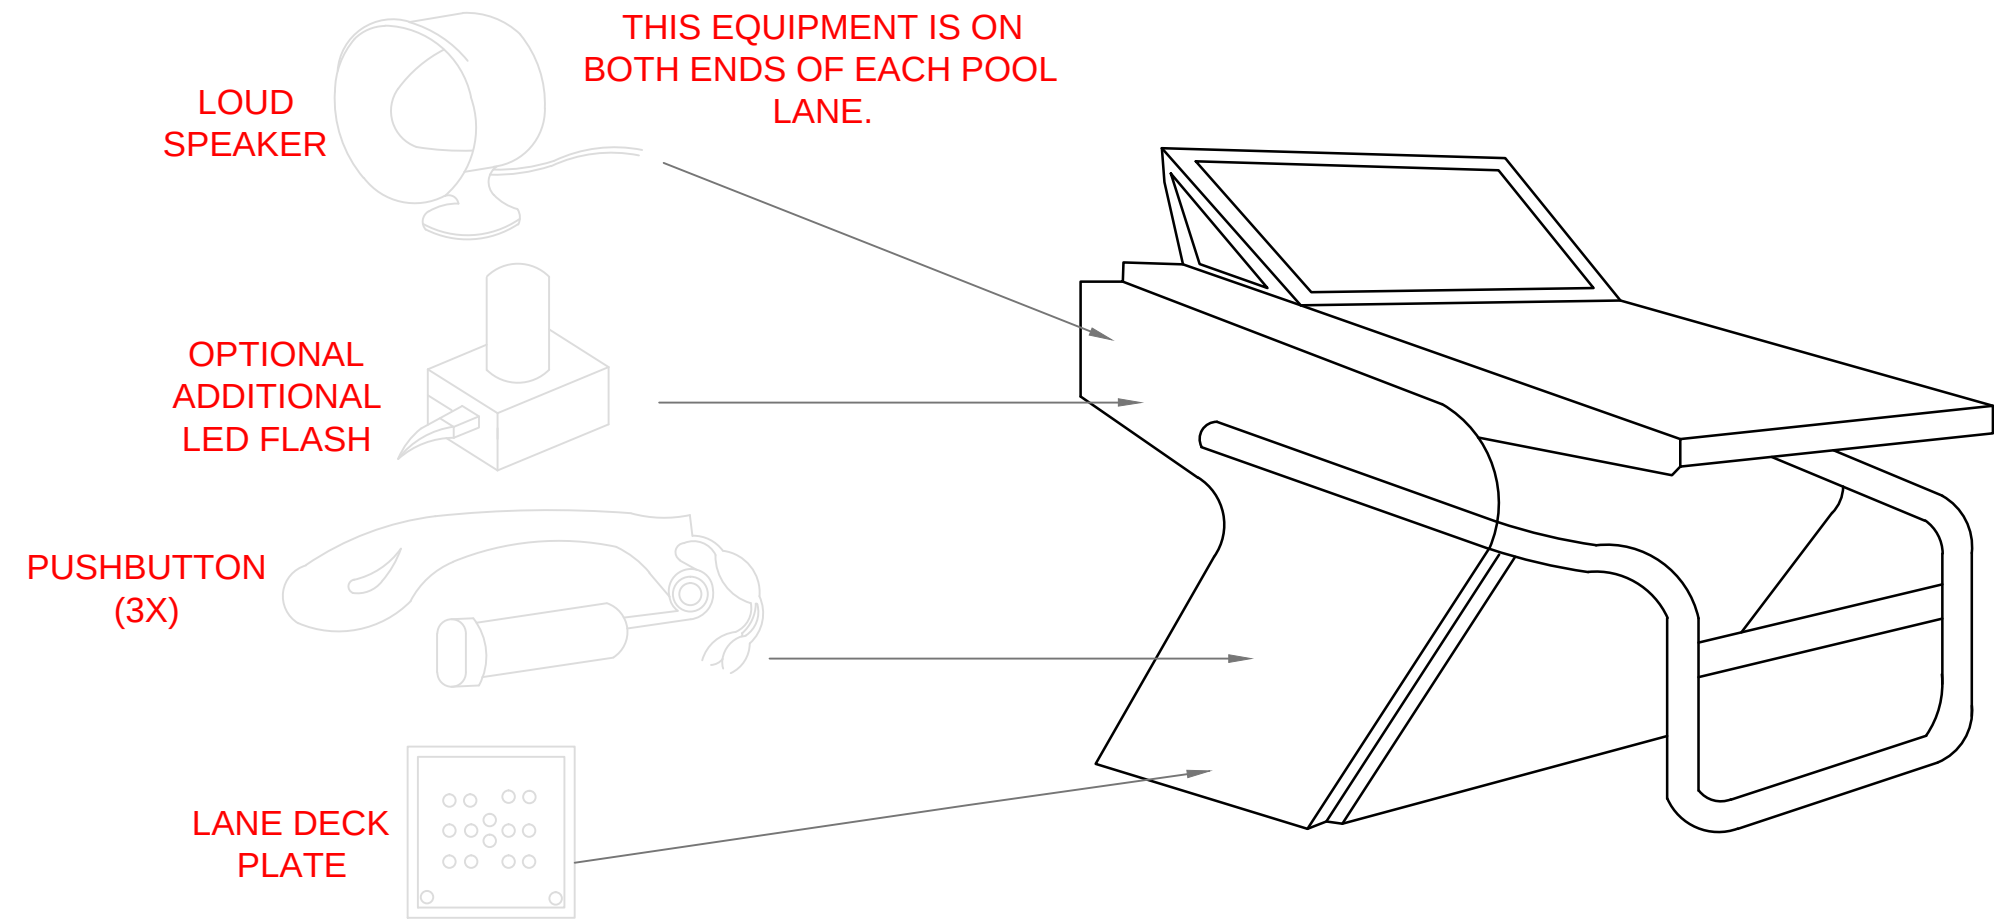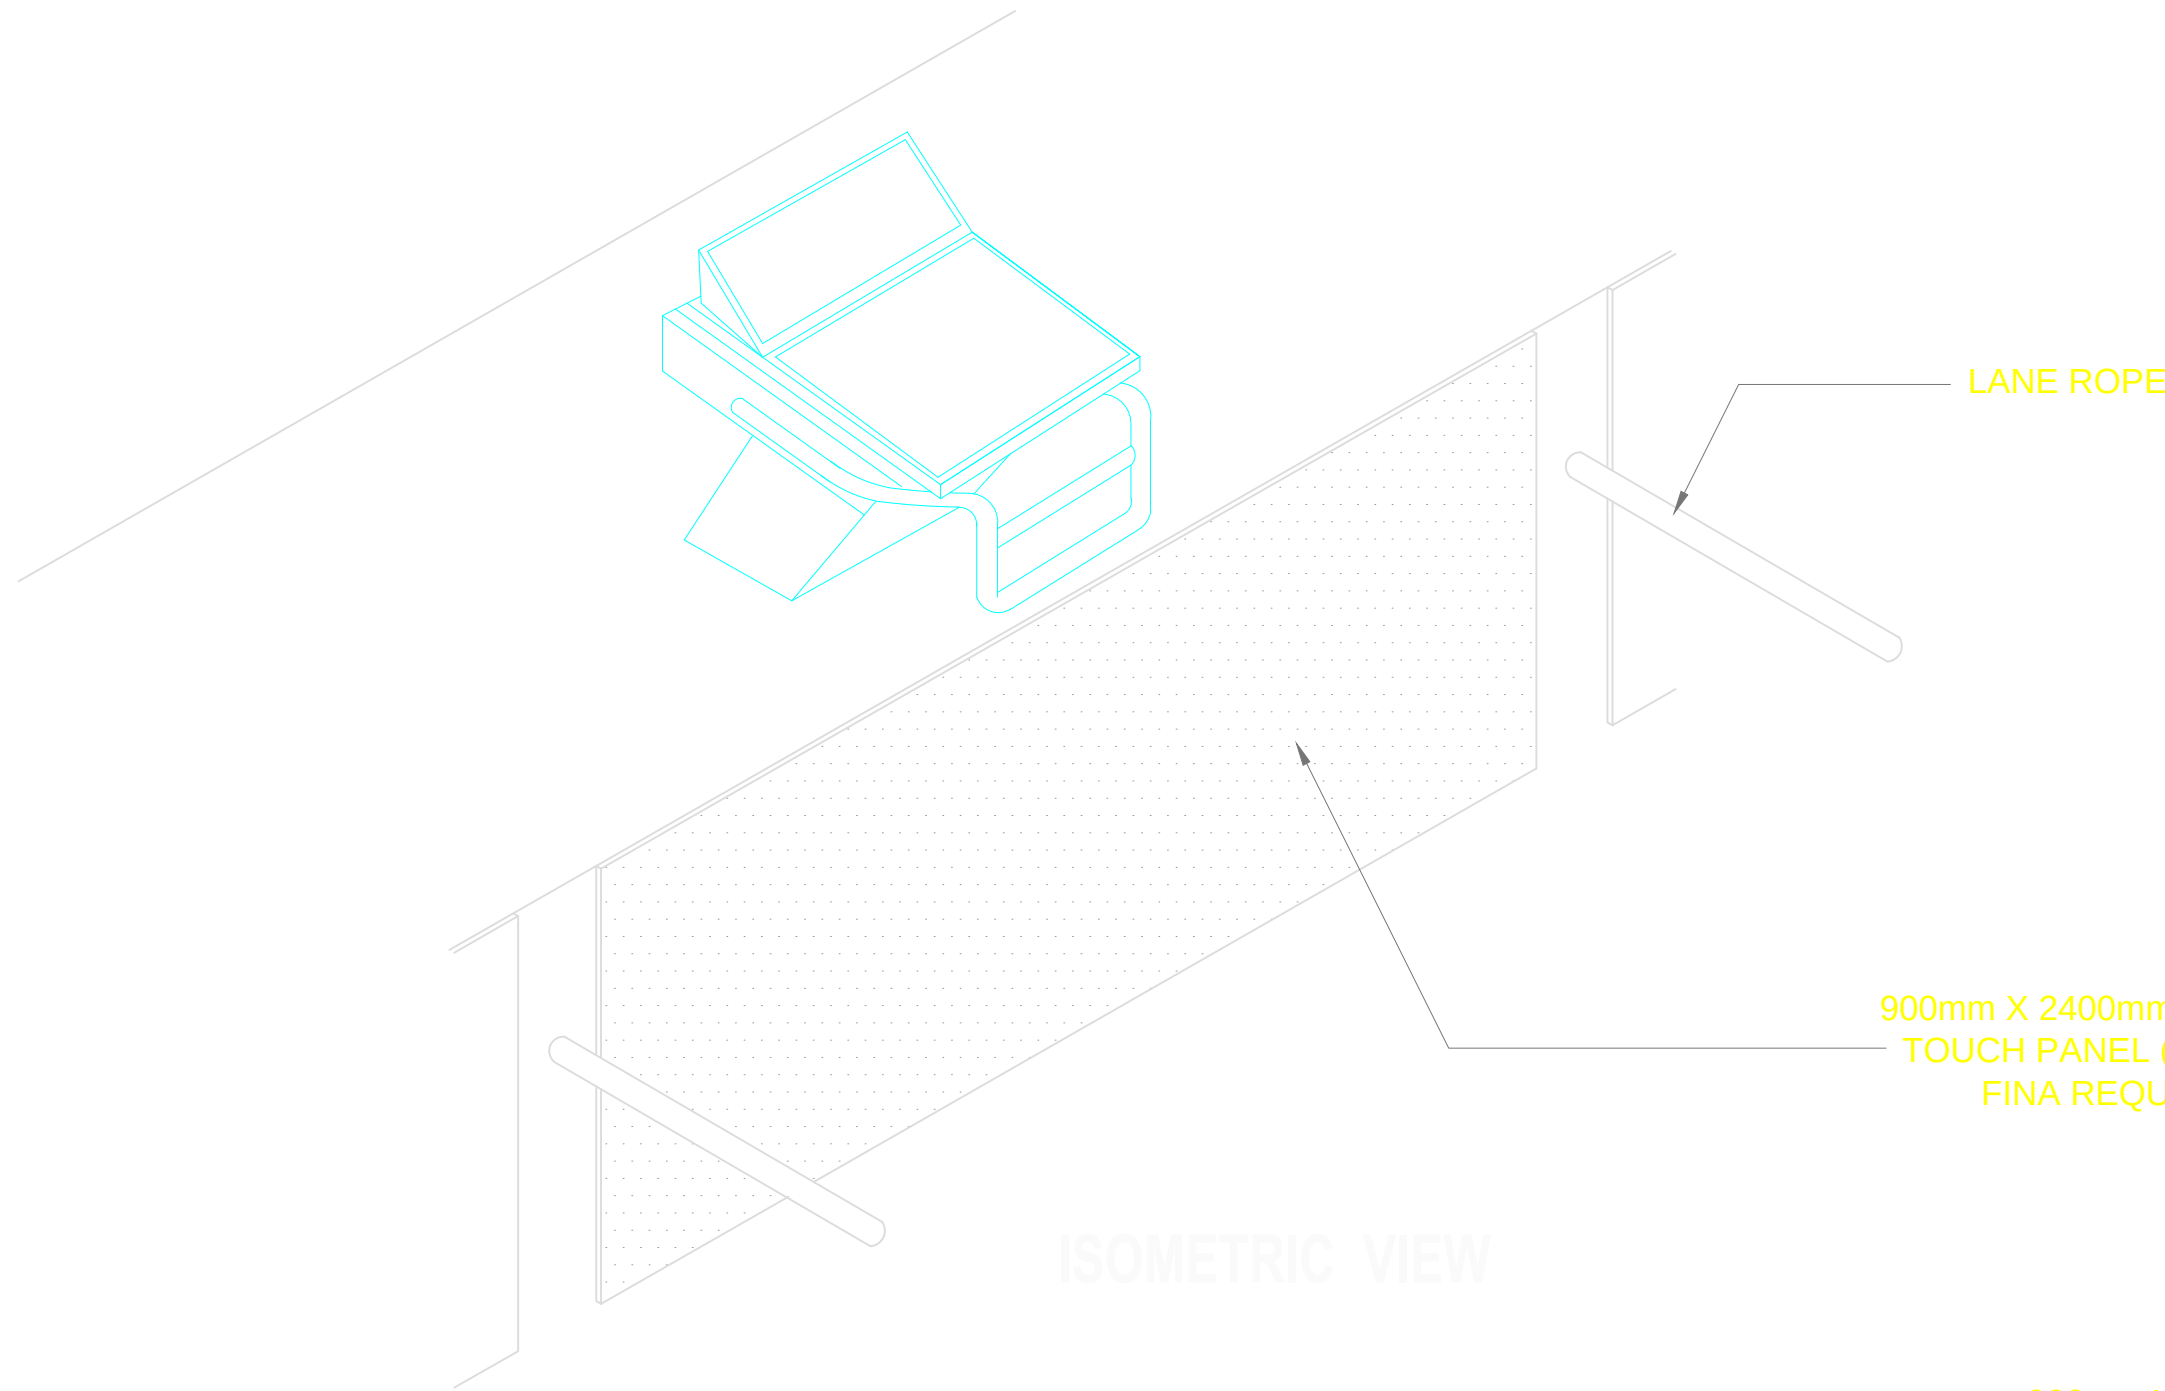


OWNER	PROJECT TITLE :	SUBMITTED BY :	RECOMMENDING APPROVAL :	APPROVED BY :	SHEET CONTENTS :	DESIGN BY :		SHEET NO :
PHILIPPINE SPORTS COMMISSION RMSC, PABLO OCAMPO SR. ST., MALATE, MANILA	UPGRADING OF SWIMMING POOL, DIVING POOL, AND CONSTRUCTION OF NEW BLEACHERS, WARM UP POOL AND JACUZZI LOCATION: PHILSPORTS, ULTRA, MERALCO AVE., PASIG CITY	ENGR. PEDRO I. PINEDA JR. HEAD - ENGINEERING UNIT	DIR. MERLITA R. IBAY DEPUTY EXECUTIVE DIRECTOR	HON. WILLIAM I. RAMIREZ CHAIRMAN	AS SHOWN	DRAWN BY :		A 9
						CHECKED BY :		
						DATE :		
						APPROVED BY :		

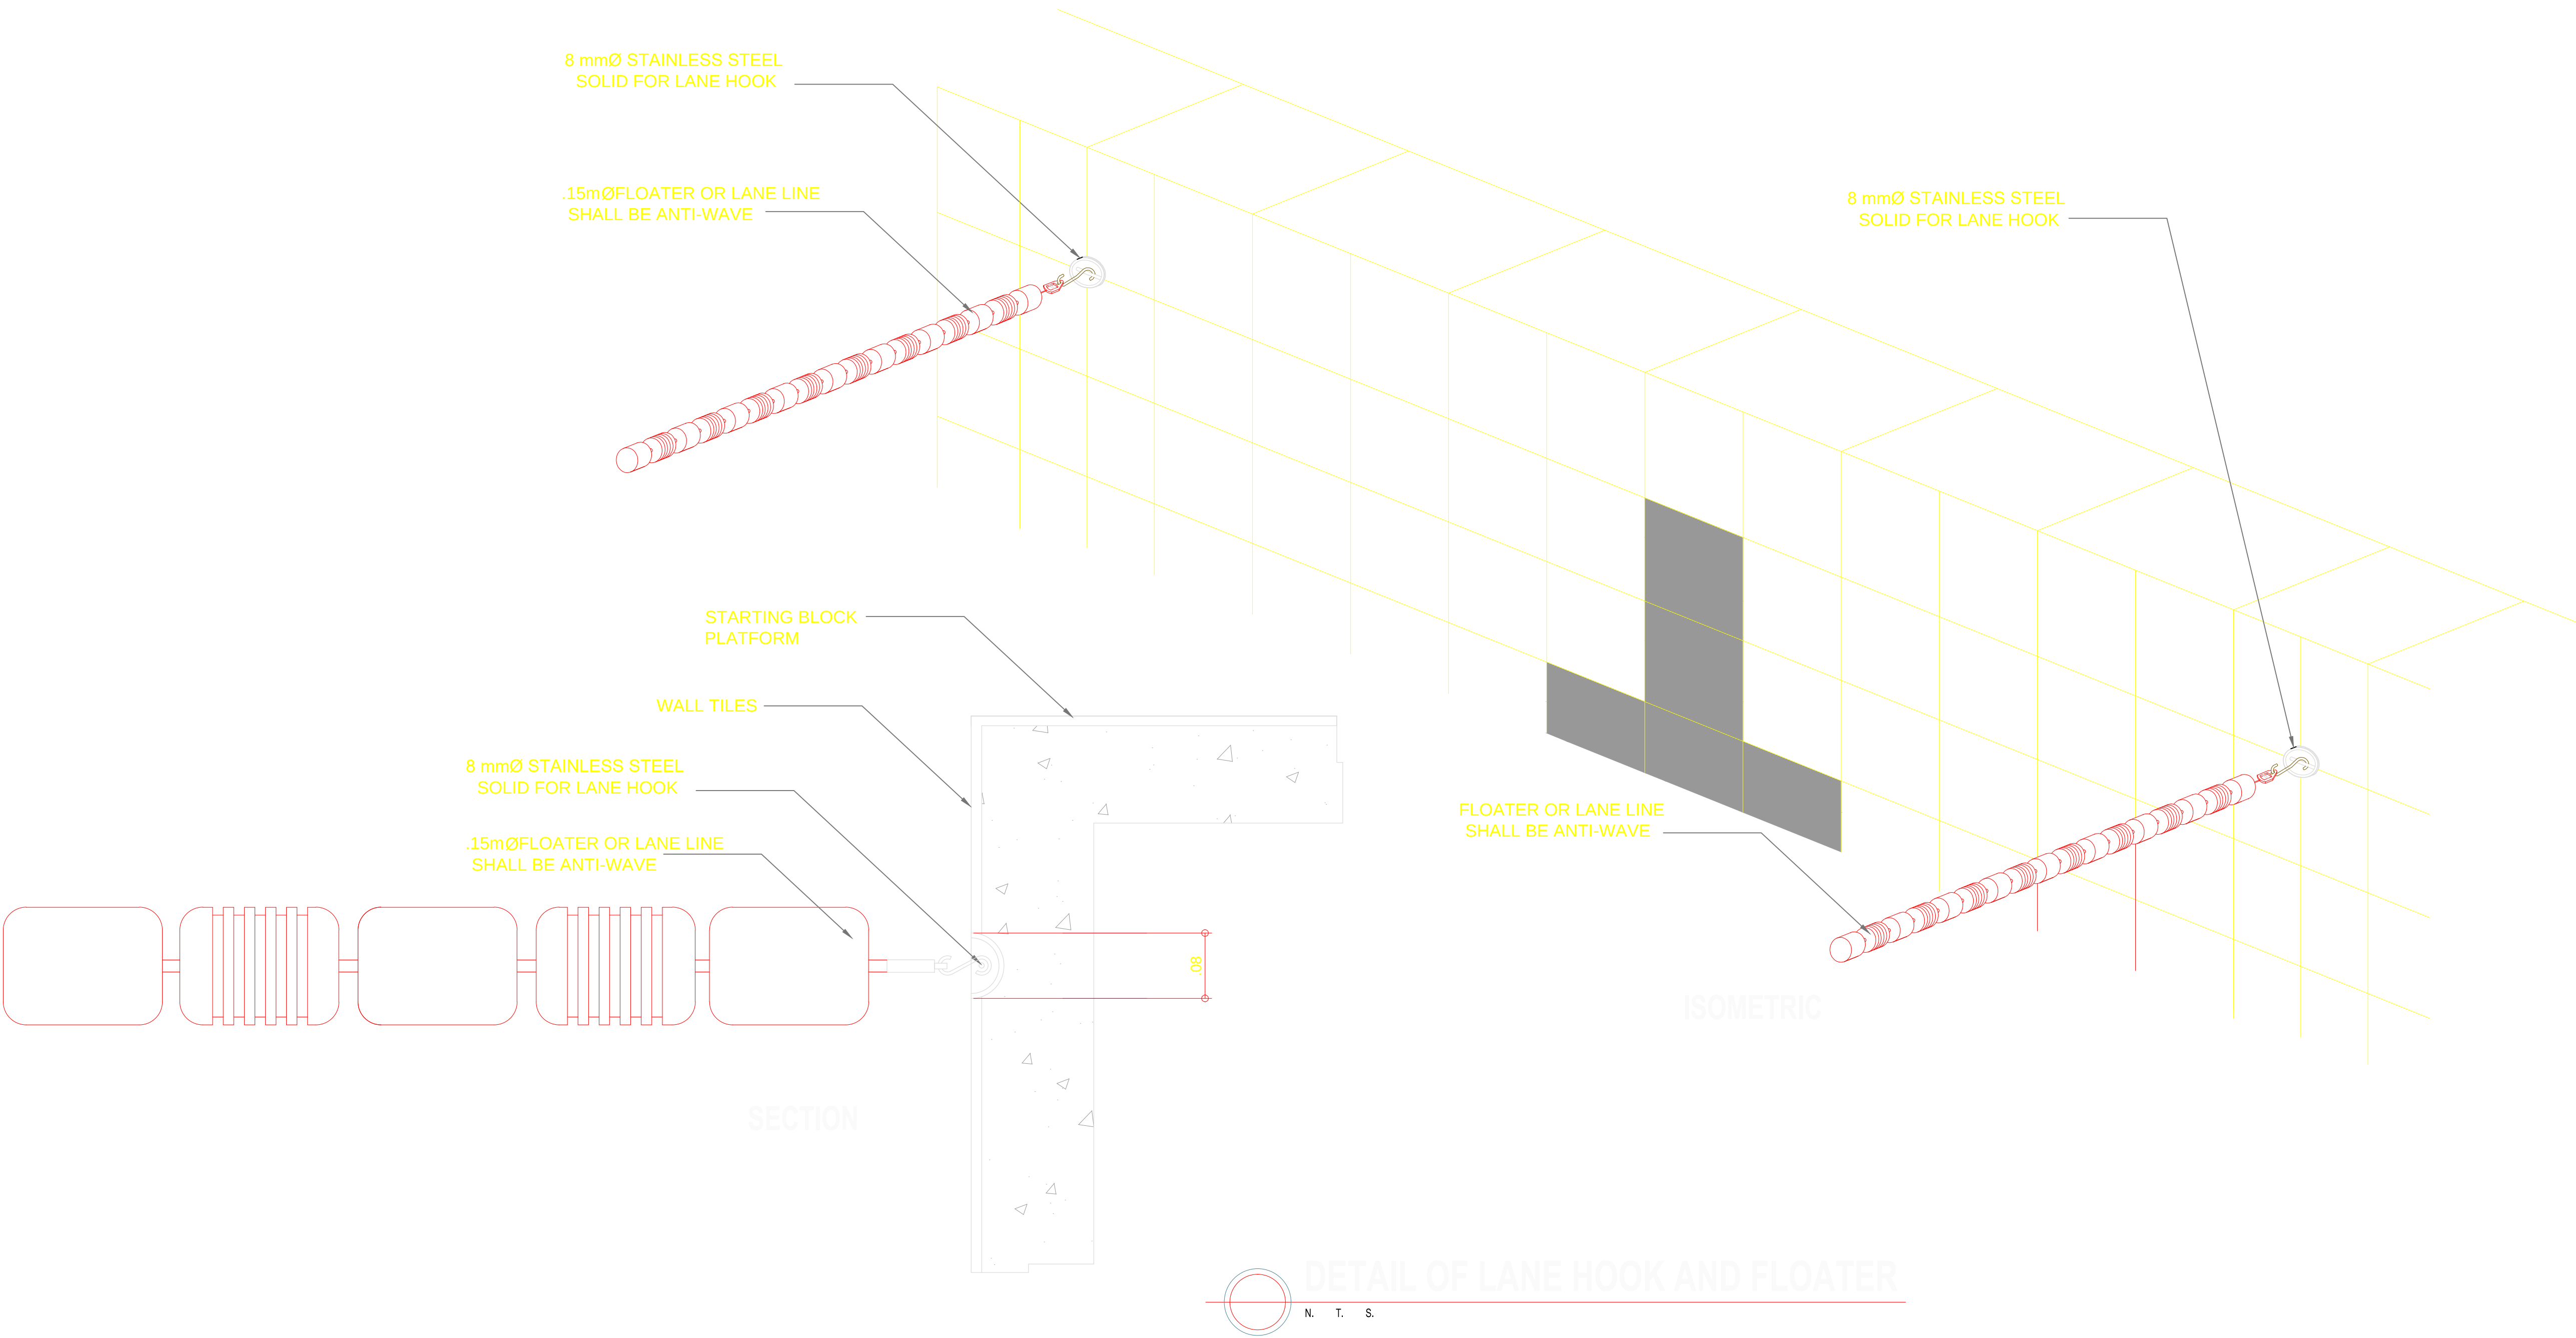


OWNER	PROJECT TITLE :	SUBMITTED BY :	RECOMMENDING APPROVAL :	APPROVED BY :	SHEET CONTENTS :	DESIGN BY :		SHEET NO :
 PHILIPPINE SPORTS COMMISSION RMSG, PABLO OCAMPO SR. ST., MALATE, MANILA	UPGRADING OF SWIMMING POOL, DIVING POOL, AND CONSTRUCTION OF NEW BLEACHERS, WARM UP POOL AND JACUZZI LOCATION: PHILSPORTS, ULTRA, MERALCO AVE., PASIG CITY	ENGR. PEDRO I. PINEDA JR. HEAD - ENGINEERING UNIT	DIR. MERLITA R. IBAY DEPUTY EXECUTIVE DIRECTOR	HON. WILLIAM I. RAMIREZ CHAIRMAN	AS SHOWN	DRAWN BY : CHECKED BY : DATE : APPROVED BY :		A 10

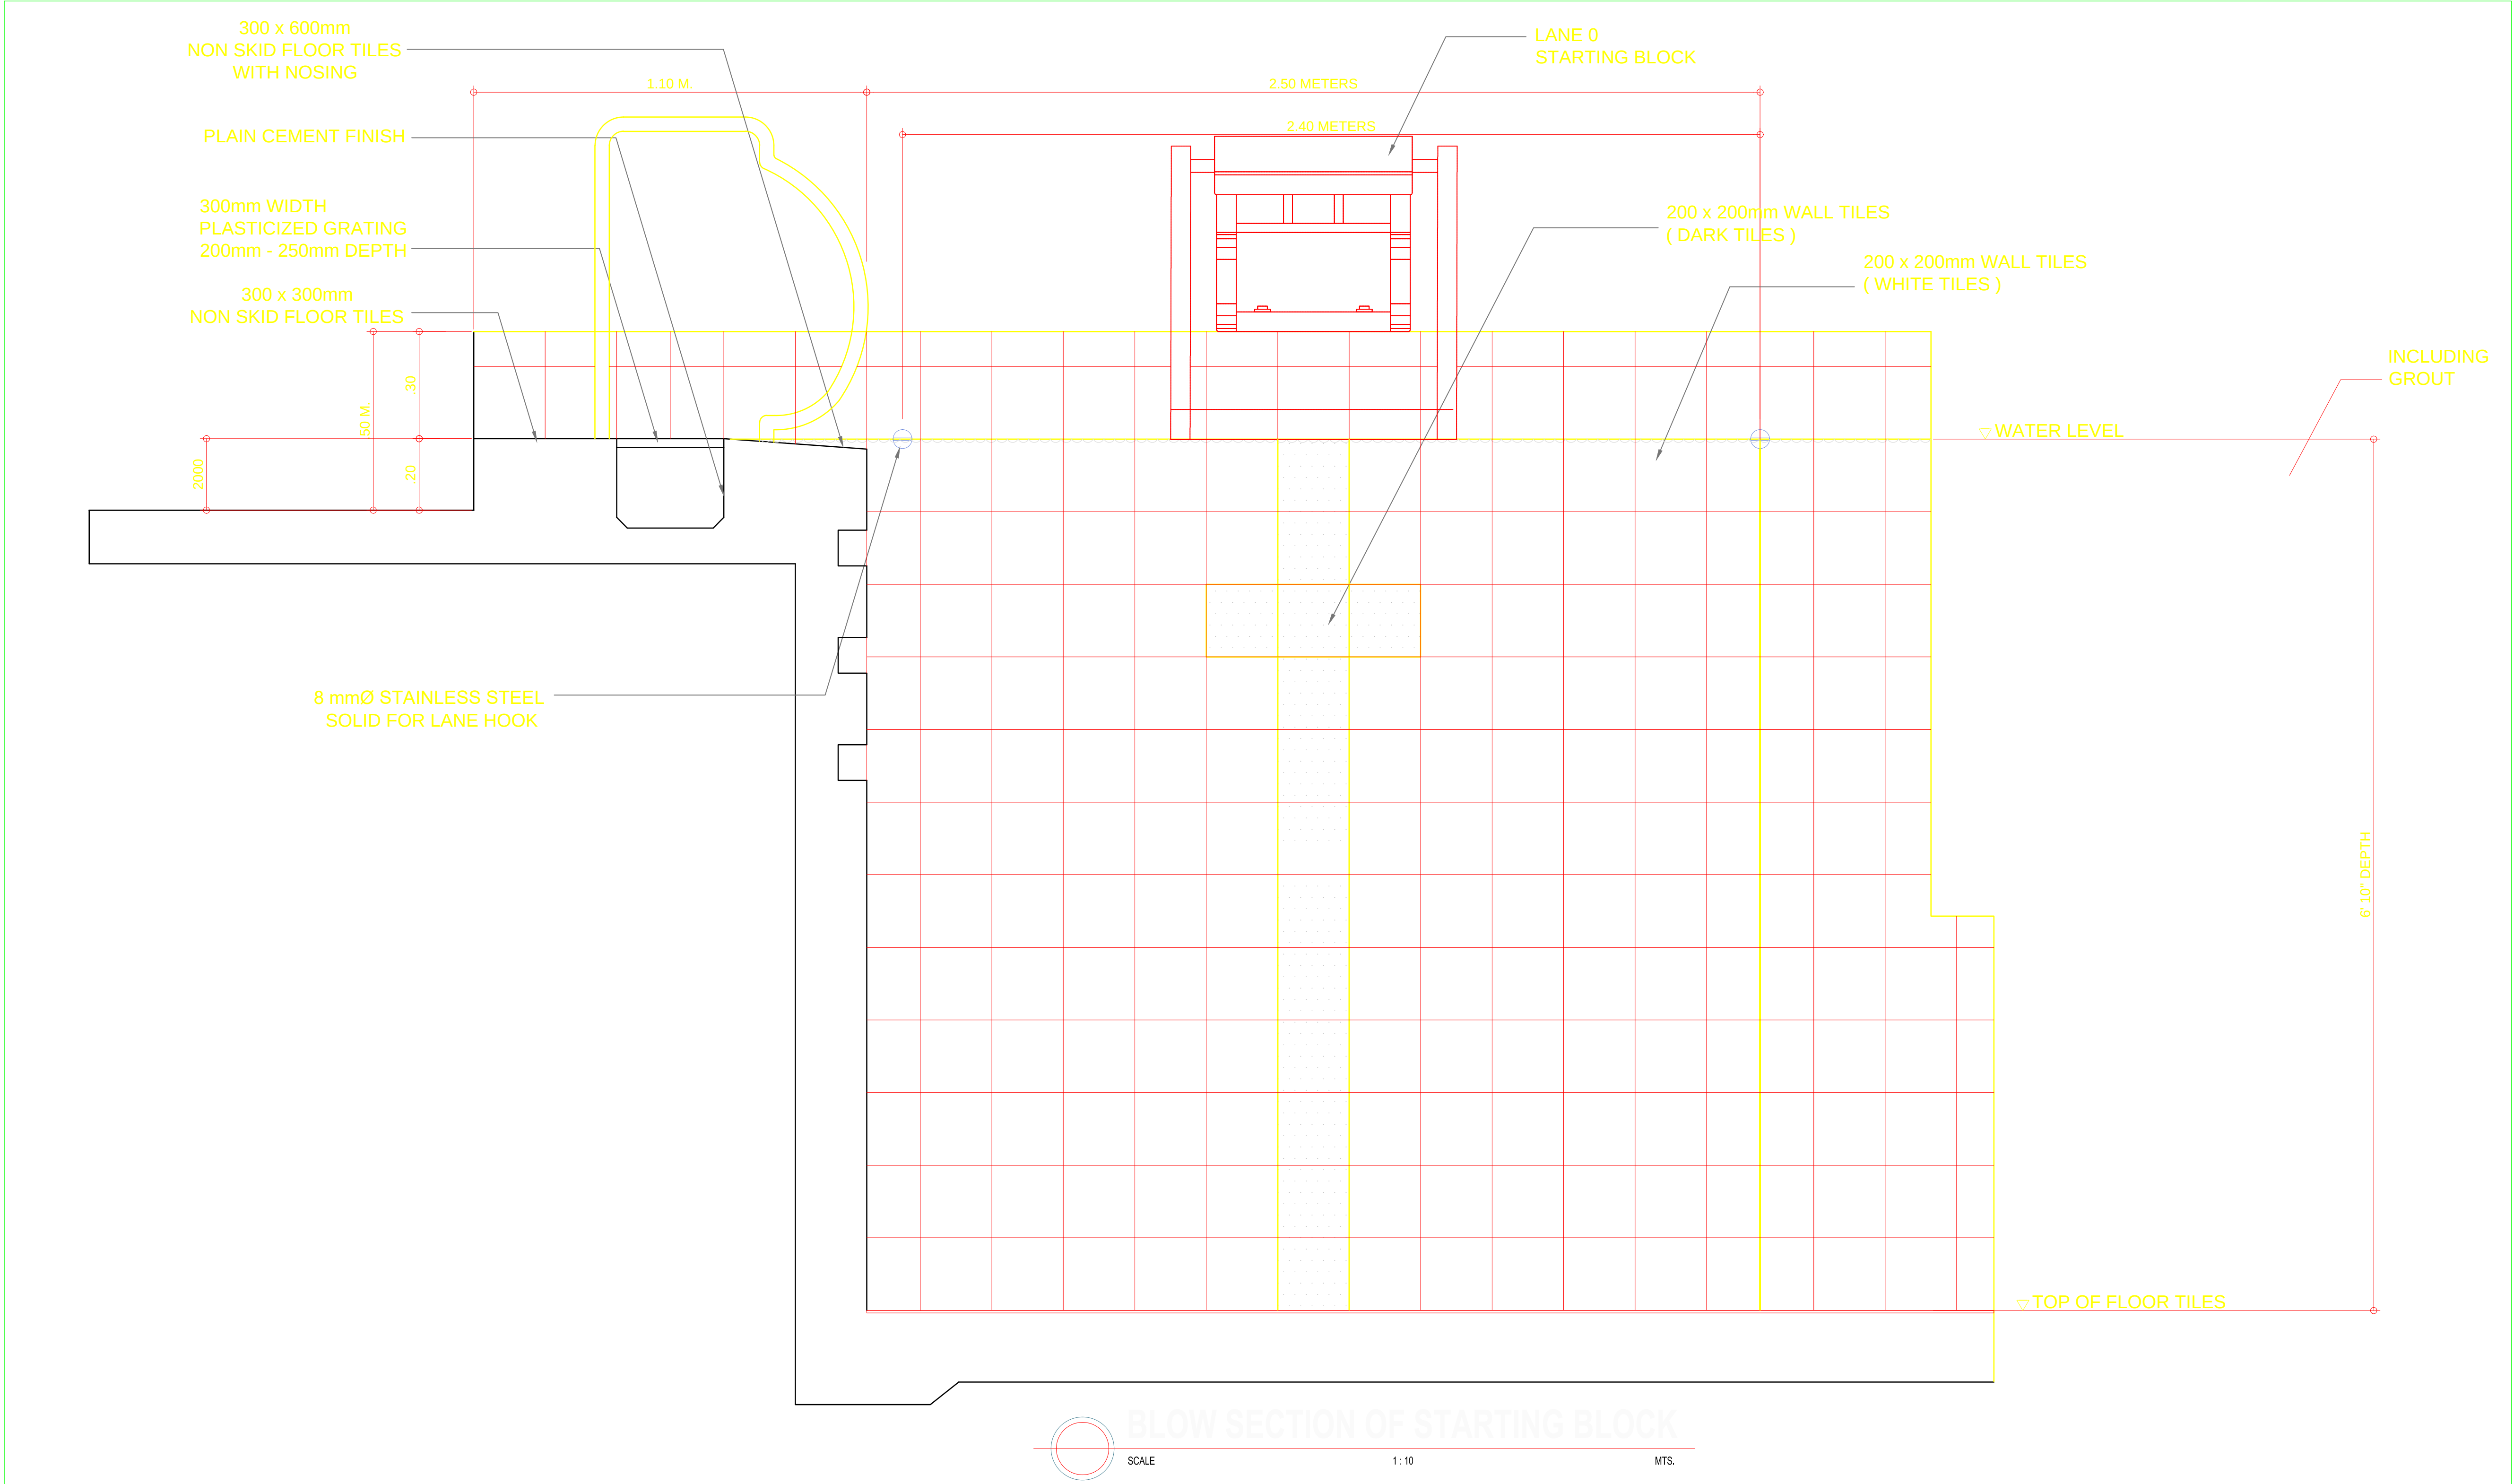


OWNER	PROJECT TITLE :	SUBMITTED BY :	RECOMMENDING APPROVAL :	APPROVED BY :	SHEET CONTENTS :	DESIGN BY :		SHEET NO :
 PHILIPPINE SPORTS COMMISSION RMSG, PABLO OCAMPO SR. ST., MALATE, MANILA	UPGRADING OF SWIMMING POOL, DIVING POOL, AND CONSTRUCTION OF NEW BLEACHERS, WARM UP POOL AND JACUZZI LOCATION: PHILSPORTS, ULTRA, MERALCO AVE., PASIG CITY	ENGR. PEDRO I. PINEDA JR. HEAD - ENGINEERING UNIT	DIR. MERLITA R. IBAY DEPUTY EXECUTIVE DIRECTOR	HON. WILLIAM I. RAMIREZ CHAIRMAN	AS SHOWN	DRAWN BY :		A 11
						CHECKED BY :		
						DATE :		
						APPROVED BY :		

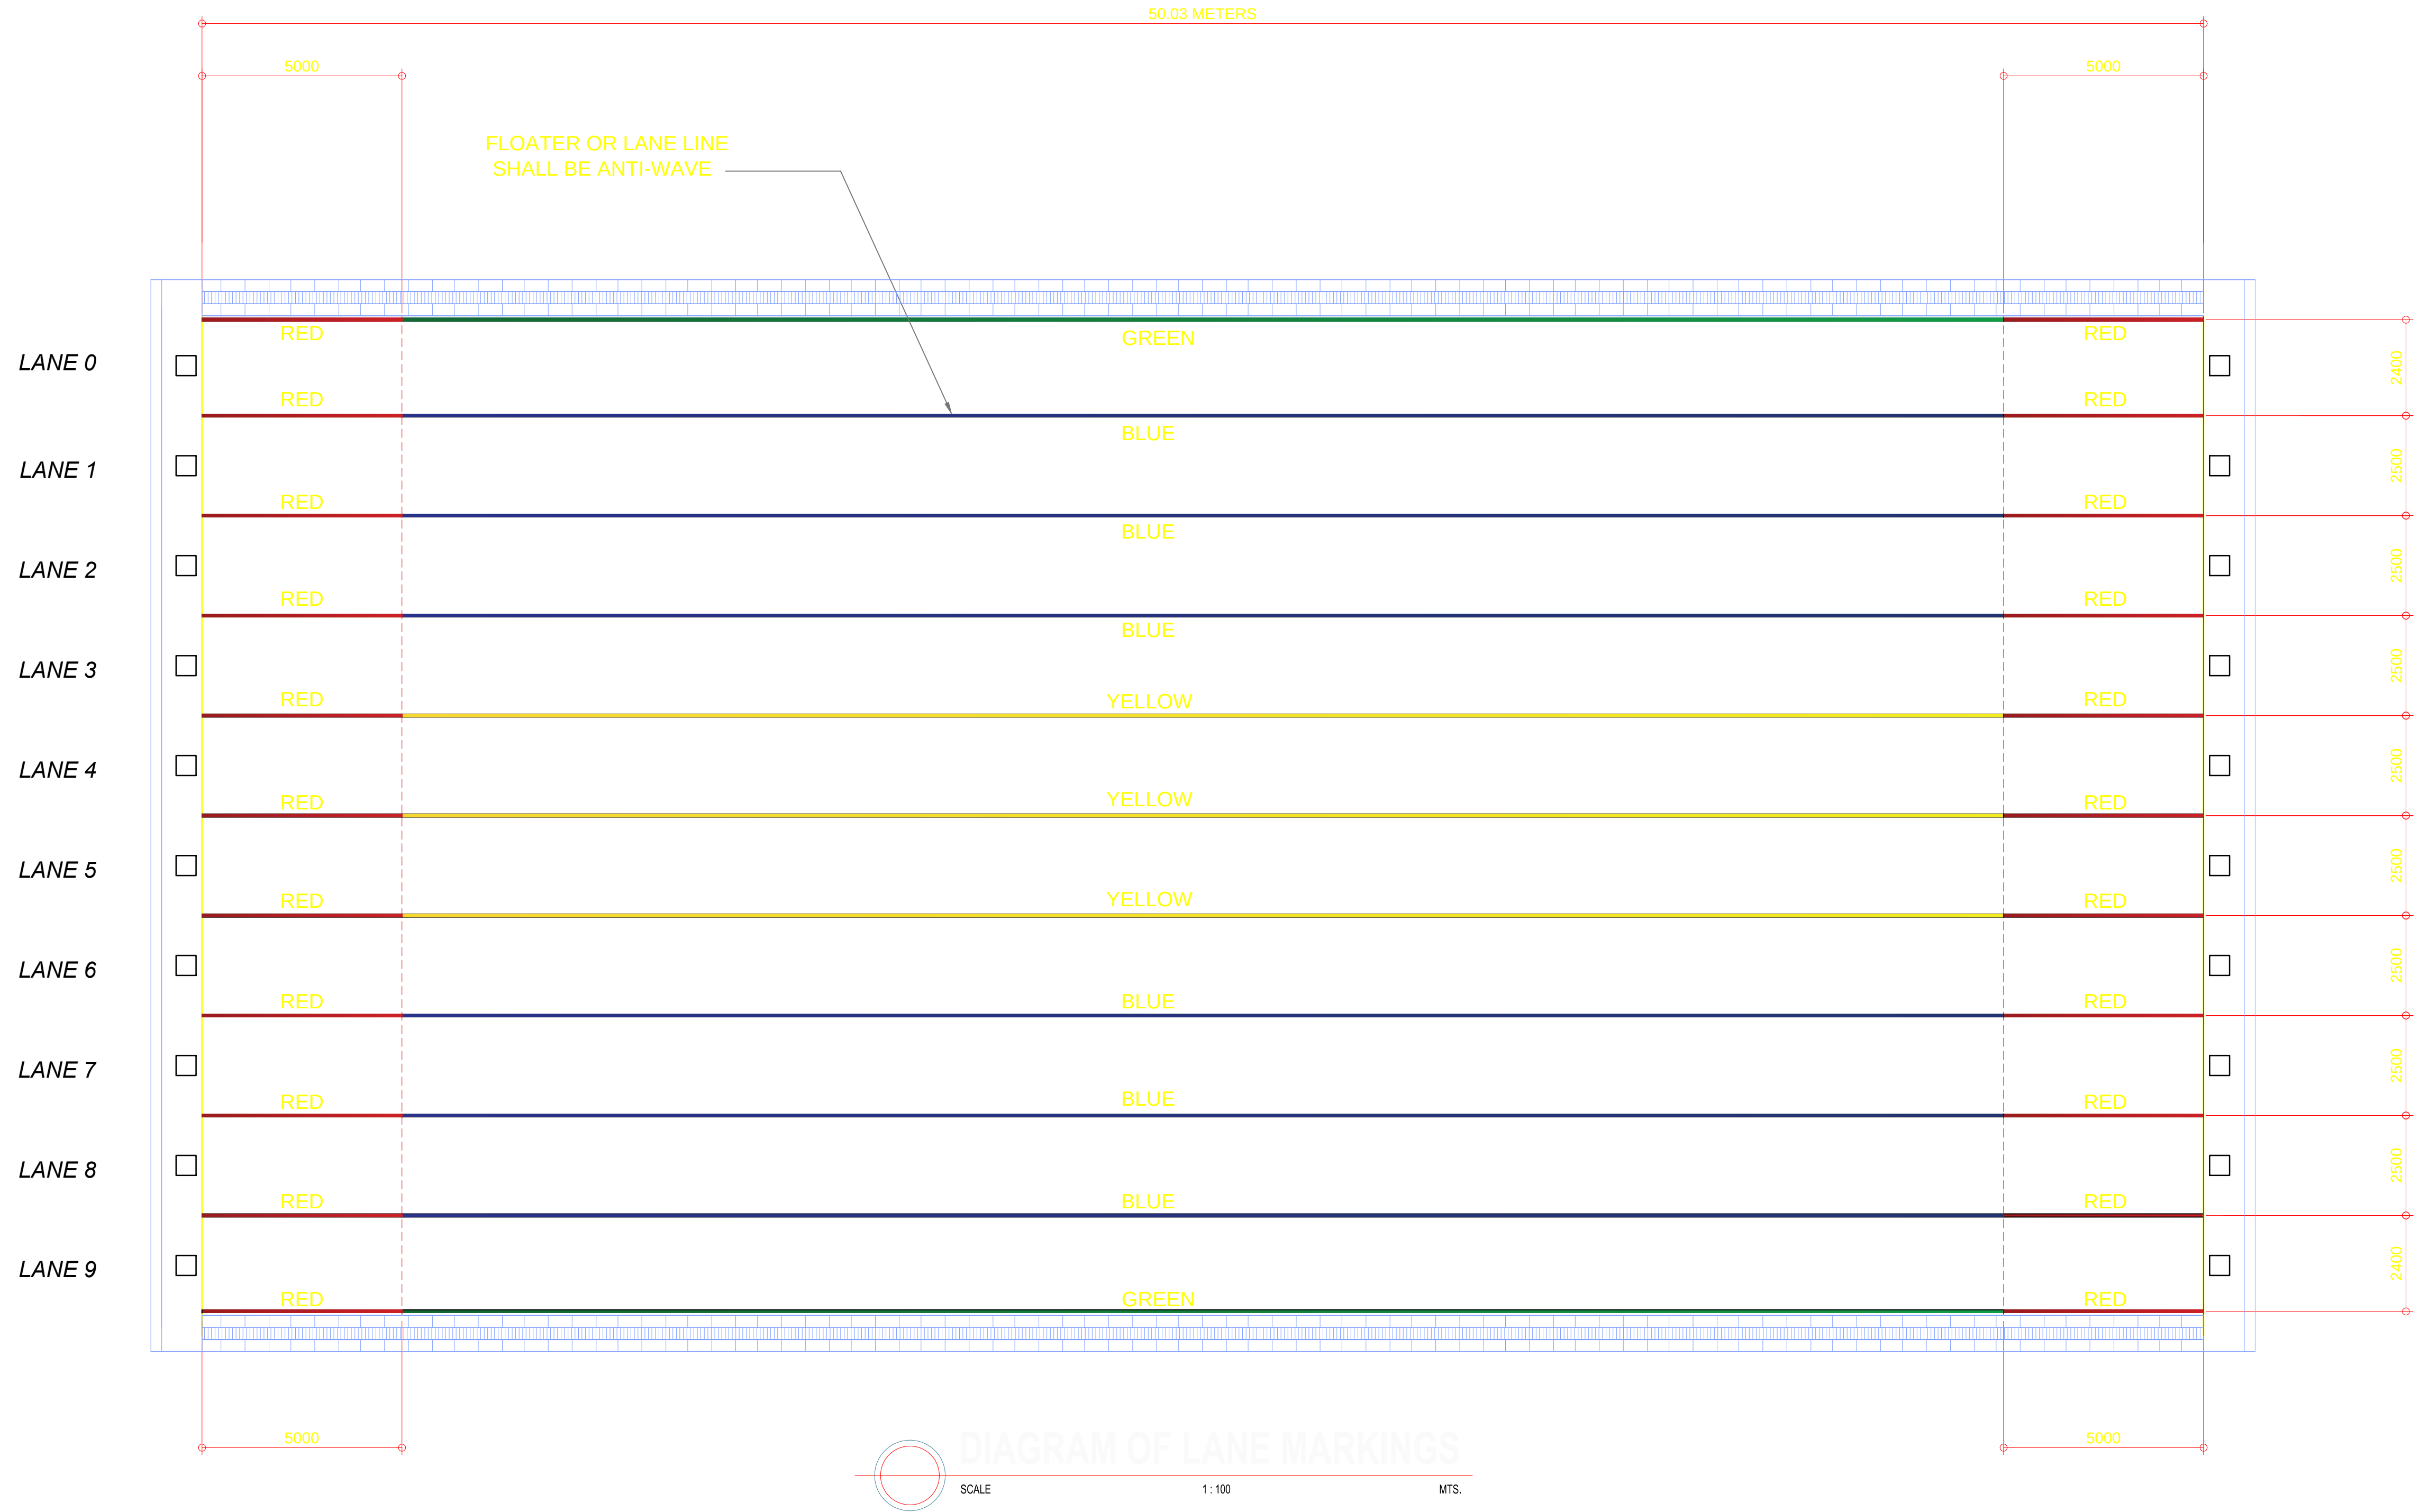


OWNER	PROJECT TITLE :	SUBMITTED BY :	RECOMMENDING APPROVAL :	APPROVED BY :	SHEET CONTENTS :	DESIGN BY :		SHEET NO :
 PHILIPPINE SPORTS COMMISSION RMSG, PABLO OCAMPO SR. ST., MALATE, MANILA	UPGRADING OF SWIMMING POOL, DIVING POOL, AND CONSTRUCTION OF NEW BLEACHERS, WARM UP POOL AND JACUZZI LOCATION: PHILSPORTS, ULTRA, MERALCO AVE., PASIG CITY	ENGR. PEDRO I. PINEDA JR. HEAD - ENGINEERING UNIT	DIR. MERLITA R. IBAY DEPUTY EXECUTIVE DIRECTOR	HON. WILLIAM I. RAMIREZ CHAIRMAN	AS SHOWN	DRAWN BY :		A12
						CHECKED BY :		
						DATE :		
						APPROVED BY :		

 
OWNER	PROJECT TITLE :	SUBMITTED BY :	RECOMMENDING APPROVAL :	APPROVED BY :	SHEET CONTENTS :	DESIGN BY :	SHEET NO :
 PHILIPPINE SPORTS COMMISSION RMSC, PABLO OCAMPO SR. ST., MALATE, MANILA	UPGRADING OF SWIMMING POOL, DIVING POOL, AND CONSTRUCTION OF NEW BLEACHERS, WARM UP POOL AND JACUZZI LOCATION: PHILSPORTS, ULTRA, MERALCO AVE., PASIG CITY	ENGR. PEDRO I. PINEDA JR. HEAD - ENGINEERING UNIT	DIR. MERLITA R. IBAY DEPUTY EXECUTIVE DIRECTOR	HON. WILLIAM I. RAMIREZ CHAIRMAN	AS SHOWN	DRAWN BY :	A 13
						CHECKED BY :	
						DATE :	
						APPROVED BY :	

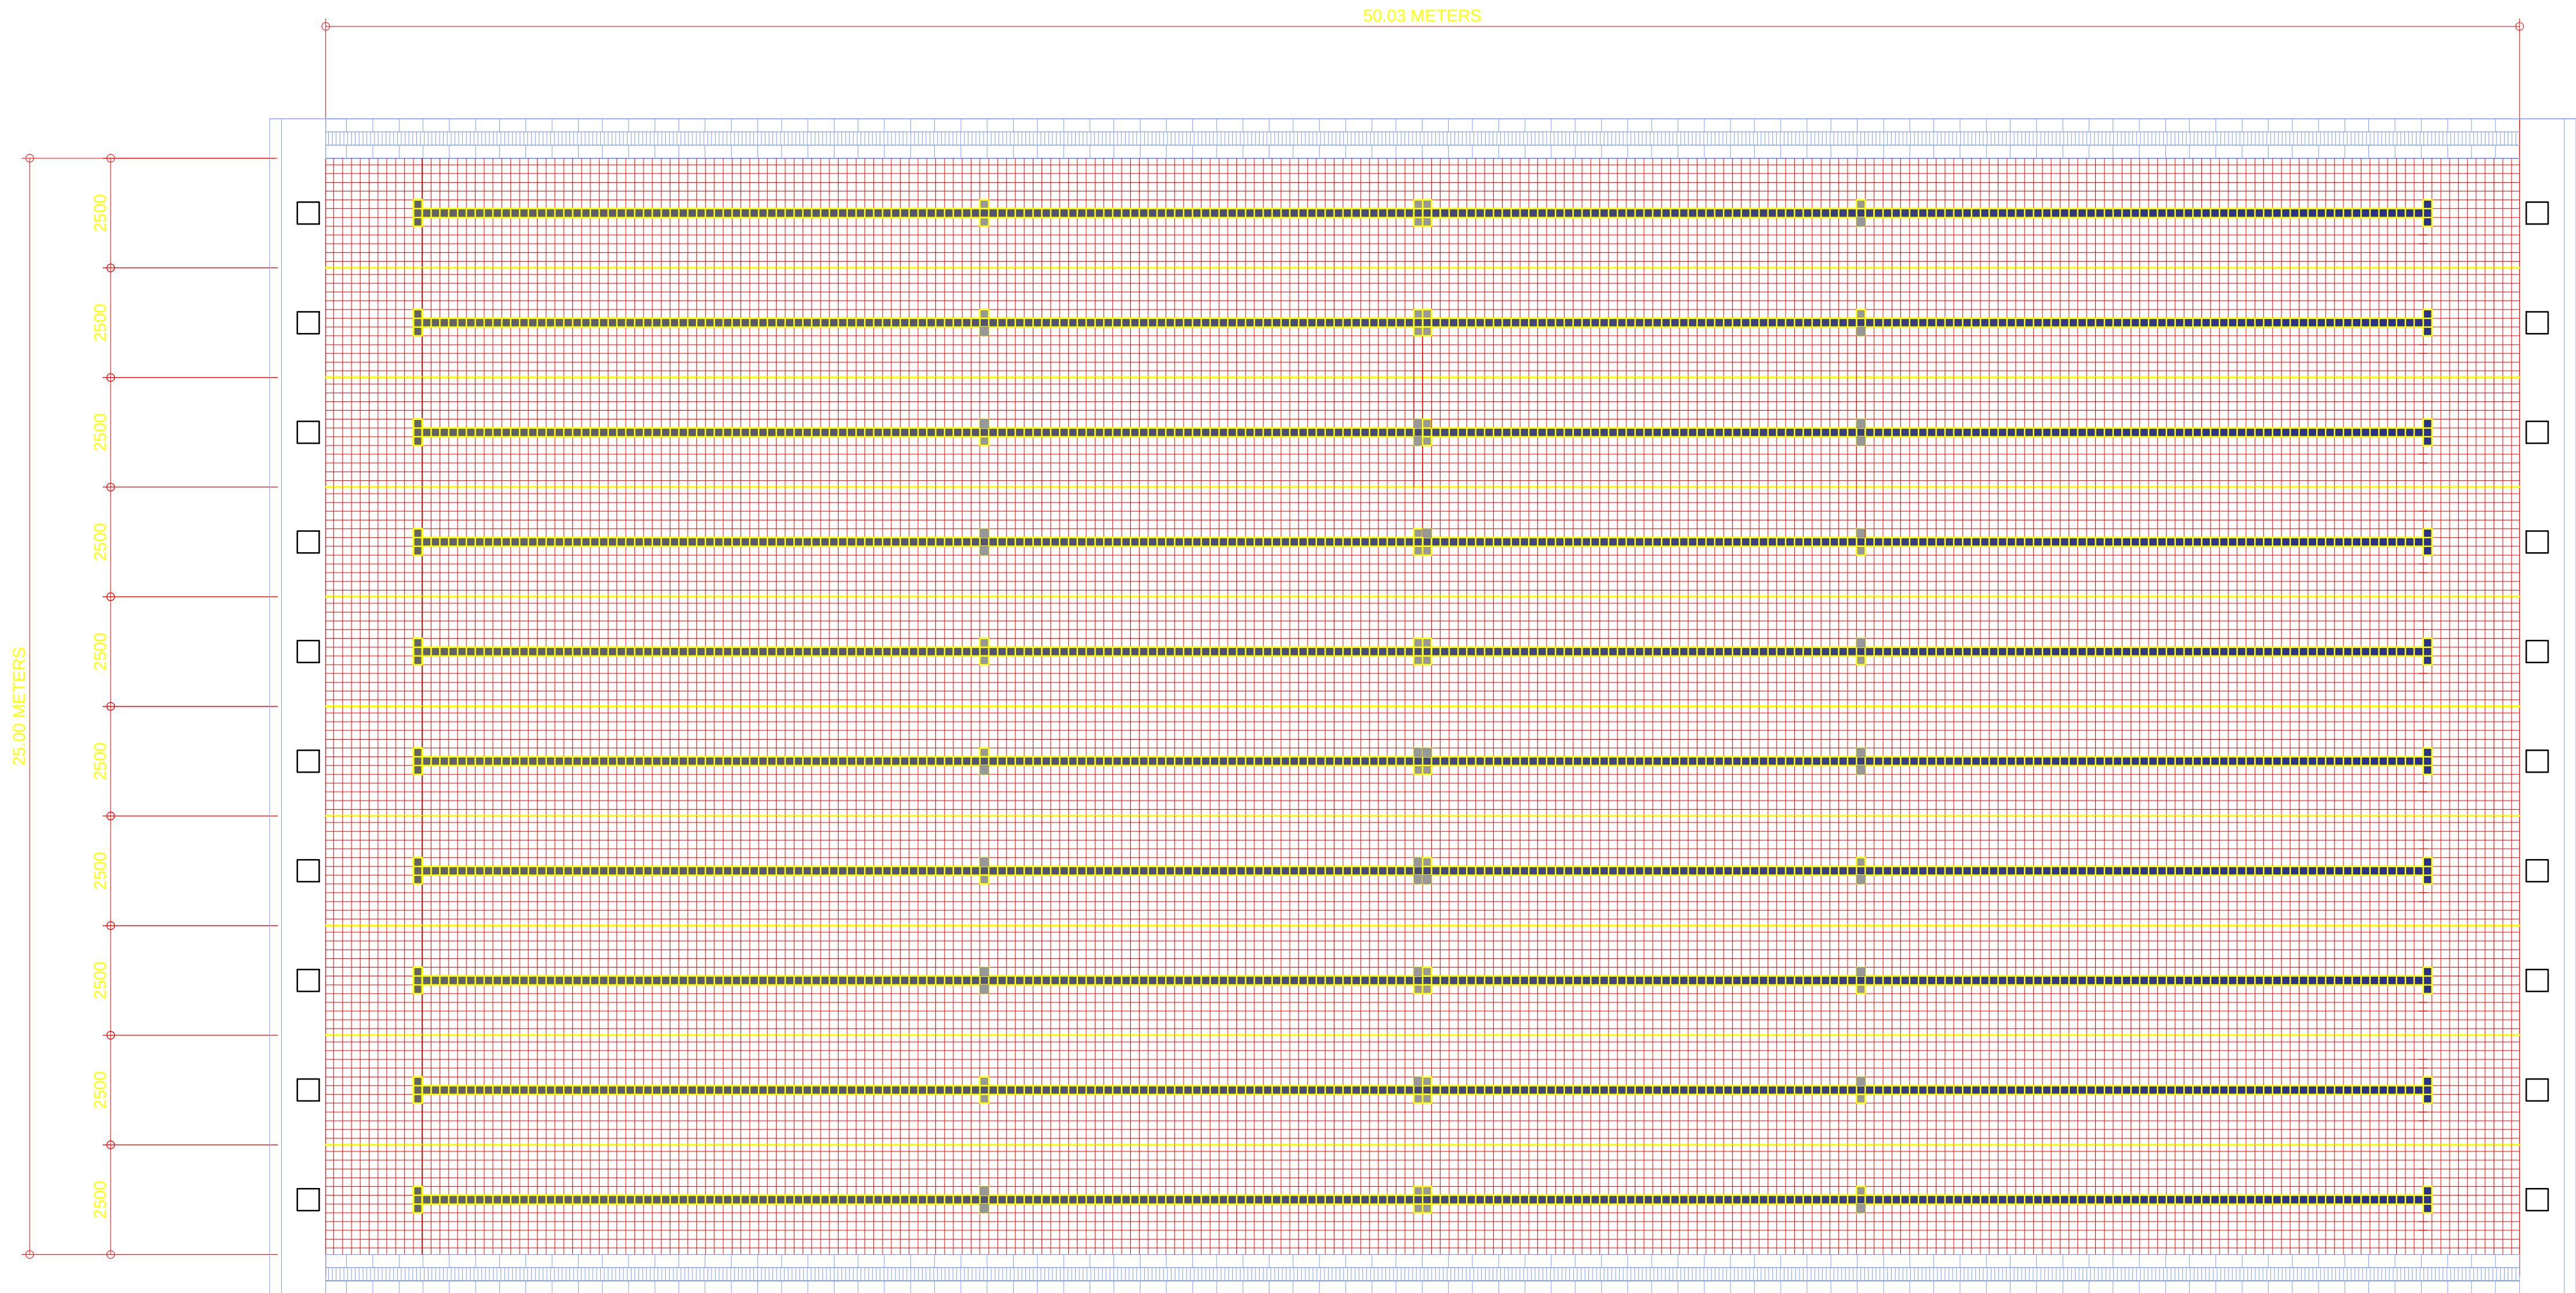



EXISTING LONGITUDINAL SECTION

 SCALE 1:100 MTS.

OWNER	PROJECT TITLE :	SUBMITTED BY :	RECOMMENDING APPROVAL :	APPROVED BY :	SHEET CONTENTS :	DESIGN BY :		SHEET NO :
 PHILIPPINE SPORTS COMMISSION RMSC, PABLO OCAMPO SR. ST., MALATE, MANILA	UPGRADING OF SWIMMING POOL, DIVING POOL, AND CONSTRUCTION OF NEW BLEACHERS, WARM UP POOL AND JACUZZI LOCATION: PHILSPORTS, ULTRA, MERALCO AVE., PASIG CITY	ENGR. PEDRO I. PINEDA JR. HEAD - ENGINEERING UNIT	DIR. MERLITA R. IBAY DEPUTY EXECUTIVE DIRECTOR	HON. WILLIAM I. RAMIREZ CHAIRMAN	AS SHOWN	DRAWN BY :		A 14
						CHECKED BY :		
						DATE :		
						APPROVED BY :		

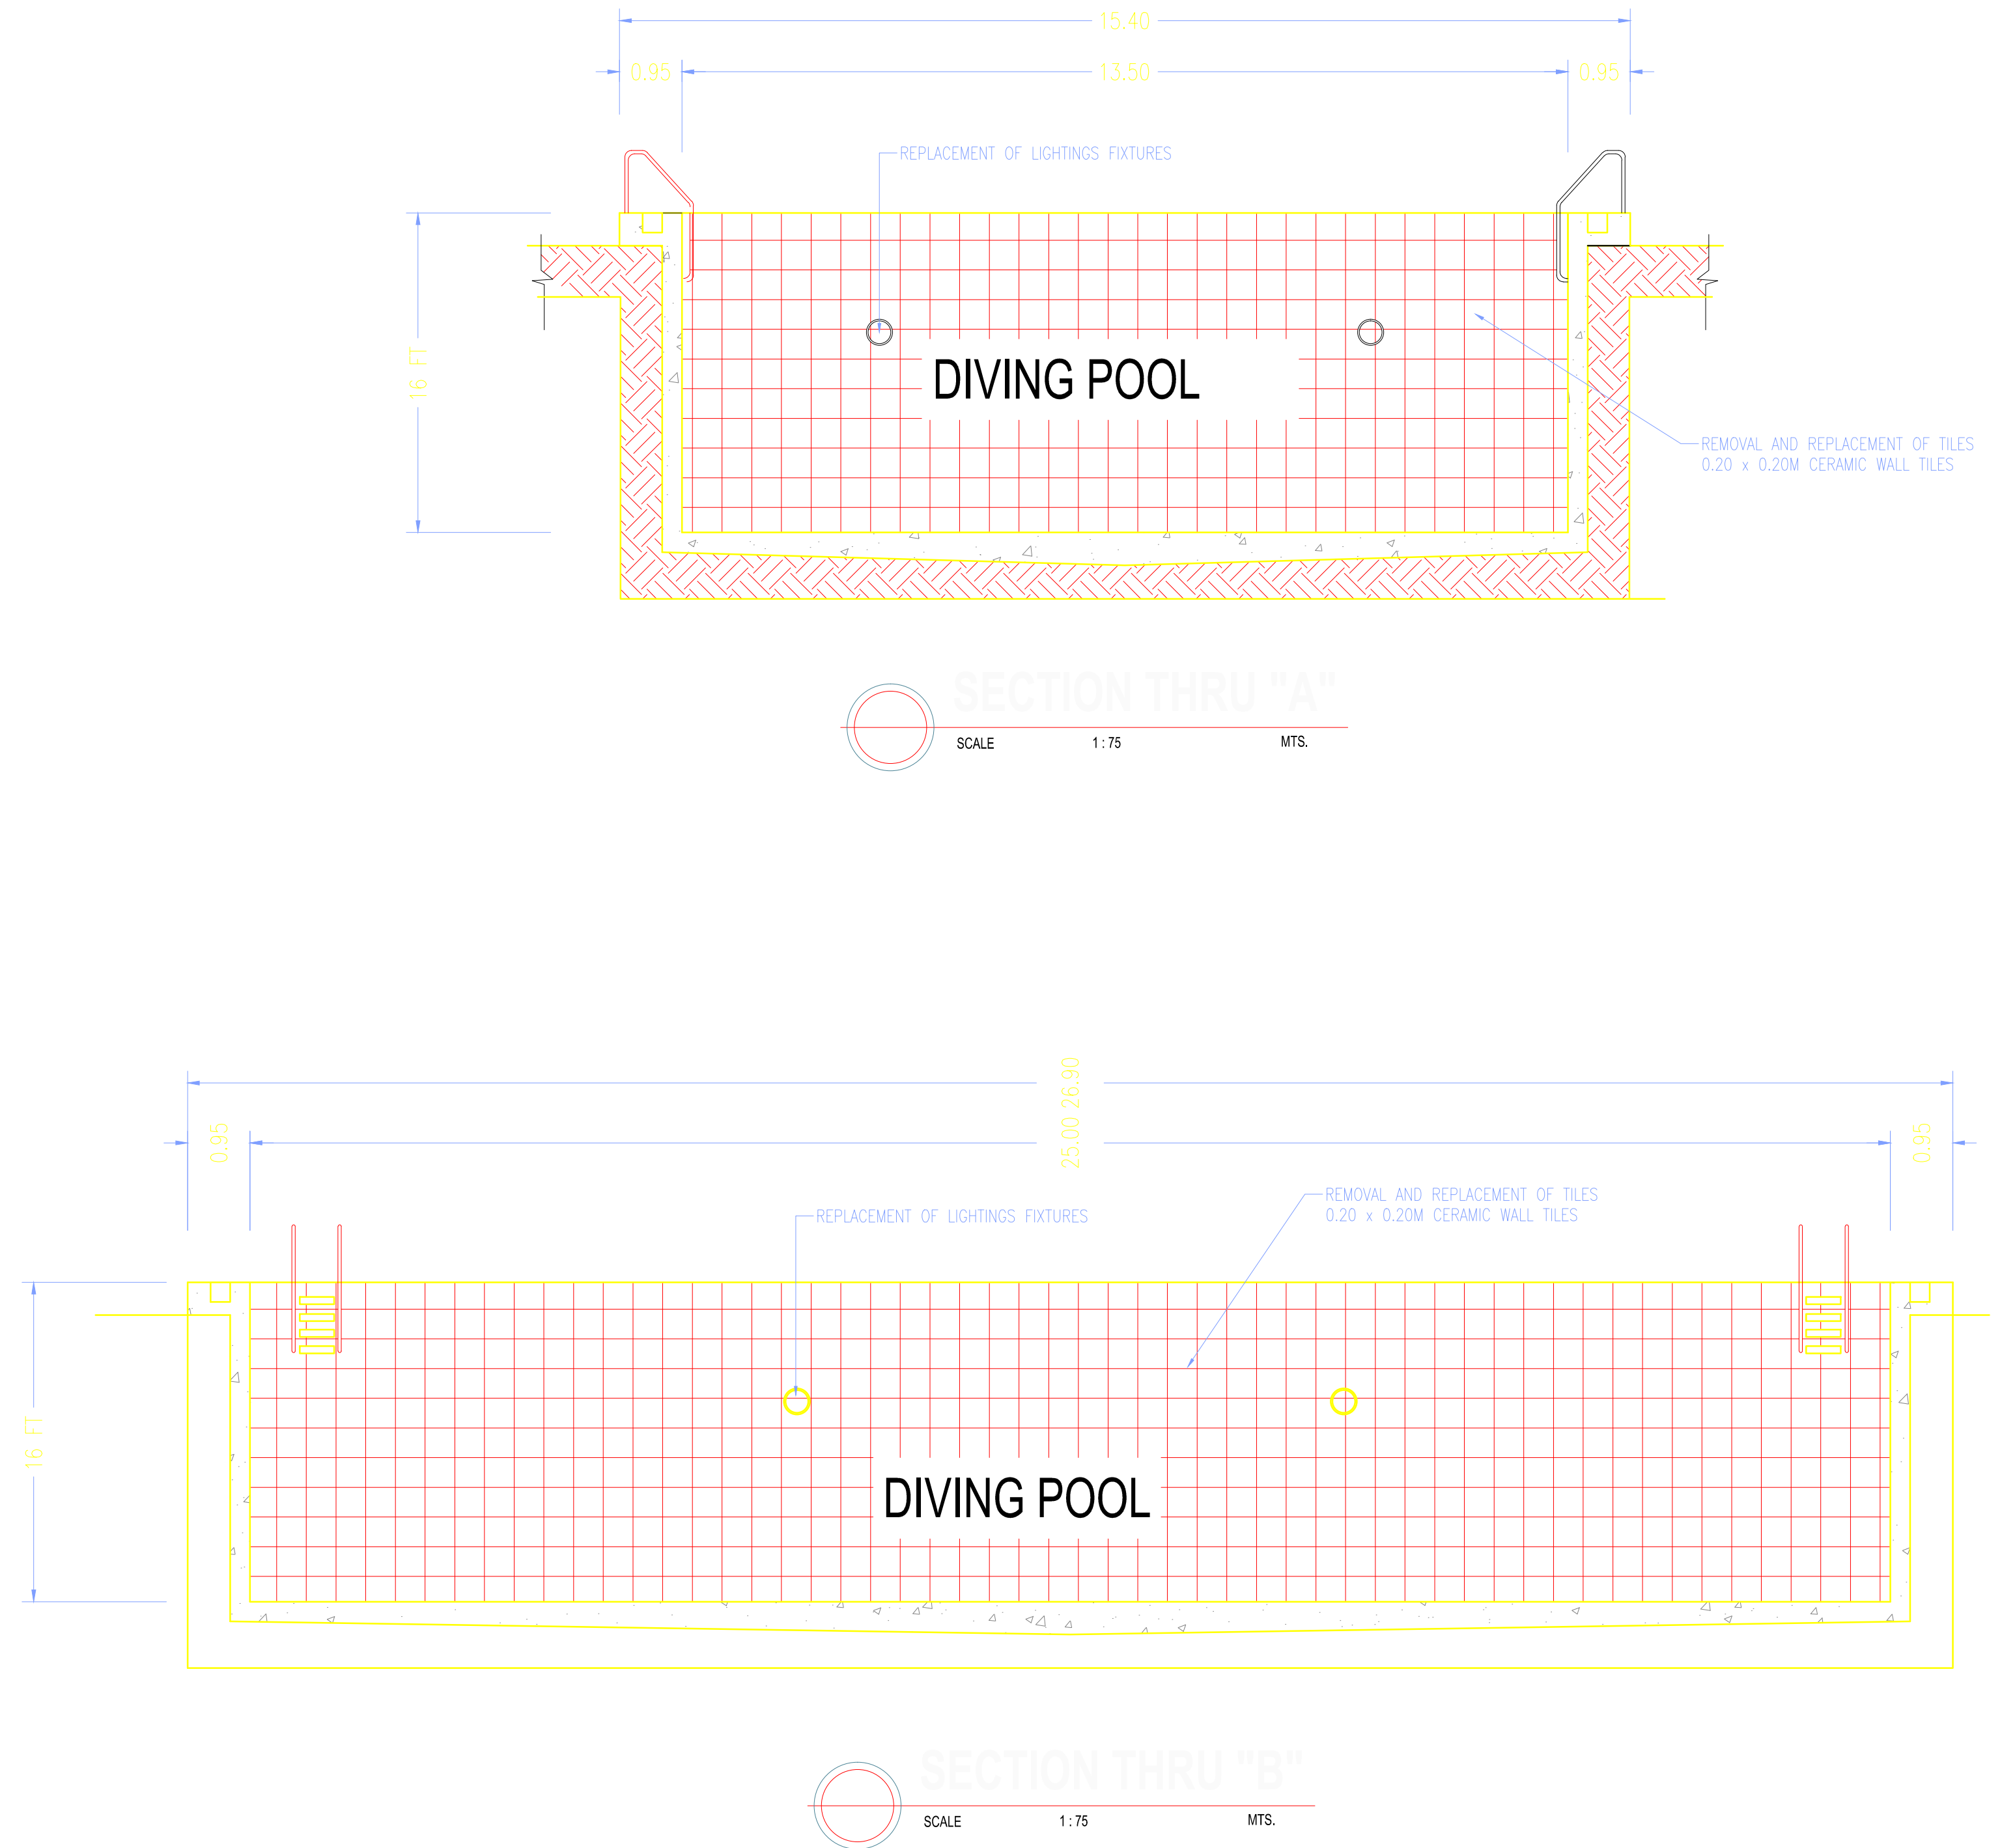


 OWNER	PROJECT TITLE :	SUBMITTED BY :	RECOMMENDING APPROVAL :	APPROVED BY :	SHEET CONTENTS :	DESIGN BY :	SHEET NO :
 PHILIPPINE SPORTS COMMISSION RMSC, PABLO OCAMPO SR. ST., MALATE, MANILA	UPGRADING OF SWIMMING POOL, DIVING POOL, AND CONSTRUCTION OF NEW BLEACHERS, WARM UP POOL AND JACUZZI LOCATION: PHILSPORTS, ULTRA, MERALCO AVE., PASIG CITY	ENGR. PEDRO I. PINEDA JR. HEAD - ENGINEERING UNIT	DIR. MERLITA R. IBAY DEPUTY EXECUTIVE DIRECTOR	HON. WILLIAM I. RAMIREZ CHAIRMAN	AS SHOWN	DRAWN BY :	A 15
						CHECKED BY :	
						DATE :	
						APPROVED BY :	

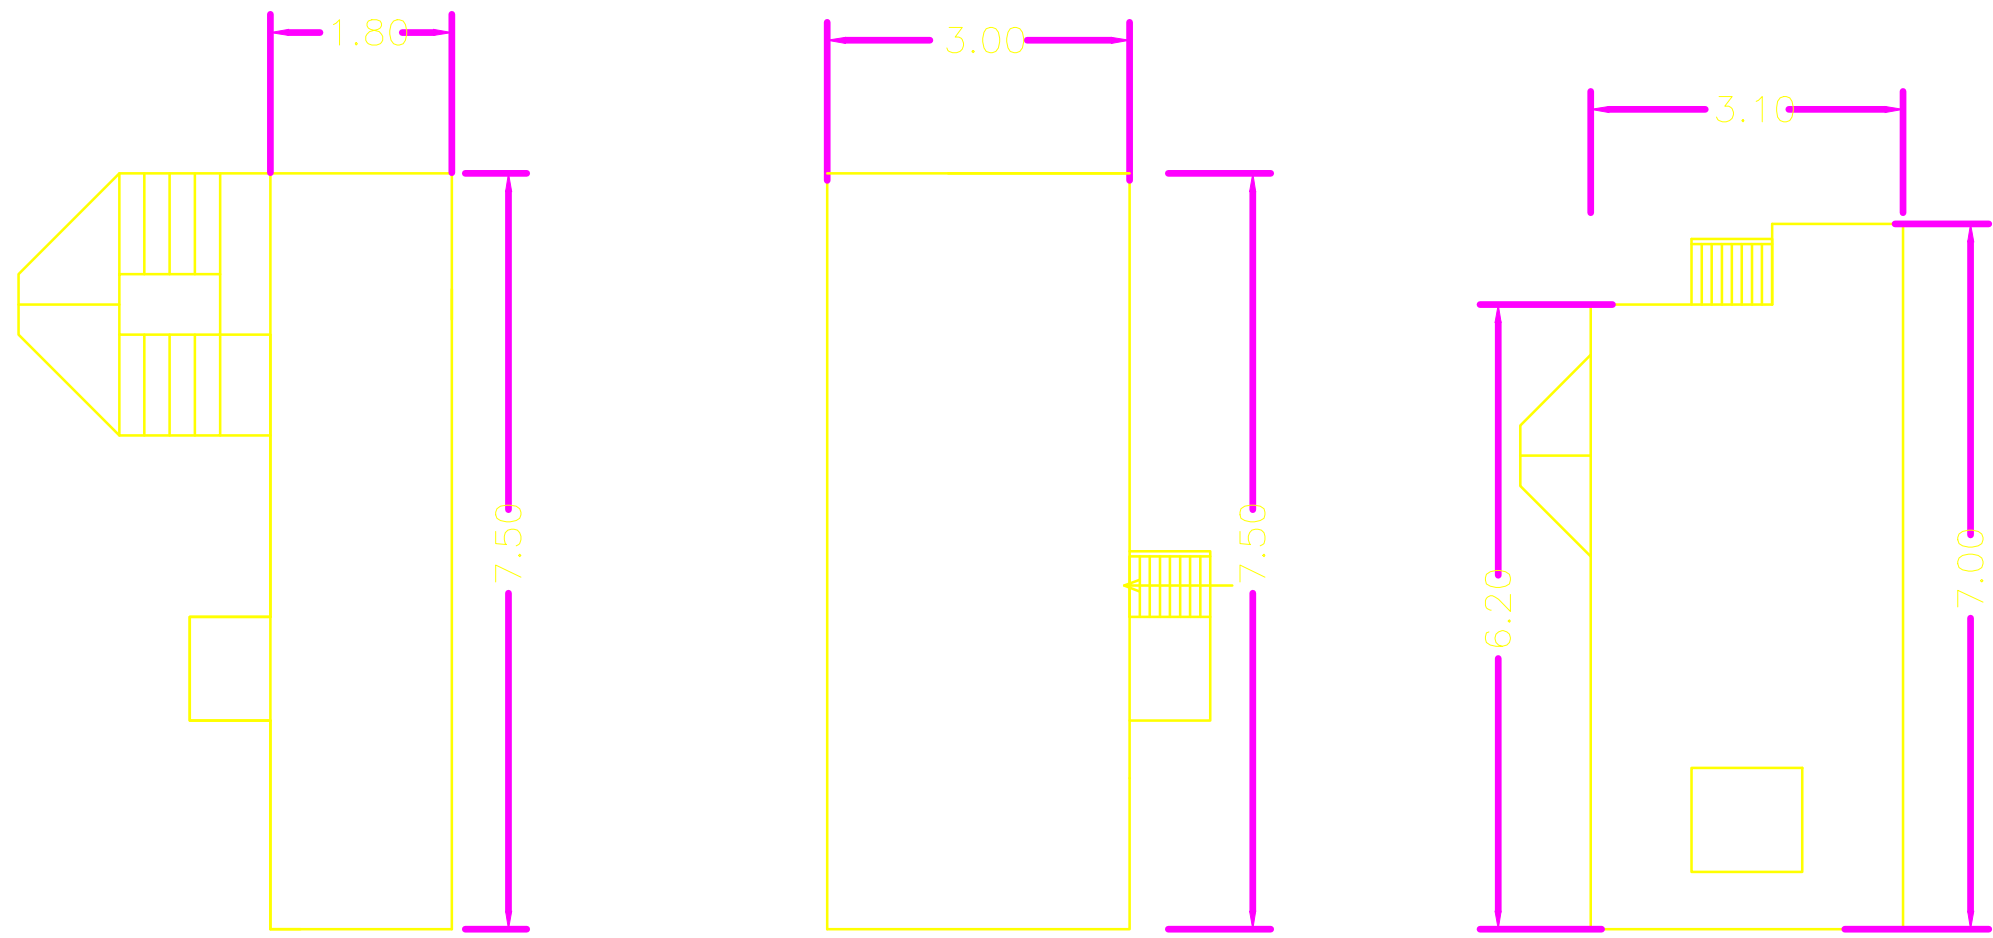


FIRST LEVEL @ 5.00 M SECOND LEVEL @ 7.50 M THIRD LEVEL @ 10.00 M

PLAN OF DIVING PLATFORM
SCALE 1:75 MTS.

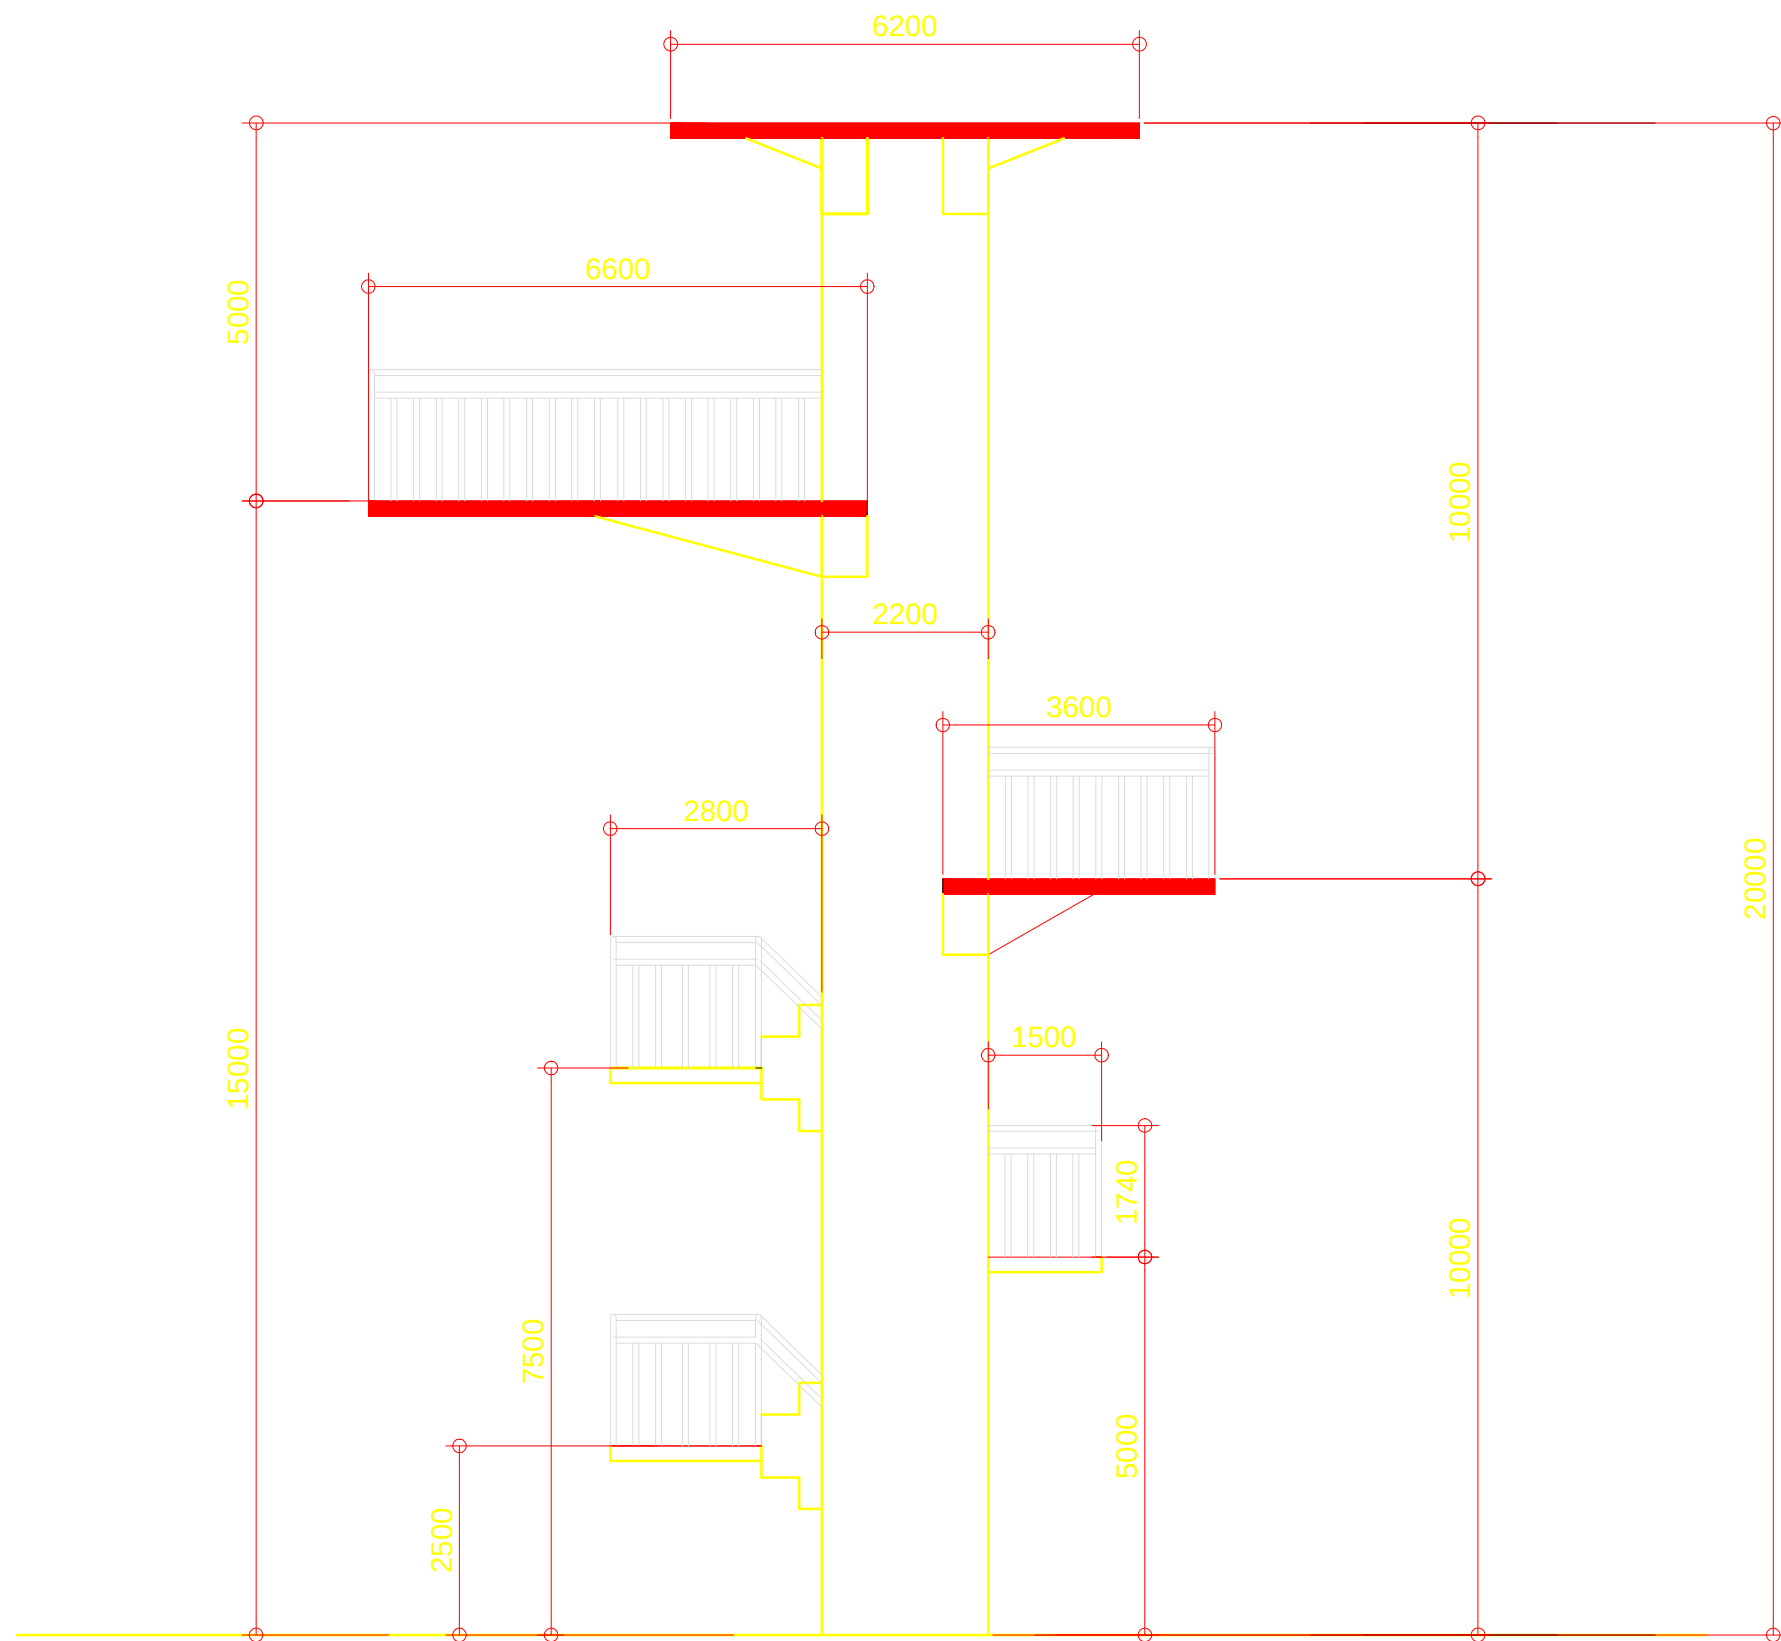


DIVING PLATFORM
FRONT ELEVATION
SCALE 1:200 MTS.

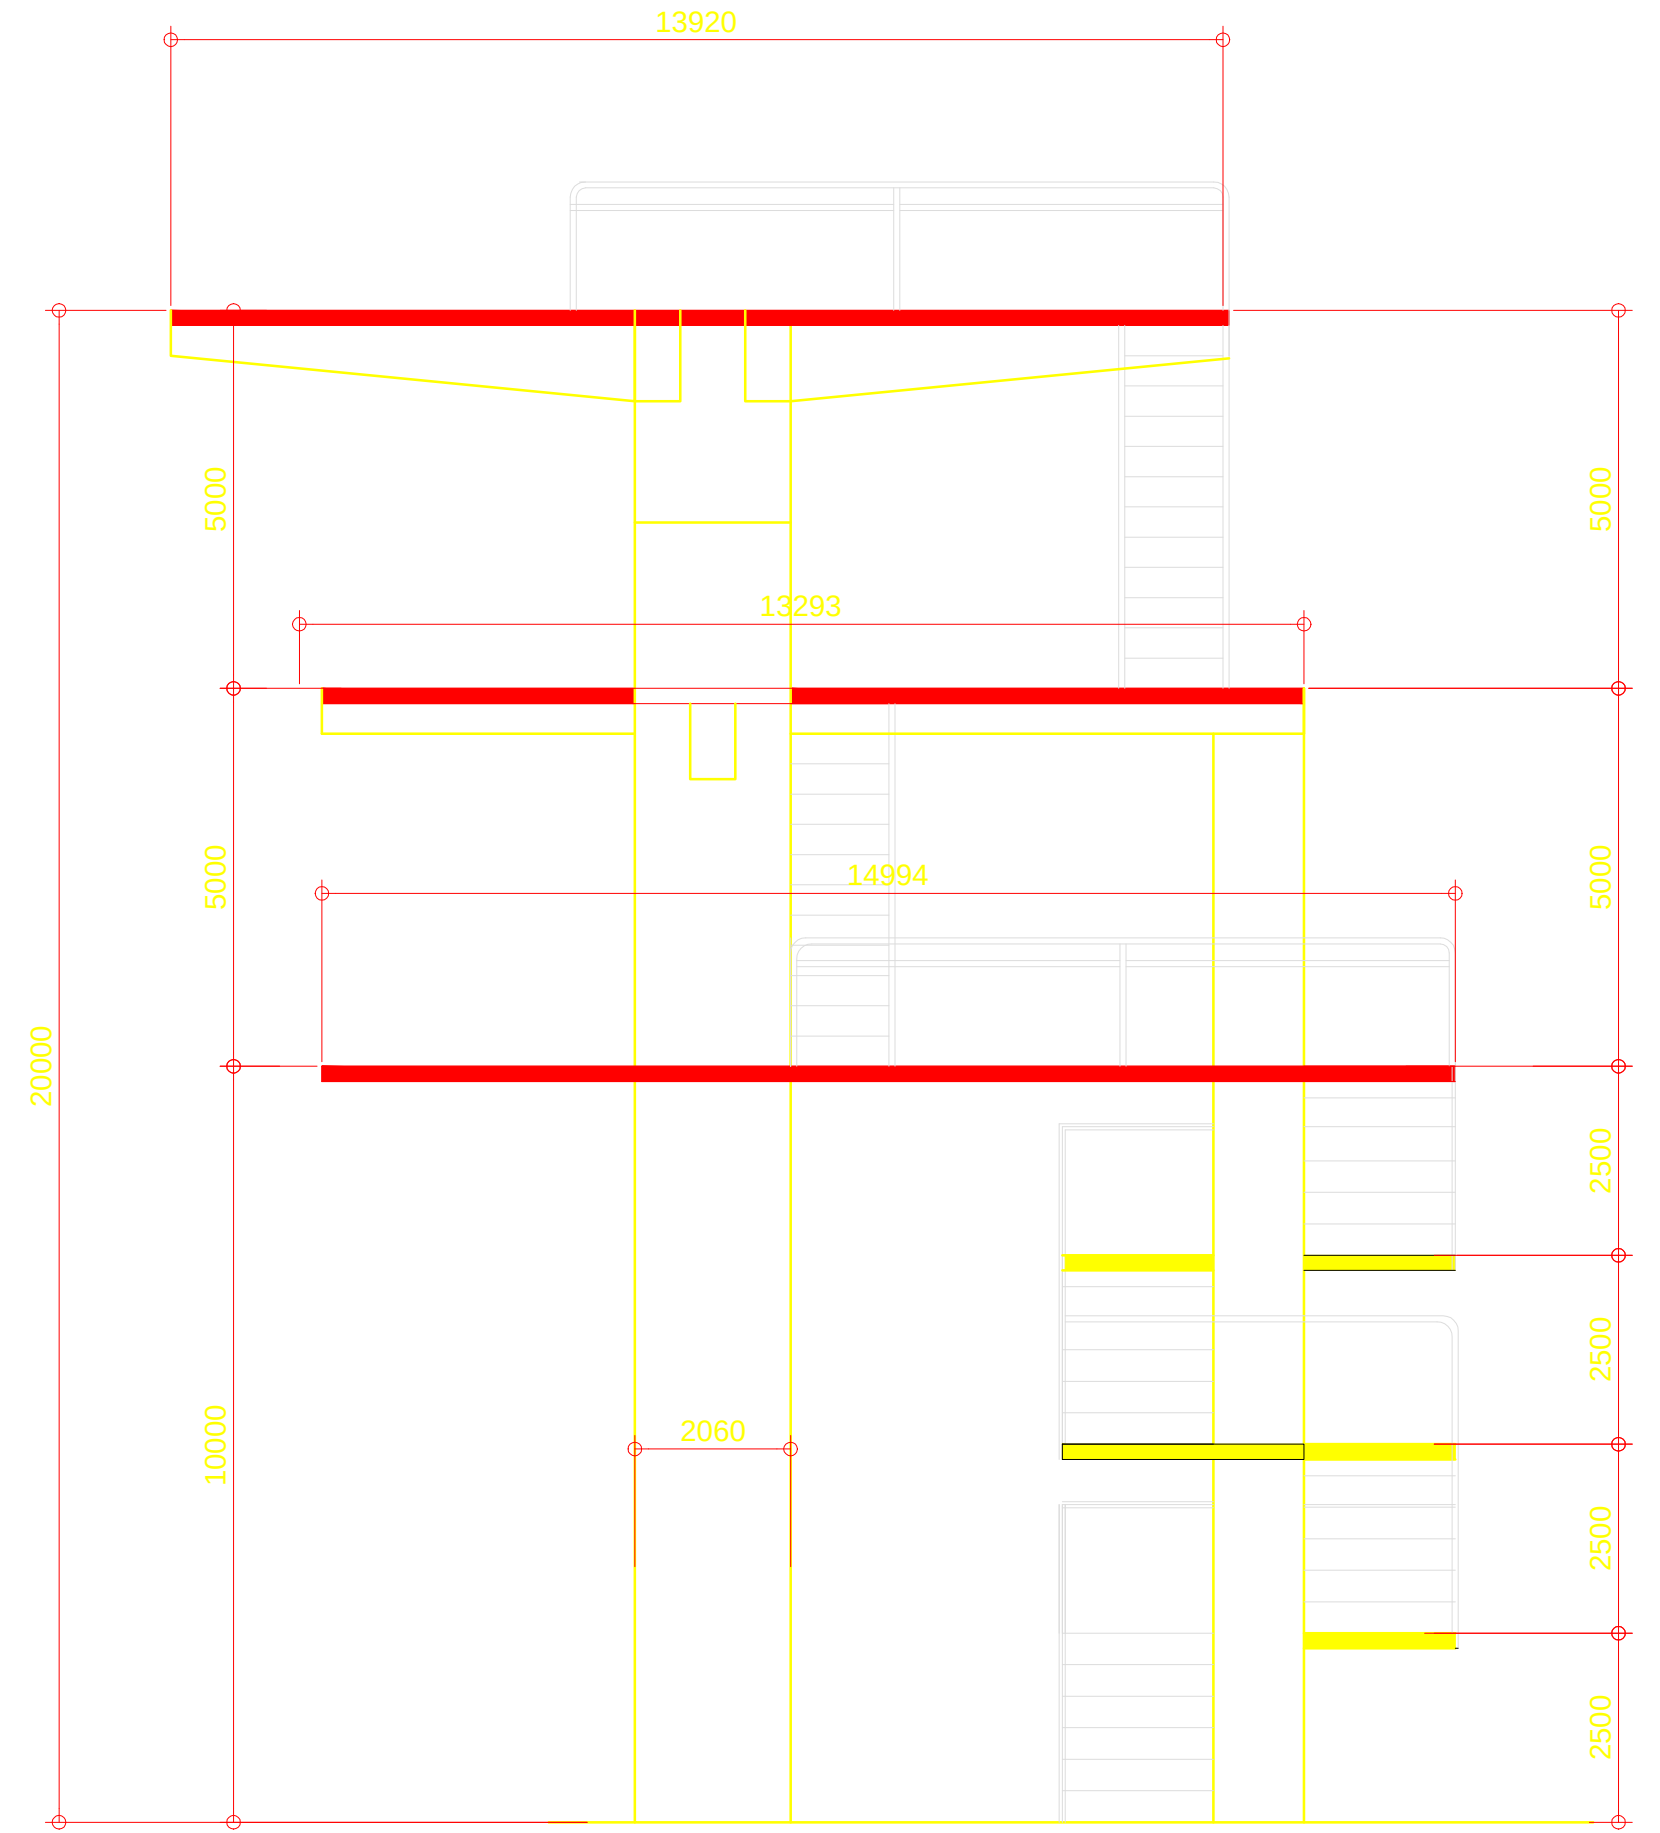


DIVING PLATFORM
SIDE ELEVATION
SCALE 1:200 MTS.


OWNER	PROJECT TITLE :	SUBMITTED BY :	RECOMMENDING APPROVAL :	APPROVED BY :	SHEET CONTENTS :	DESIGN BY :		SHEET NO :
 PHILIPPINE SPORTS COMMISSION RMSG, PABLO OCAMPO SR. ST., MALATE, MANILA	UPGRADING OF SWIMMING POOL, DIVING POOL, AND CONSTRUCTION OF NEW BLEACHERS, WARM UP POOL AND JACUZZI LOCATION: PHILSPORTS, ULTRA, MERALCO AVE., PASIG CITY	ENGR. PEDRO I. PINEDA JR. HEAD - ENGINEERING UNIT	DIR. MERLITA R. IBAY DEPUTY EXECUTIVE DIRECTOR	HON. WILLIAM I. RAMIREZ CHAIRMAN	AS SHOWN	DRAWN BY :		A 16
						CHECKED BY :		
						DATE :		
						APPROVED BY :		

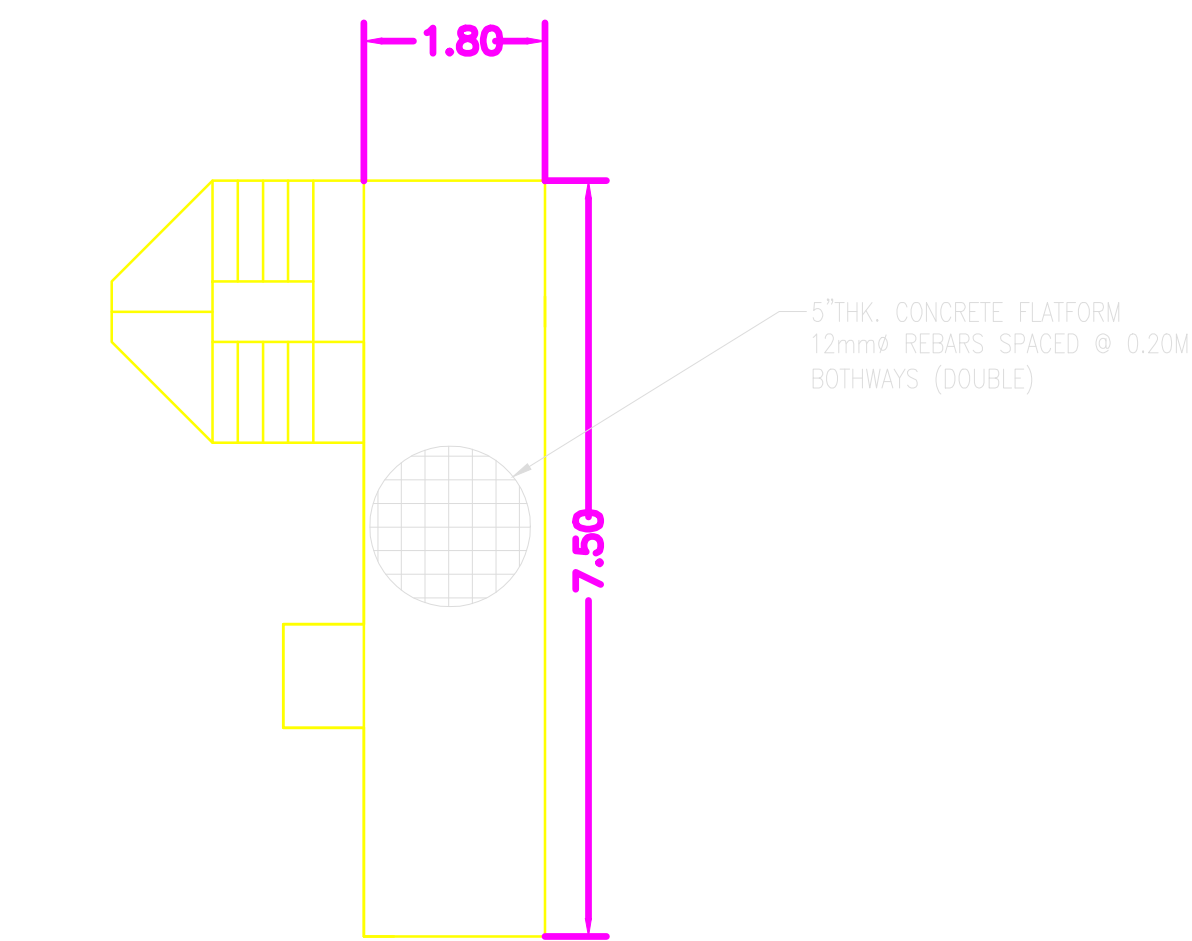


FIRST LEVEL @ 5.00M

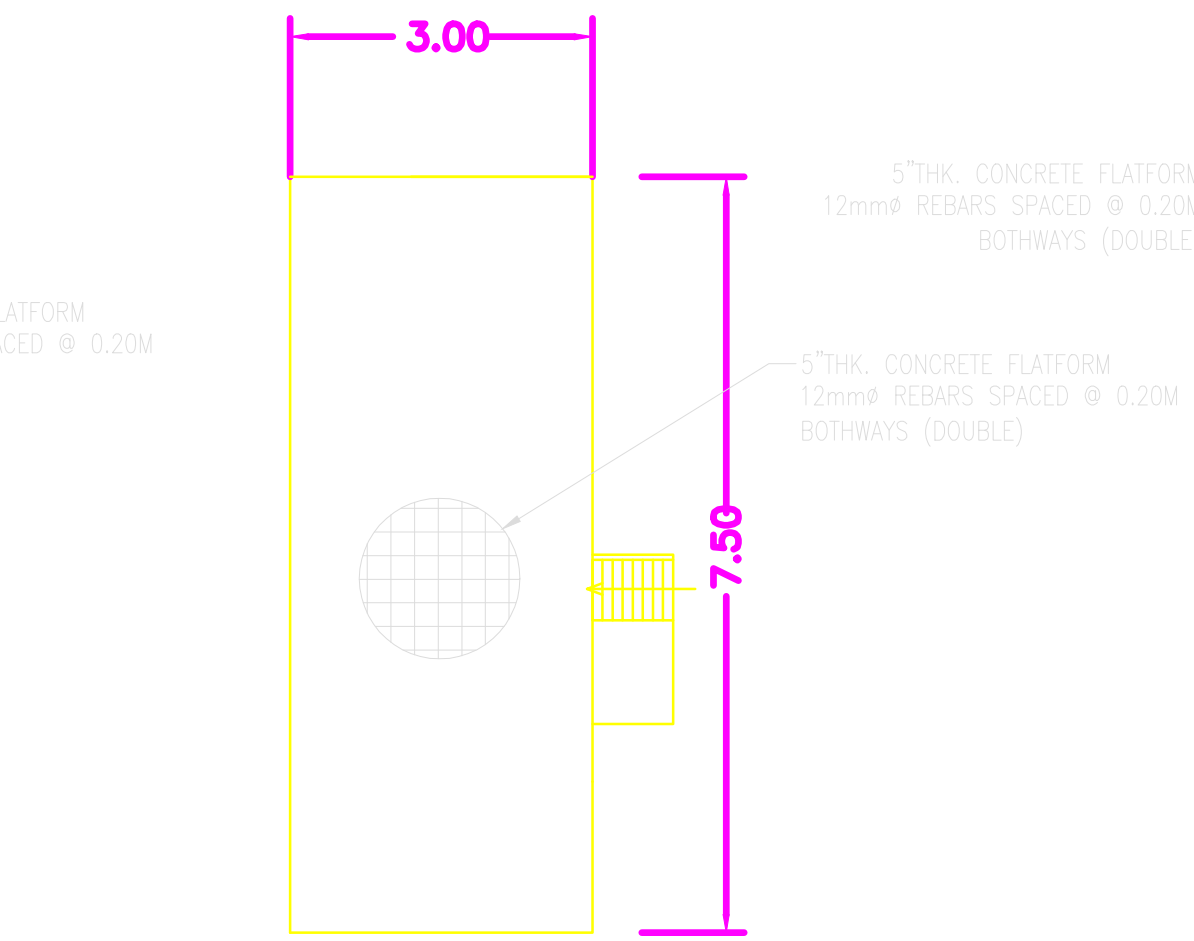


SECOND LEVEL @ 7.50M

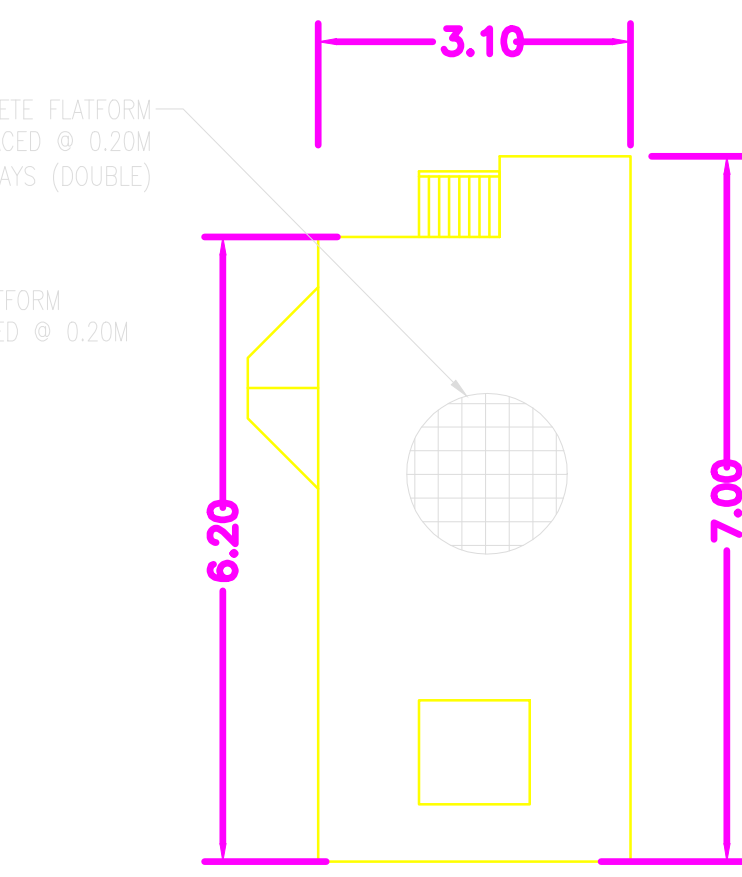


THIRD LEVEL @ 10.00M

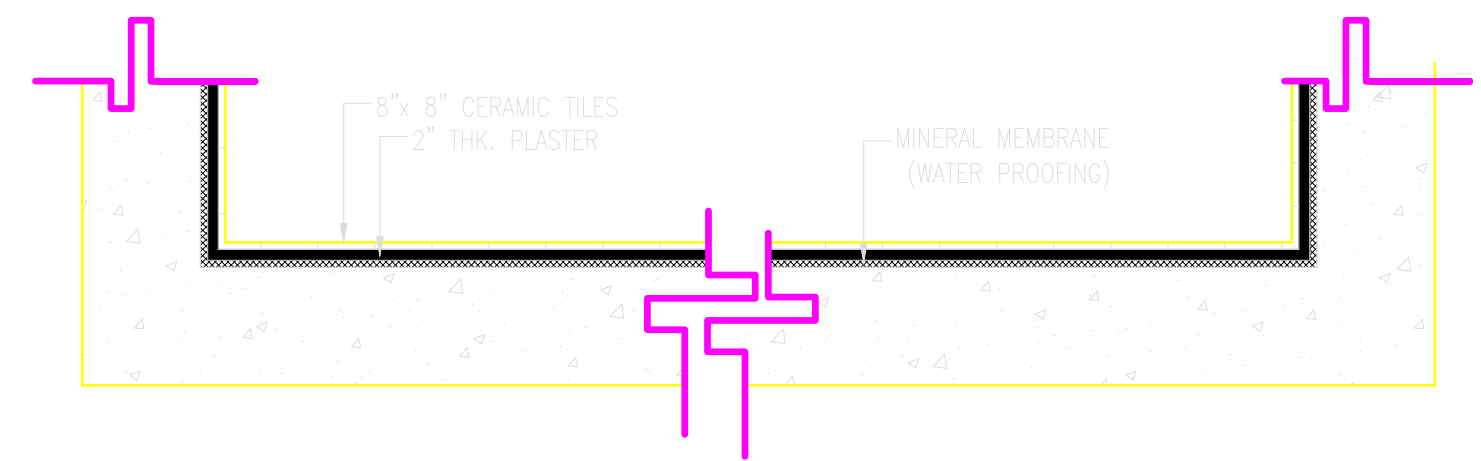



DIVING POOL FLOOR DETAILS

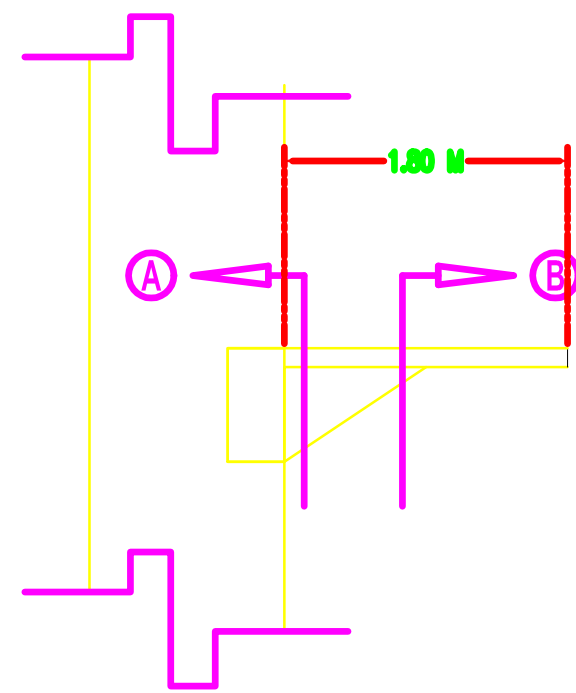


DETAILS OF 'B-3'

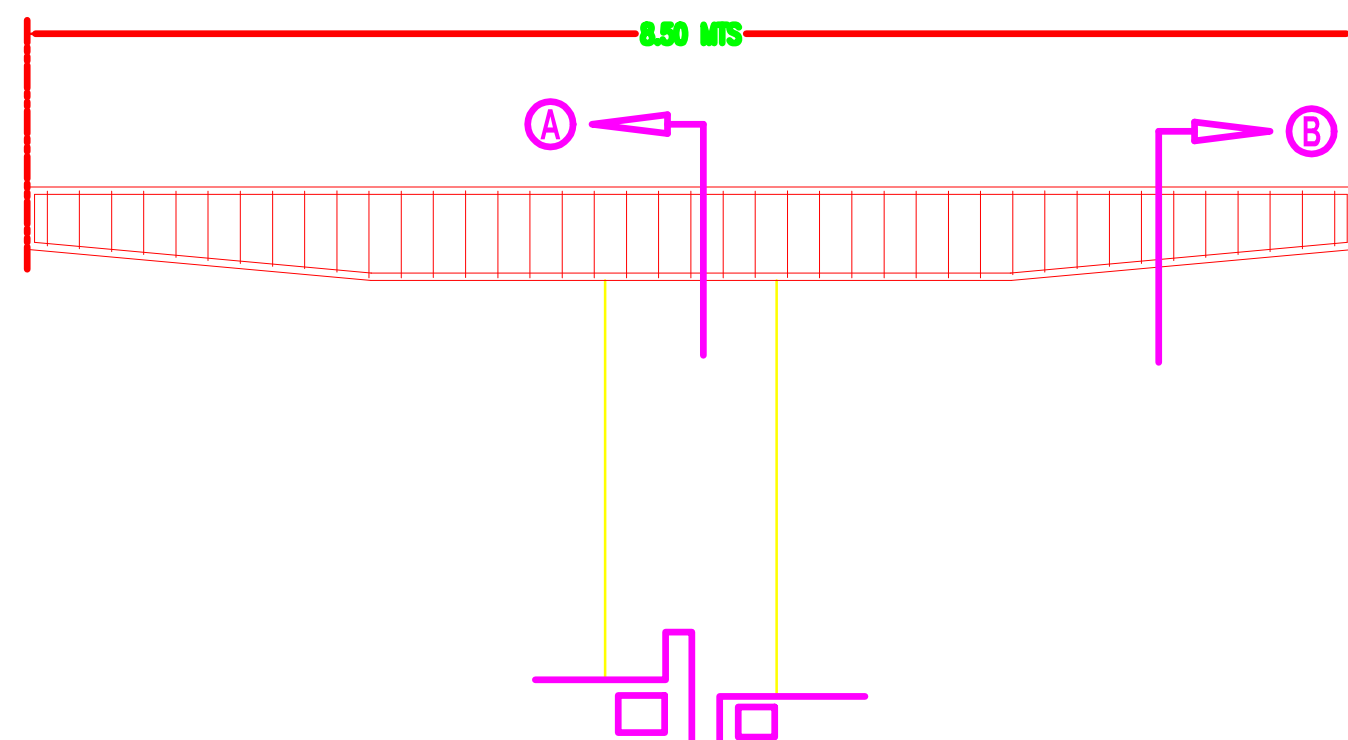


DETAILS OF 'B-4'

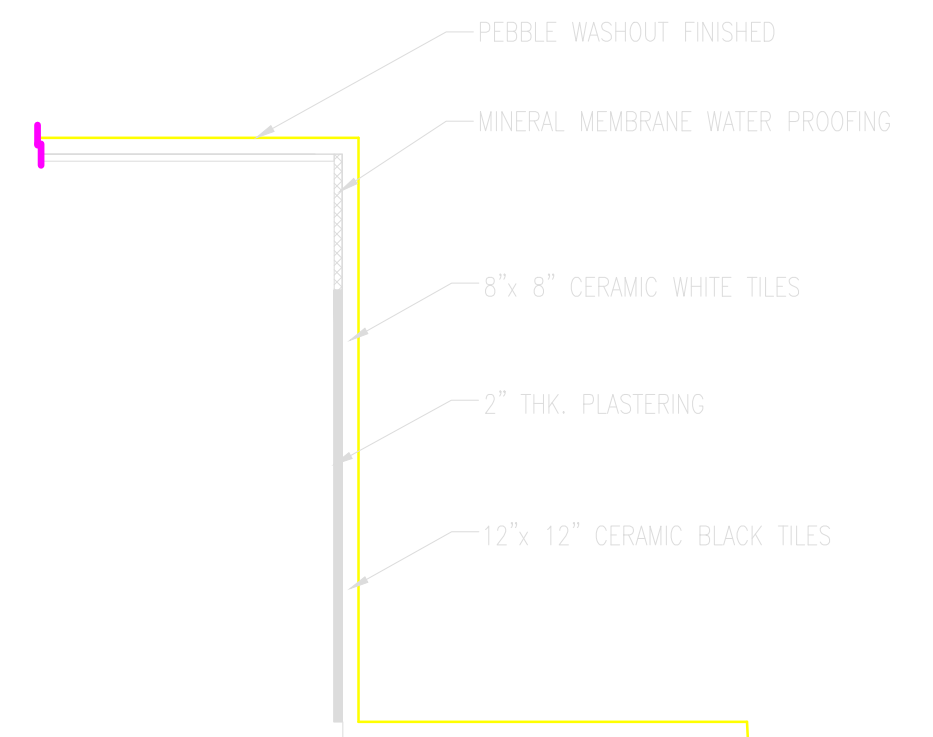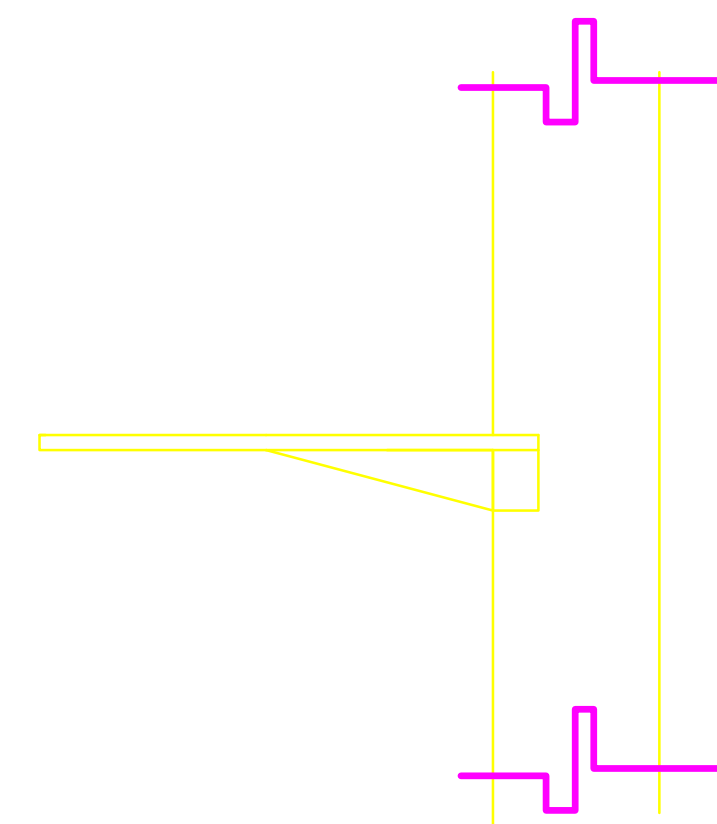


DIVING POOL DETAIL OF END WALL

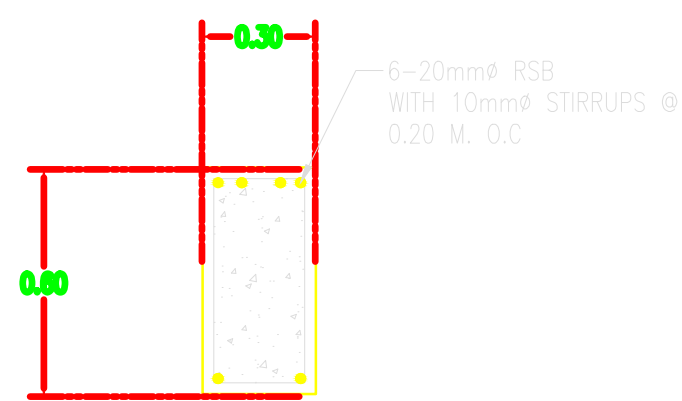


DETAILS @ 'A'

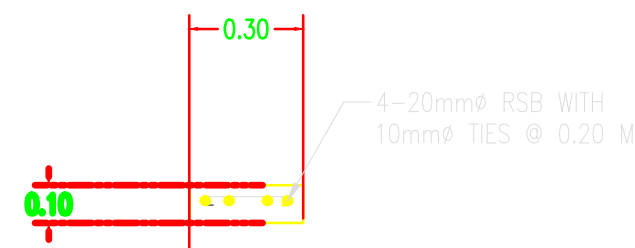


DETAILS @ 'B'

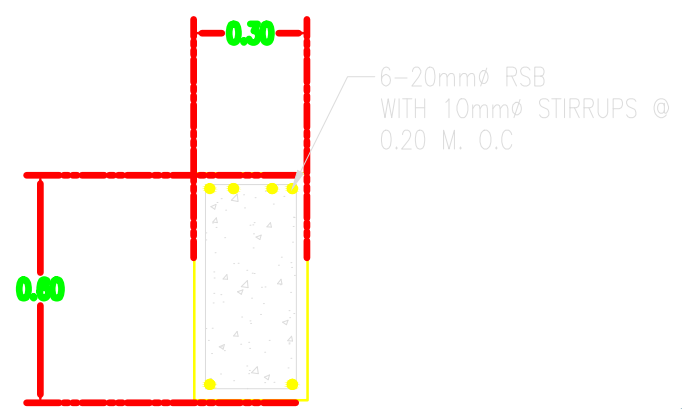


DETAILS @ 'A'

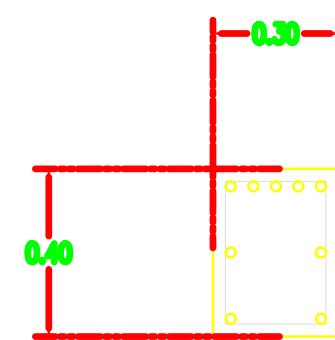

DETAILS @ 'B'

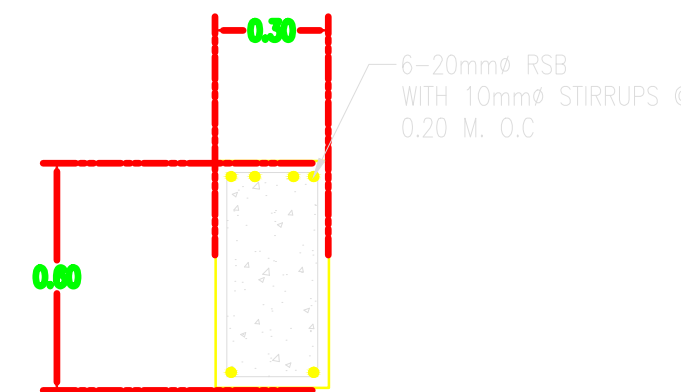


DETAILS @ 'A'

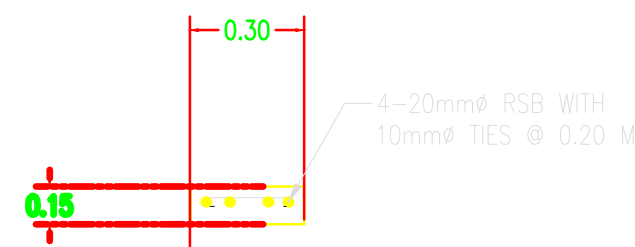


DETAILS @ 'B'

OWNER	PROJECT TITLE :	SUBMITTED BY :	RECOMMENDING APPROVAL :	APPROVED BY :	SHEET CONTENTS :	DESIGN BY :		SHEET NO :
 PHILIPPINE SPORTS COMMISSION RMSC, PABLO OCAMPO SR. ST., MALATE, MANILA	UPGRADING OF SWIMMING POOL, DIVING POOL, AND CONSTRUCTION OF NEW BLEACHERS, WARM UP POOL AND JACUZZI LOCATION: PHILSPORTS, ULTRA, MERALCO AVE., PASIG CITY	ENGR. PEDRO I. PINEDA JR. HEAD - ENGINEERING UNIT	DIR. MERLITA R. IBAY DEPUTY EXECUTIVE DIRECTOR	HON. WILLIAM I. RAMIREZ CHAIRMAN	AS SHOWN	DRAWN BY :		A 17
						CHECKED BY :		
						DATE :		
						APPROVED BY :		

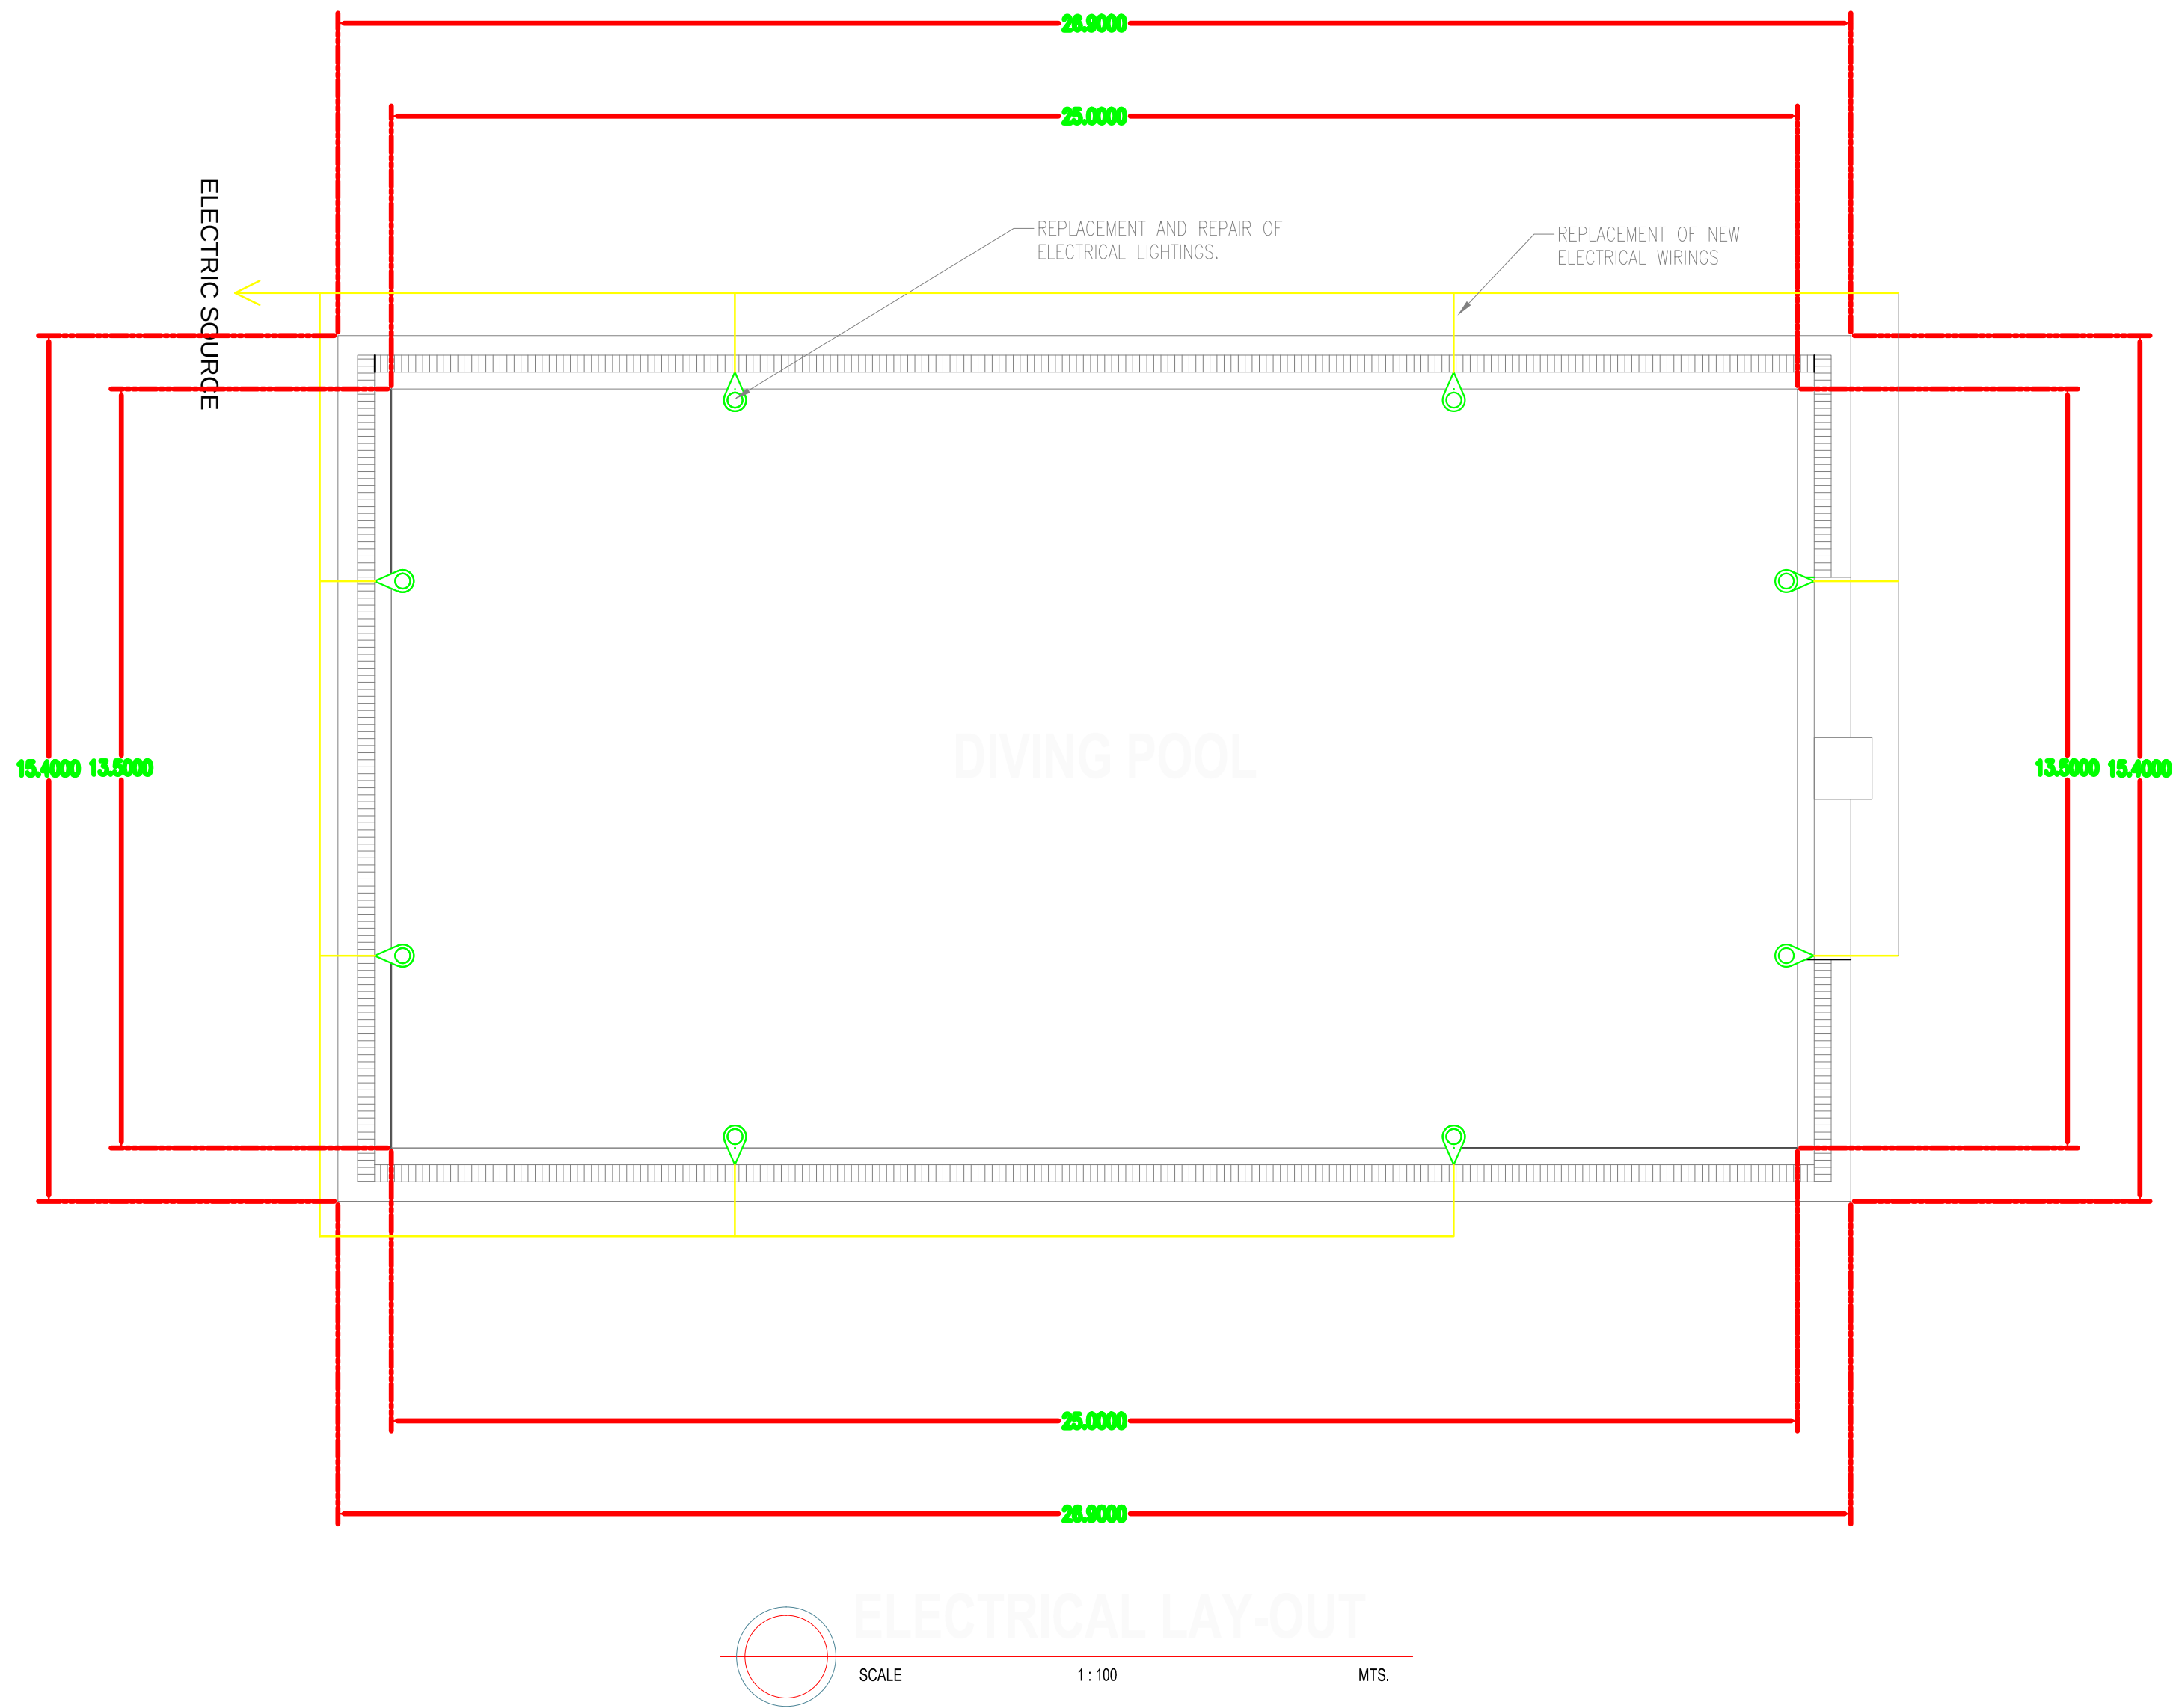


OWNER	PROJECT TITLE :	SUBMITTED BY :	RECOMMENDING APPROVAL :	APPROVED BY :	SHEET CONTENTS :	DESIGN BY :		SHEET NO :
 PHILIPPINE SPORTS COMMISSION RMSC, PABLO OCAMPO SR. ST., MALATE, MANILA	UPGRADING OF SWIMMING POOL, DIVING POOL, AND CONSTRUCTION OF NEW BLEACHERS, WARM UP POOL AND JACUZZI LOCATION: PHILSPORTS, ULTRA, MERALCO AVE., PASIG CITY	ENGR. PEDRO I. PINEDA JR. HEAD - ENGINEERING UNIT	DIR. MERLITA R. IBAY DEPUTY EXECUTIVE DIRECTOR	HON. WILLIAM I. RAMIREZ CHAIRMAN	AS SHOWN	DRAWN BY :		A 18
						CHECKED BY :		
						DATE :		
						APPROVED BY :		

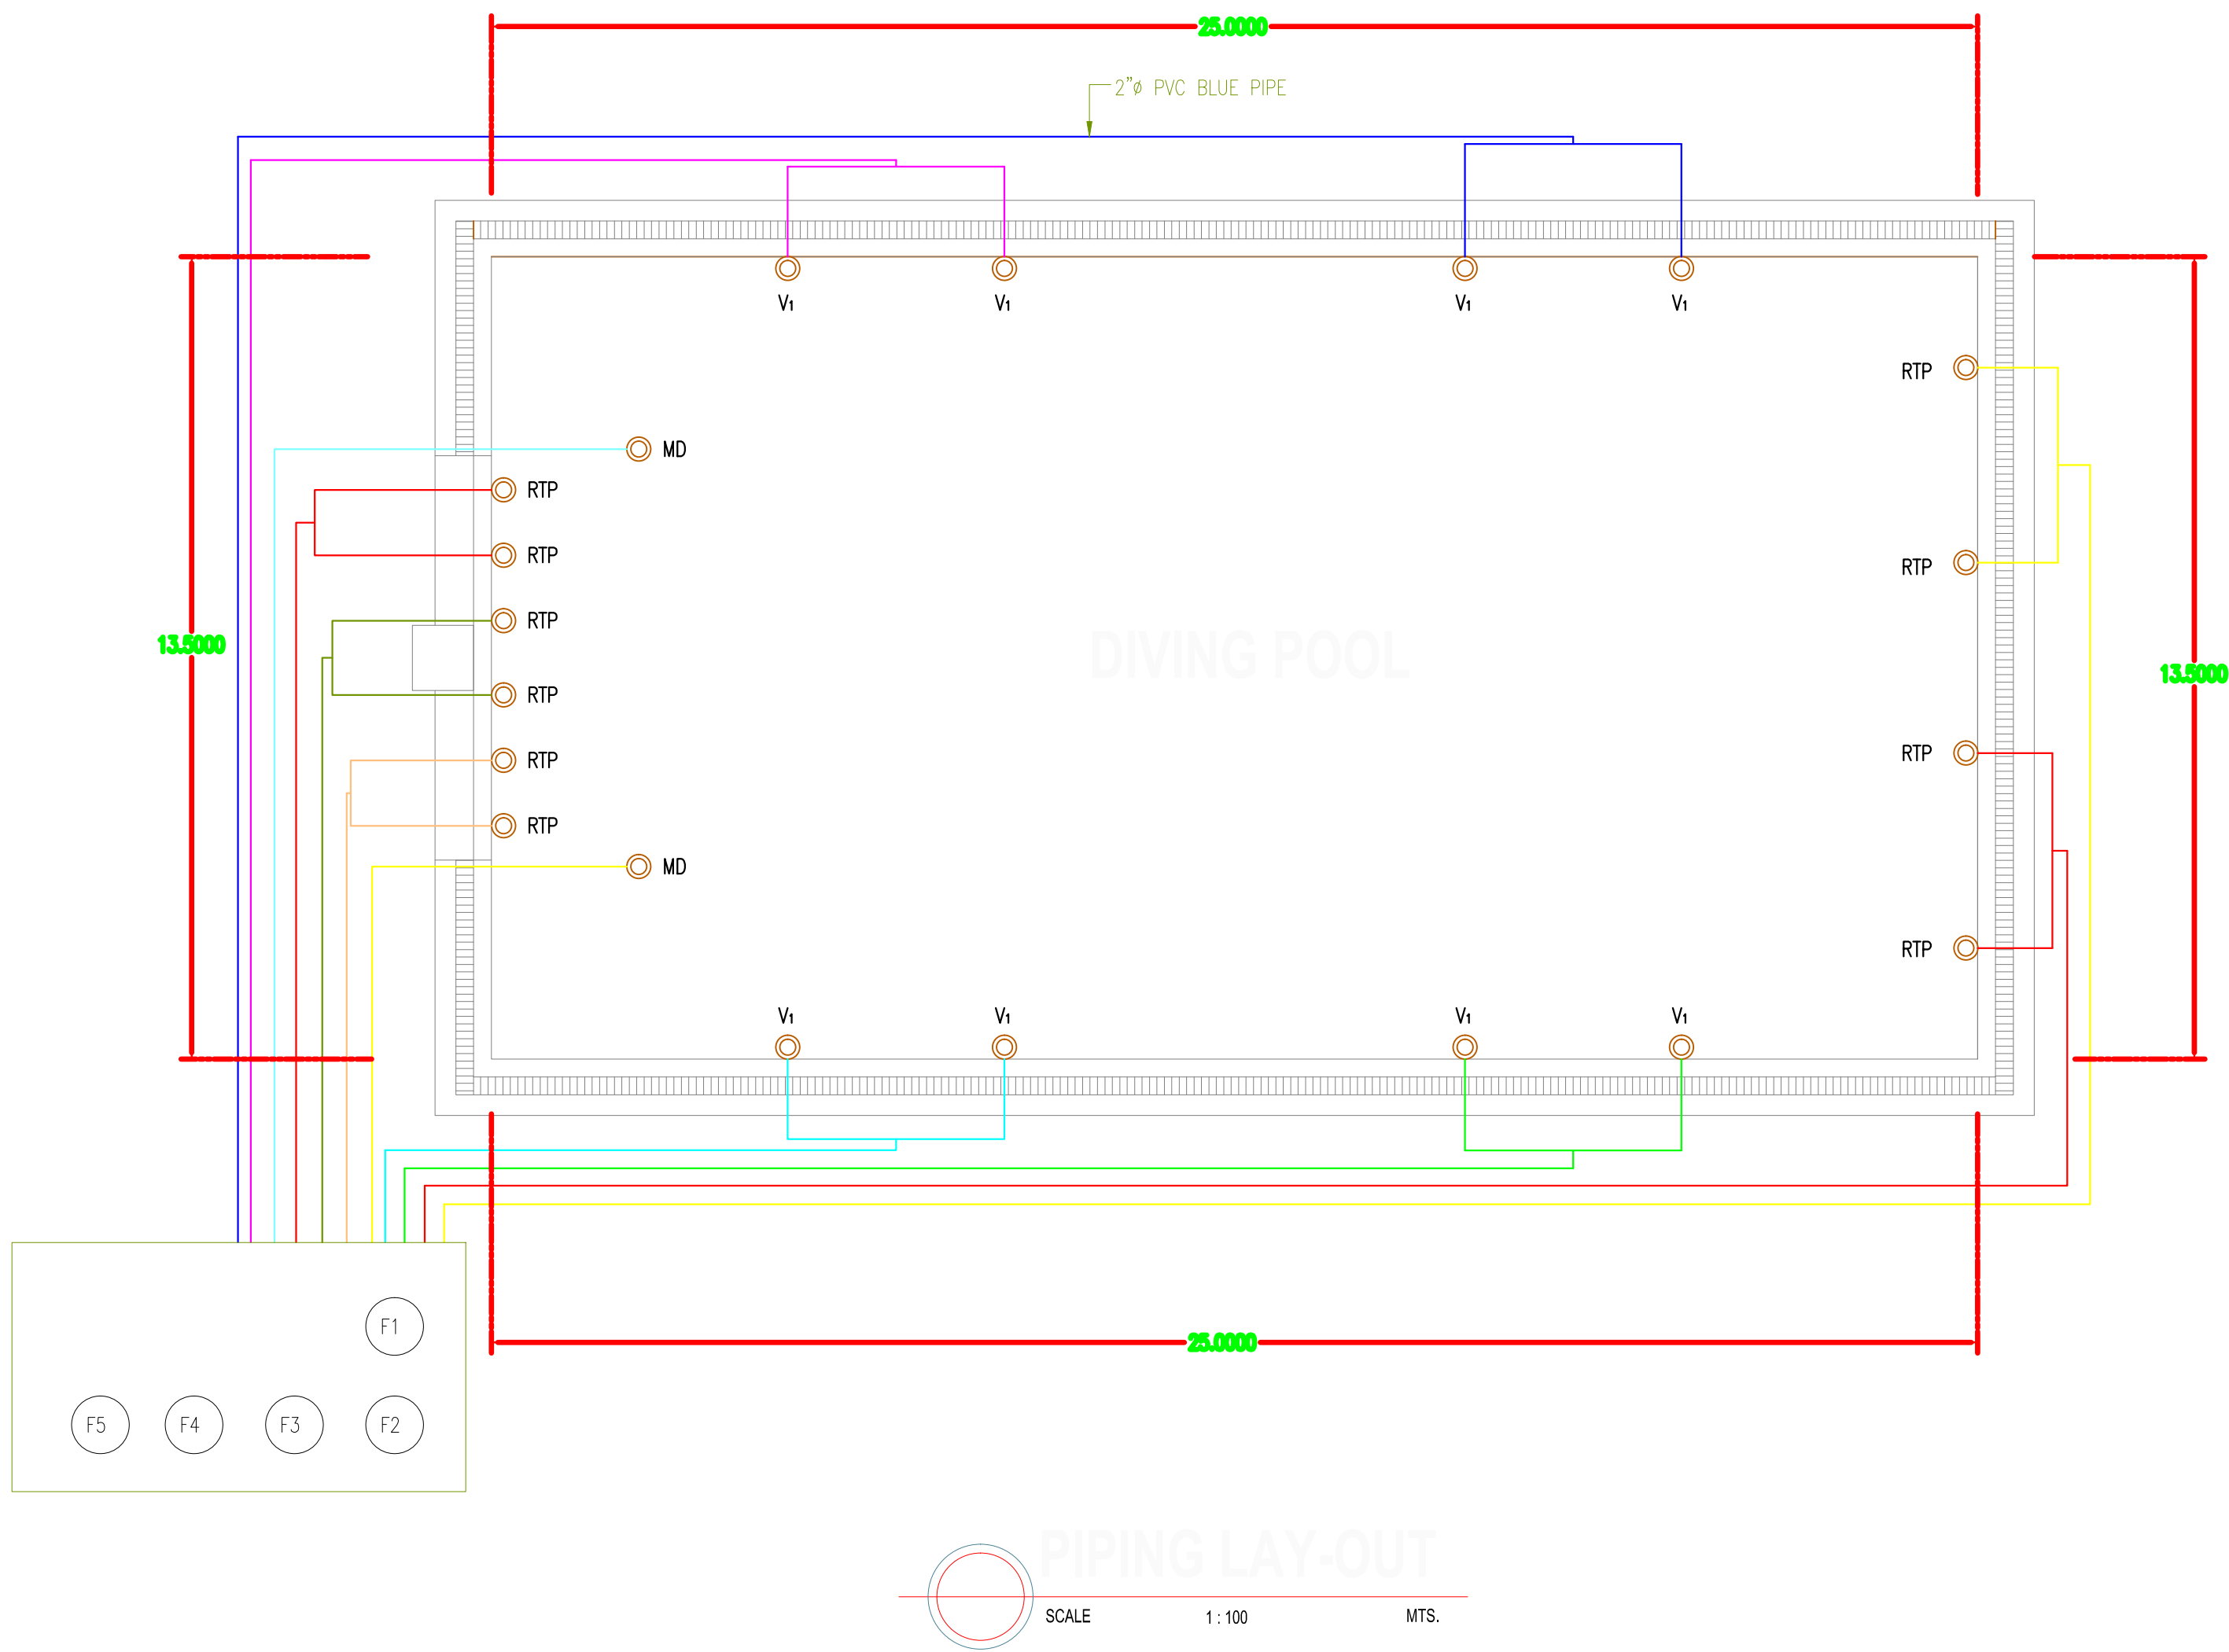

LEGENDS:

- MD - MAIN DRAIN
- RTP - RETURN TO POOL
- V1 - VACUUM



OWNER	PROJECT TITLE :	SUBMITTED BY :	RECOMMENDING APPROVAL :	APPROVED BY :	SHEET CONTENTS :	DESIGN BY :		SHEET NO :
 PHILIPPINE SPORTS COMMISSION RMSG, PABLO OCAMPO SR. ST., MALATE, MANILA	UPGRADING OF SWIMMING POOL, DIVING POOL, AND CONSTRUCTION OF NEW BLEACHERS, WARM UP POOL AND JACUZZI LOCATION: PHILSPORTS, ULTRA, MERALCO AVE., PASIG CITY	ENGR. PEDRO I. PINEDA JR. HEAD - ENGINEERING UNIT	DIR. MERLITA R. IBAY DEPUTY EXECUTIVE DIRECTOR	HON. WILLIAM I. RAMIREZ CHAIRMAN	AS SHOWN	DRAWN BY :		A 19
						CHECKED BY :		
						DATE :		
						APPROVED BY :		

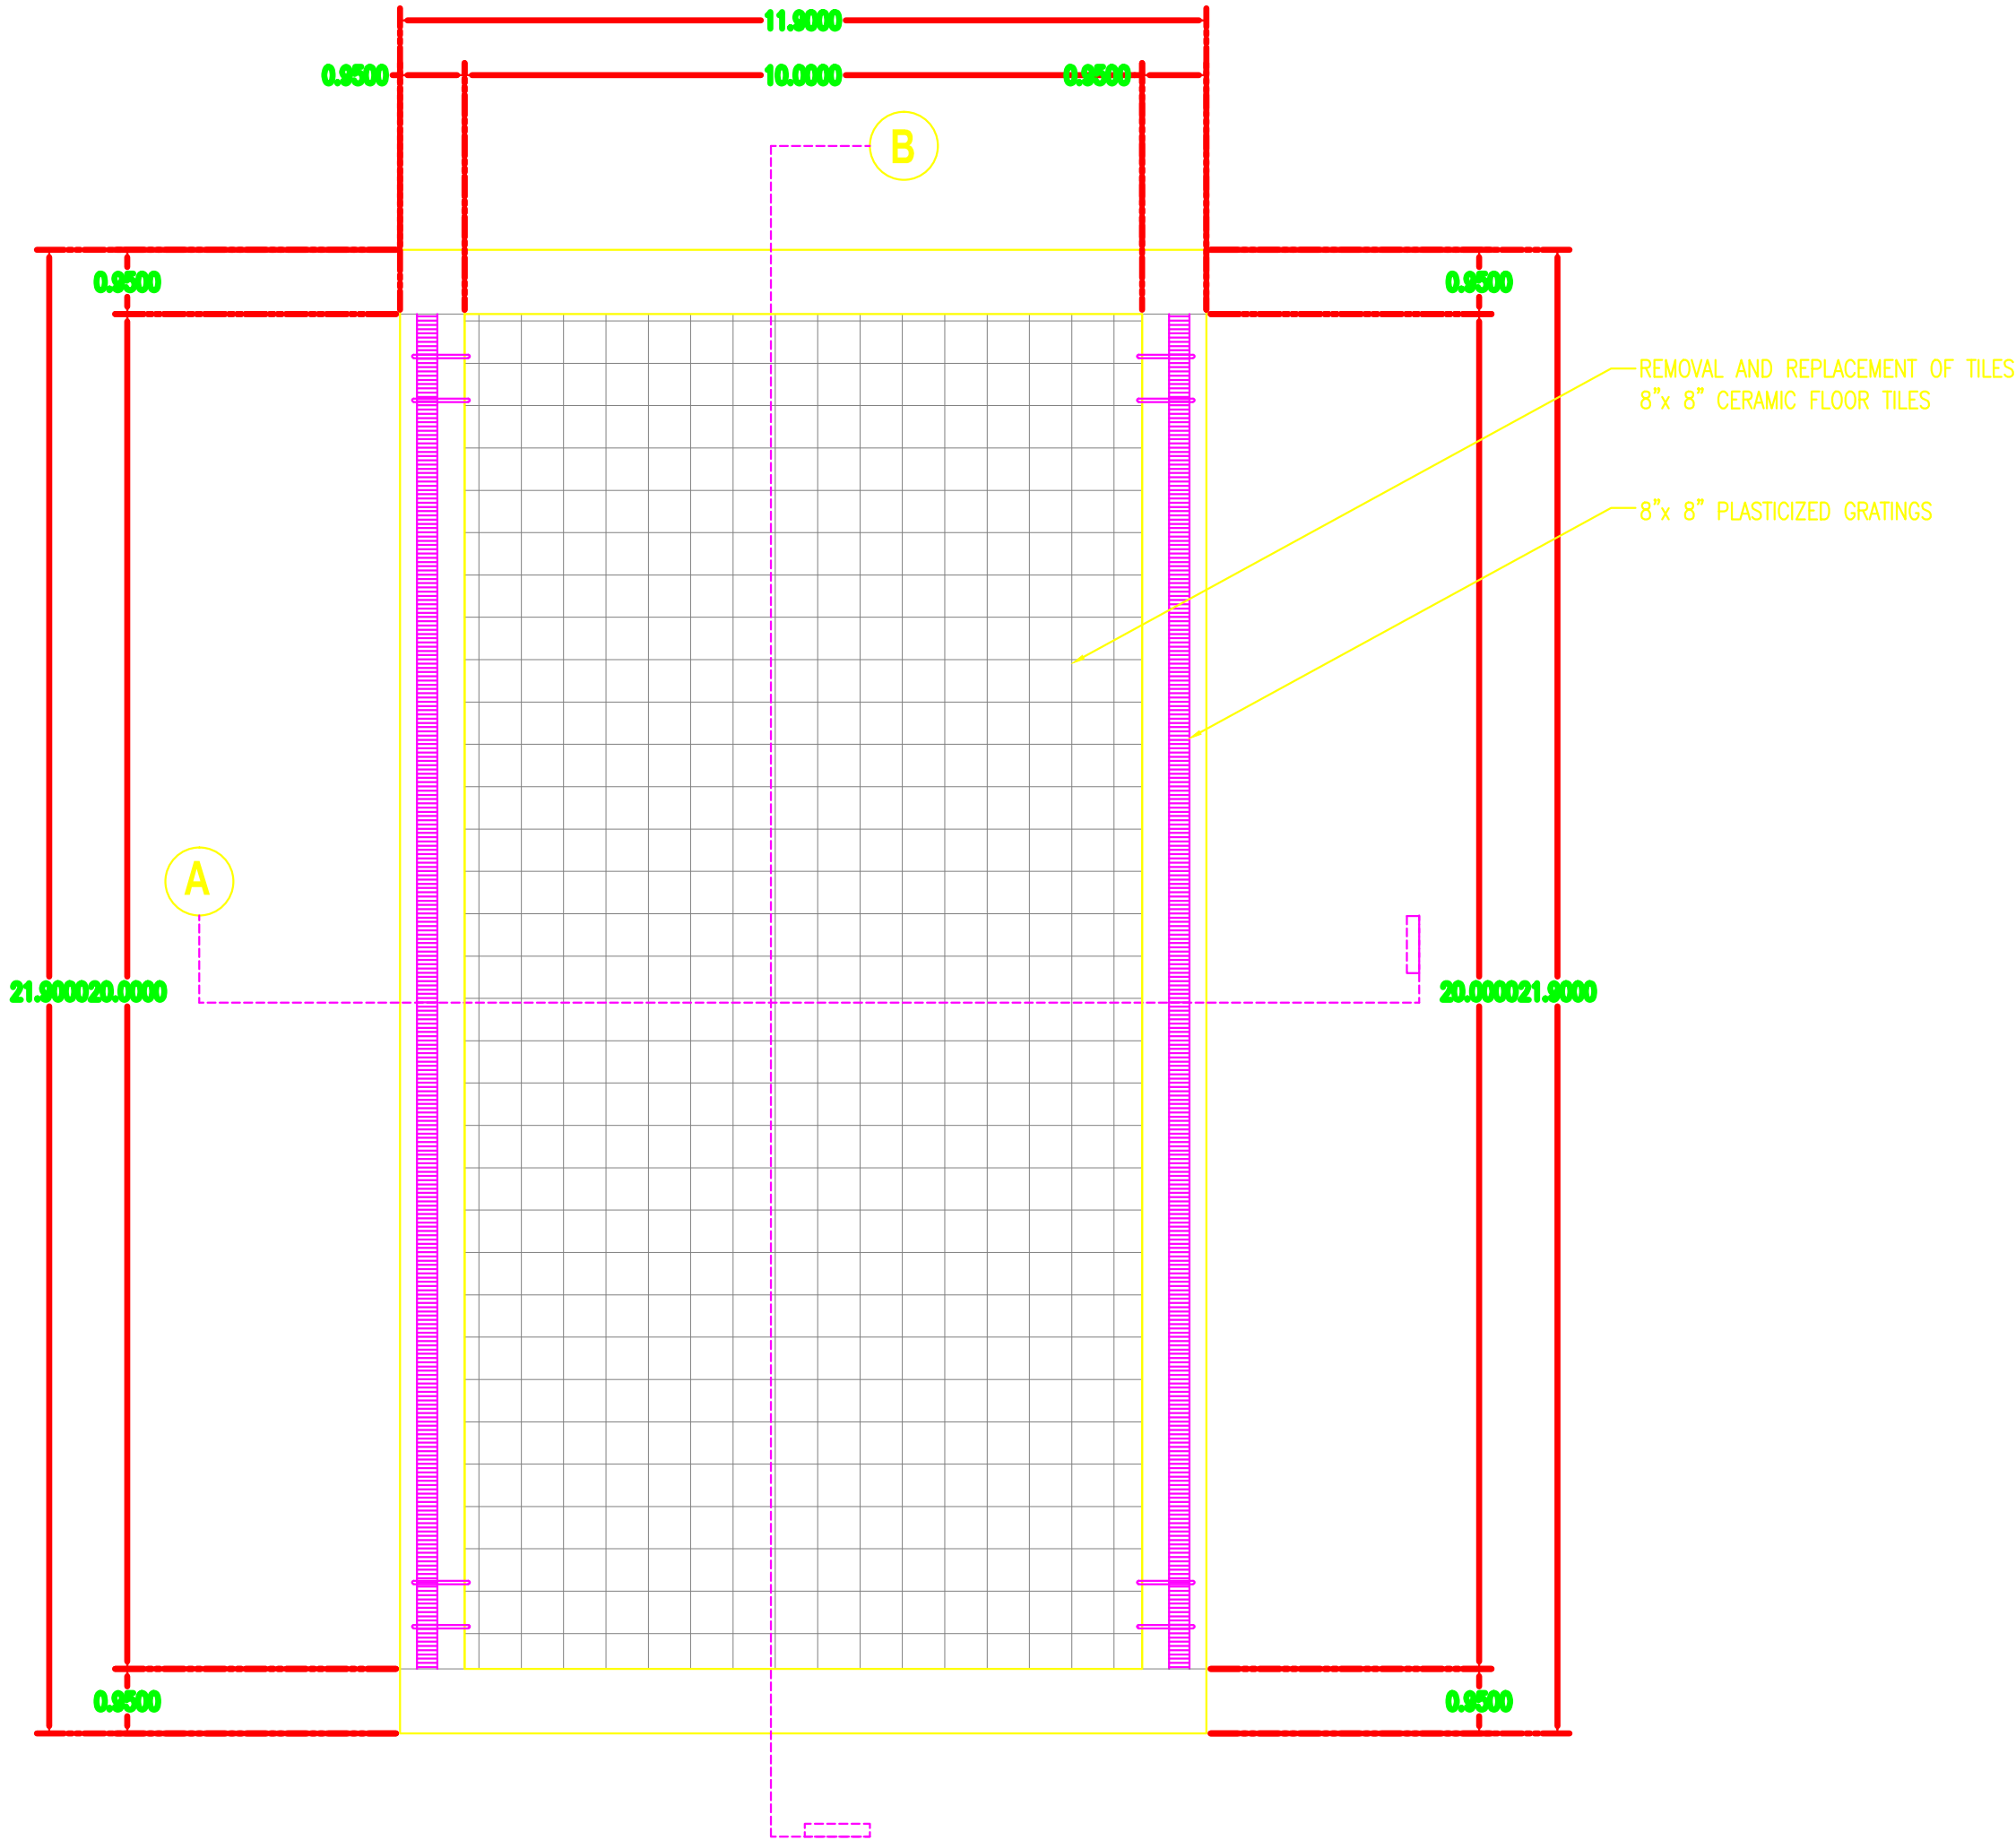













PROPOSED WARM-UP POOL PLAN


SCALE 1 : 100 MTS.

OWNER	PROJECT TITLE :	SUBMITTED BY :	RECOMMENDING APPROVAL :	APPROVED BY :	SHEET CONTENTS :	DESIGN BY :		SHEET NO :
 PHILIPPINE SPORTS COMMISSION RMSG, PABLO OCAMPO SR. ST., MALATE, MANILA PHILIPPINE SPORTS COMMISSION RMSG, PABLO OCAMPO SR. ST., MALATE, MANILA	UPGRADING OF SWIMMING POOL, DIVING POOL, AND CONSTRUCTION OF NEW BLEACHERS, WARM UP POOL AND JACUZZI LOCATION: PHILSPORTS, ULTRA, MERALCO AVE., PASIG CITY	ENGR. PEDRO I. PINEDA JR. HEAD - ENGINEERING UNIT	DIR. MERLITA R. IBAY DEPUTY EXECUTIVE DIRECTOR	HON. WILLIAM I. RAMIREZ CHAIRMAN	AS SHOWN	DESIGN BY :		A 20
						DRAWN BY :		
						CHECKED BY :		
						DATE :		
						APPROVED BY :		

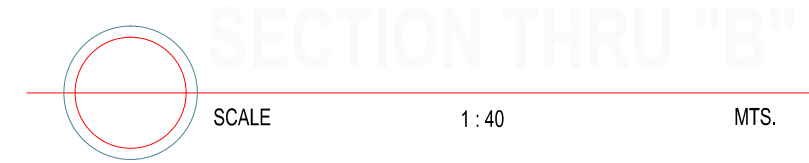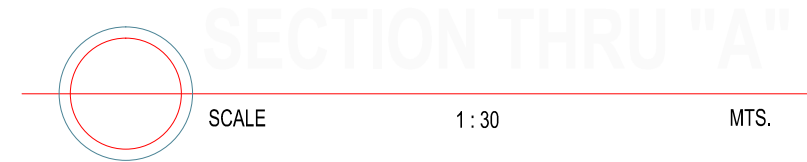

OWNER	PROJECT TITLE :	SUBMITTED BY :	RECOMMENDING APPROVAL :	APPROVED BY :	SHEET CONTENTS :	DESIGN BY :	SHEET NO :
 PHILIPPINE SPORTS COMMISSION RMSC, PABLO OCAMPO SR. ST., MALATE, MANILA	UPGRADING OF SWIMMING POOL, DIVING POOL, AND CONSTRUCTION OF NEW BLEACHERS, WARM UP POOL AND JACUZZI LOCATION: PHILSPORTS, ULTRA, MERALCO AVE., PASIG CITY	ENGR. PEDRO I. PINEDA JR. HEAD - ENGINEERING UNIT	DIR. MERLITA R. IBAY DEPUTY EXECUTIVE DIRECTOR	HON. WILLIAM I. RAMIREZ CHAIRMAN	AS SHOWN	DRAWN BY :	A 21
						CHECKED BY :	
						DATE :	
						APPROVED BY :	

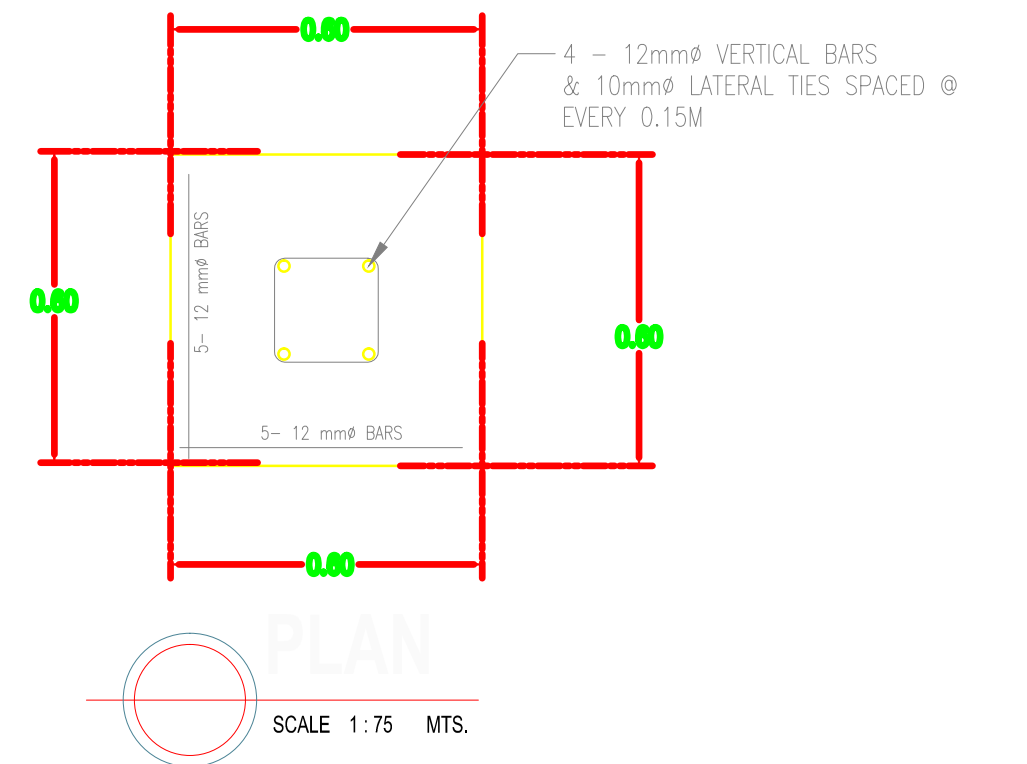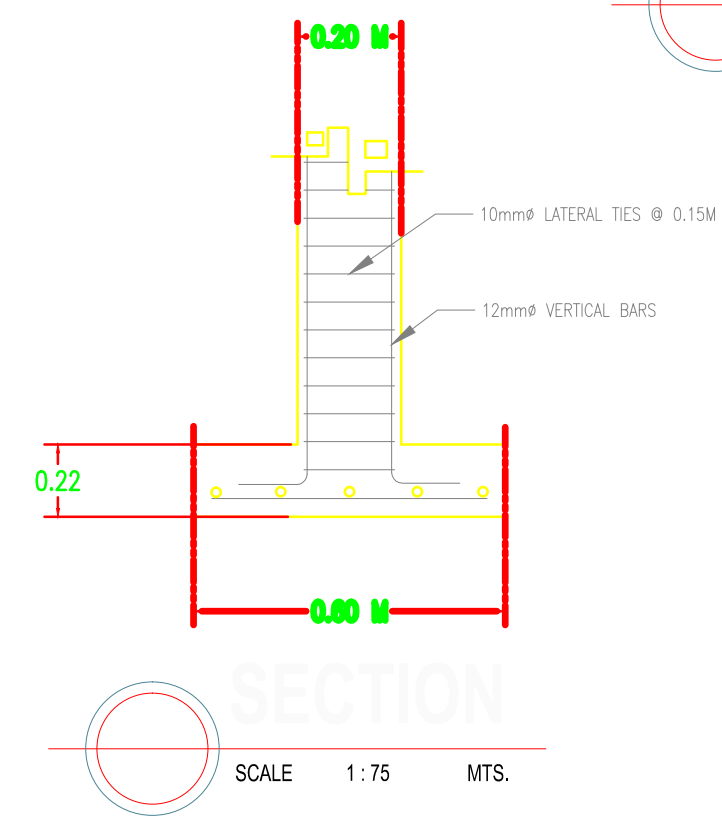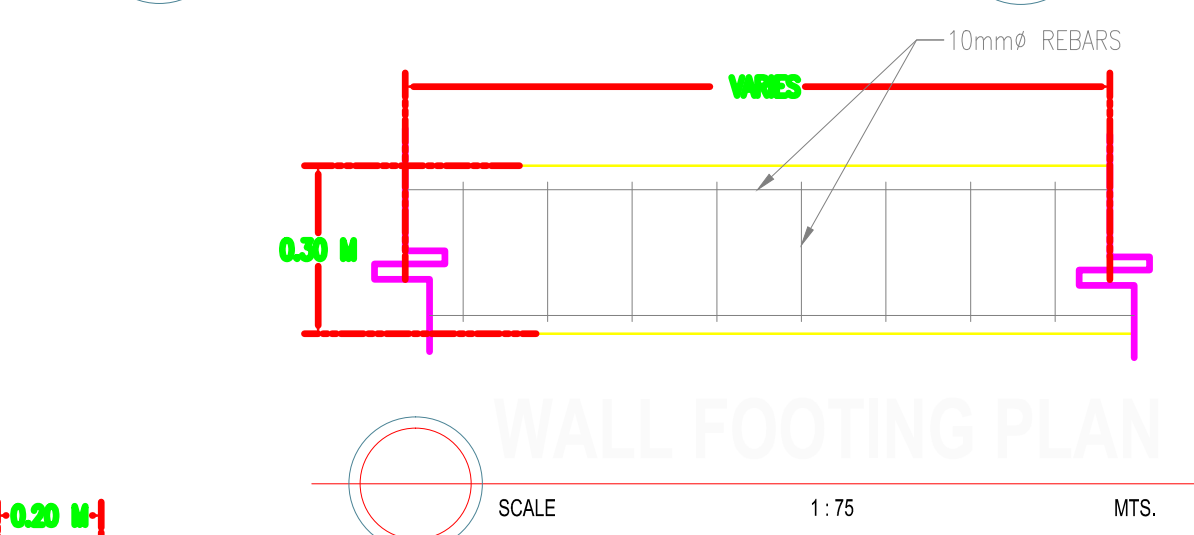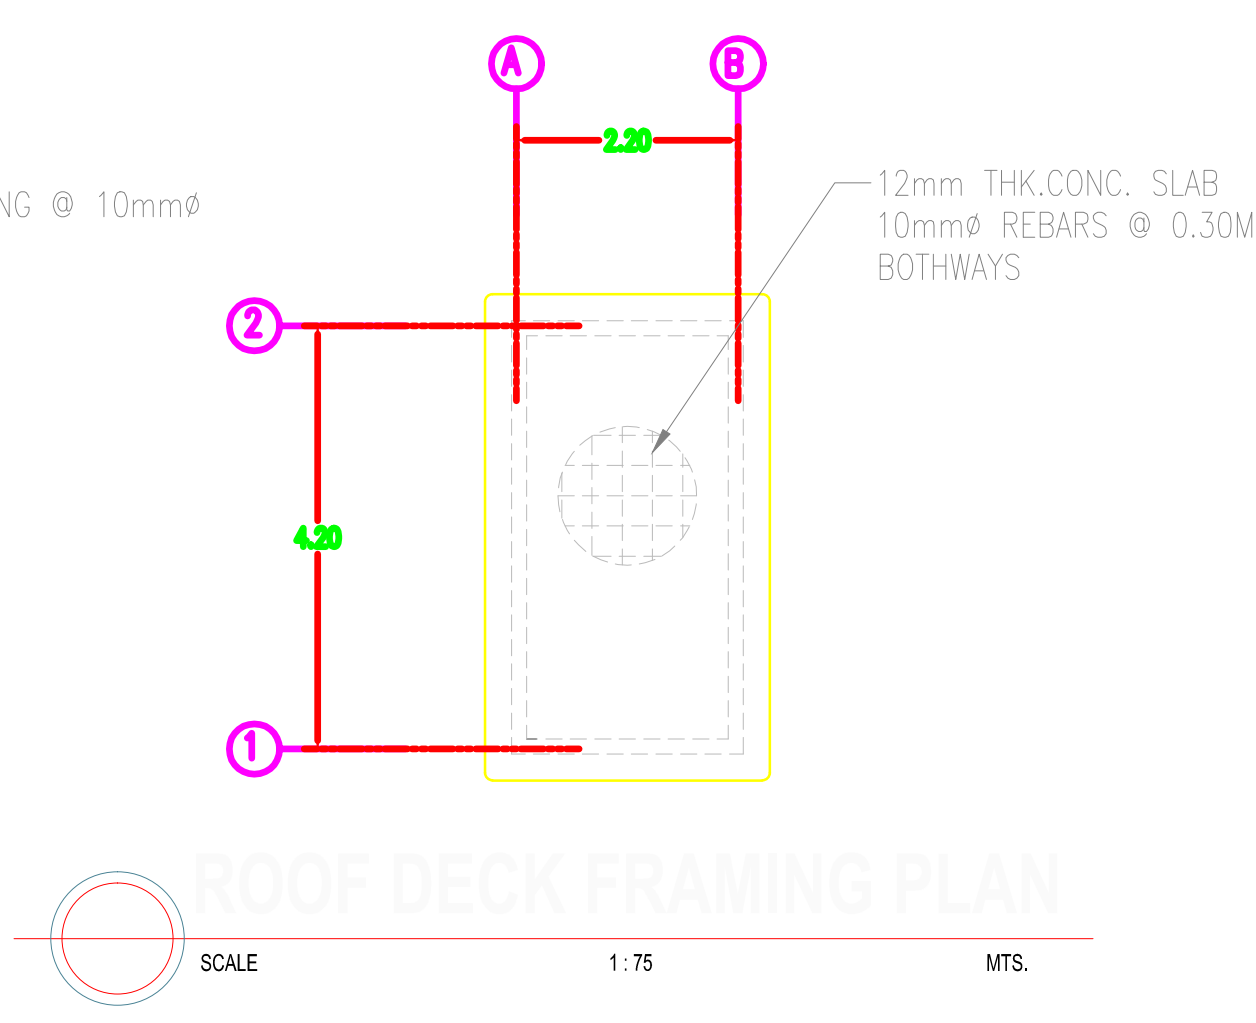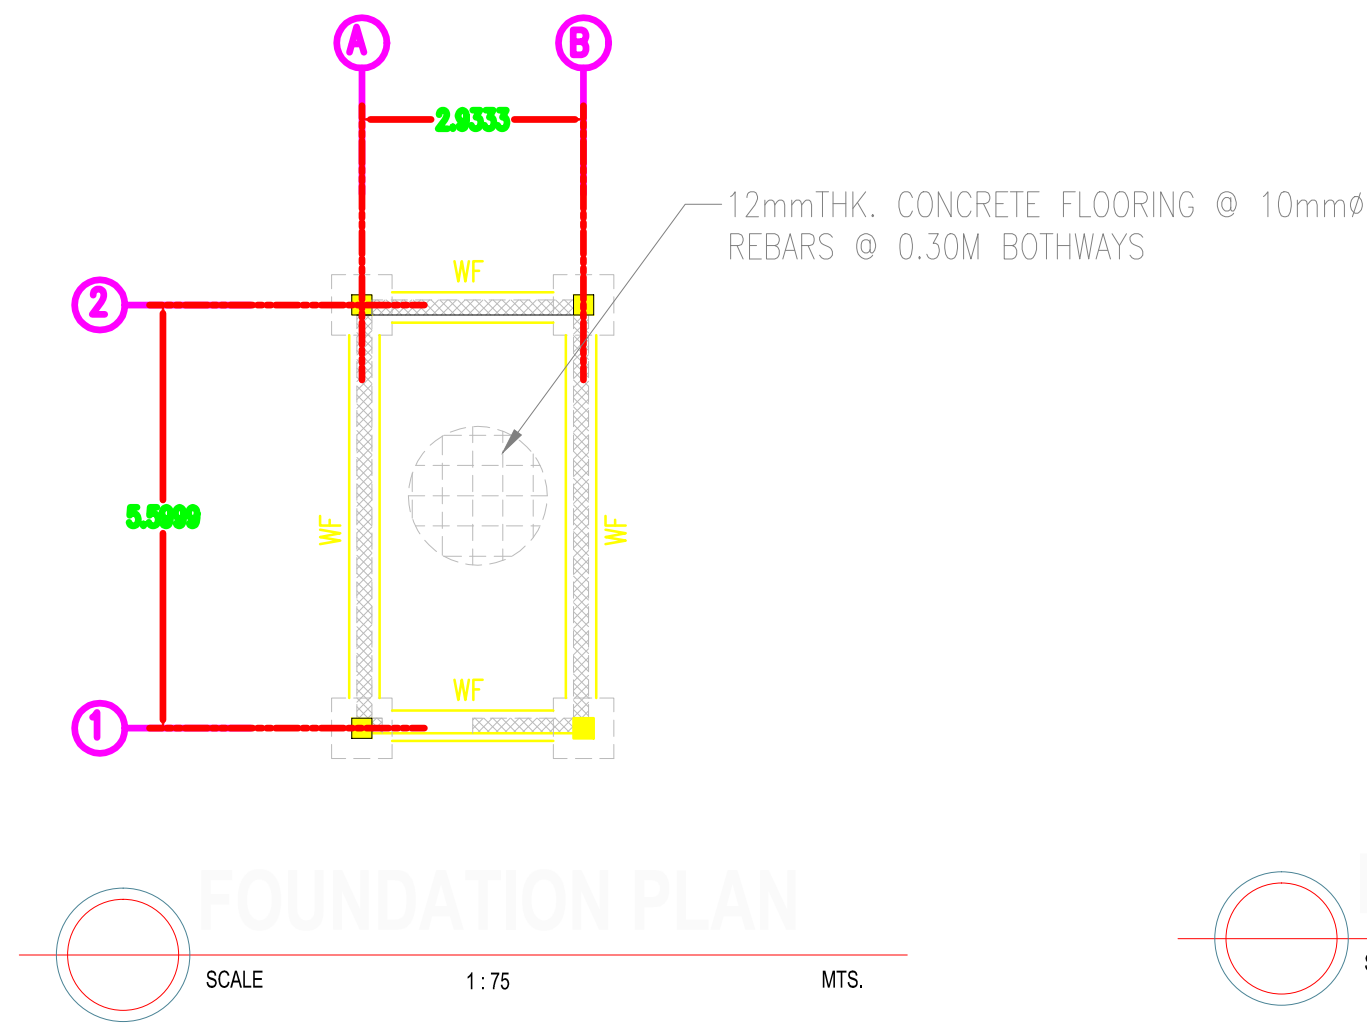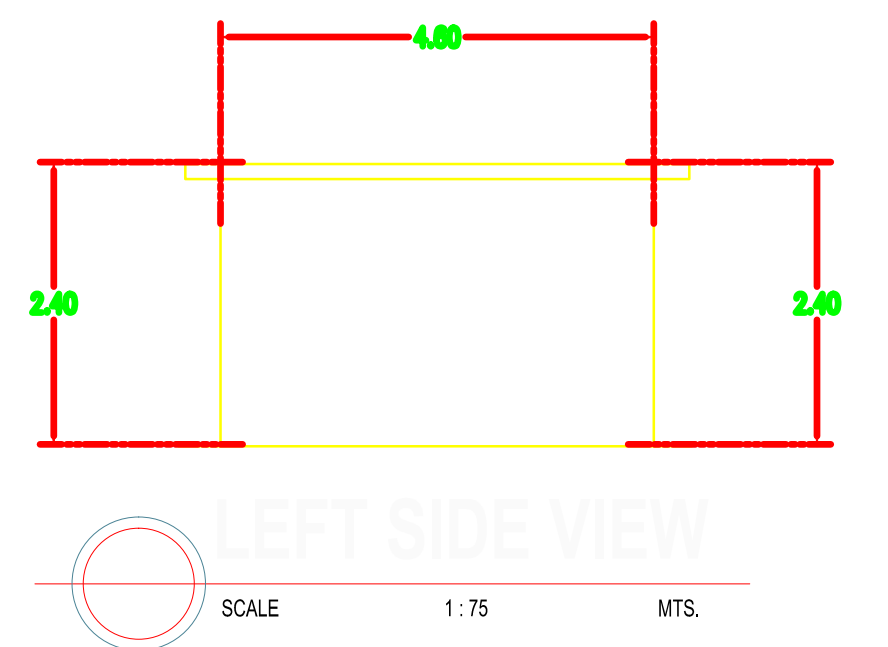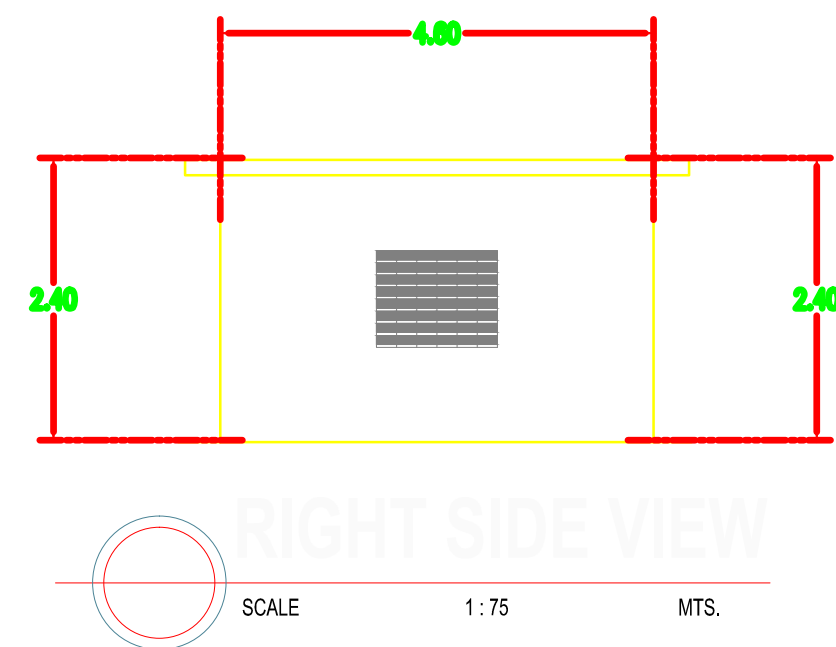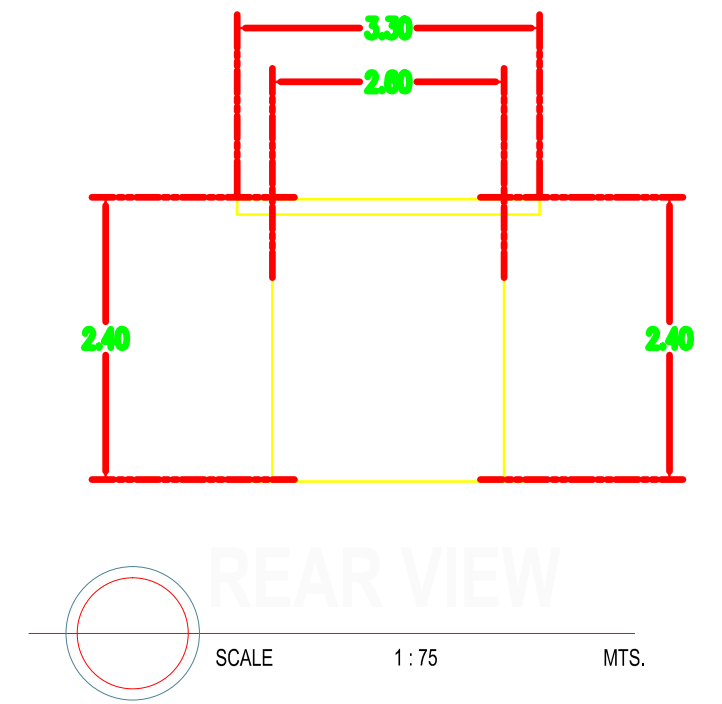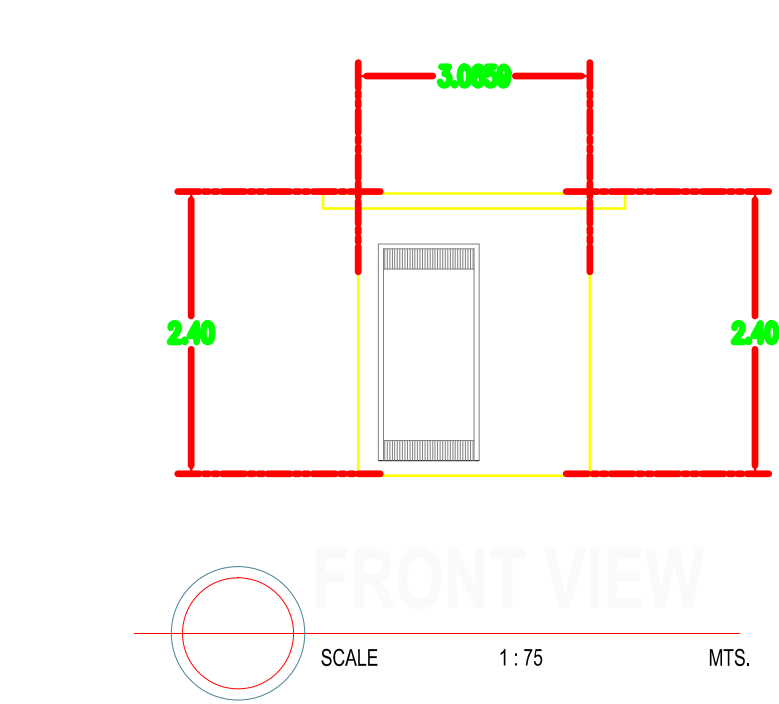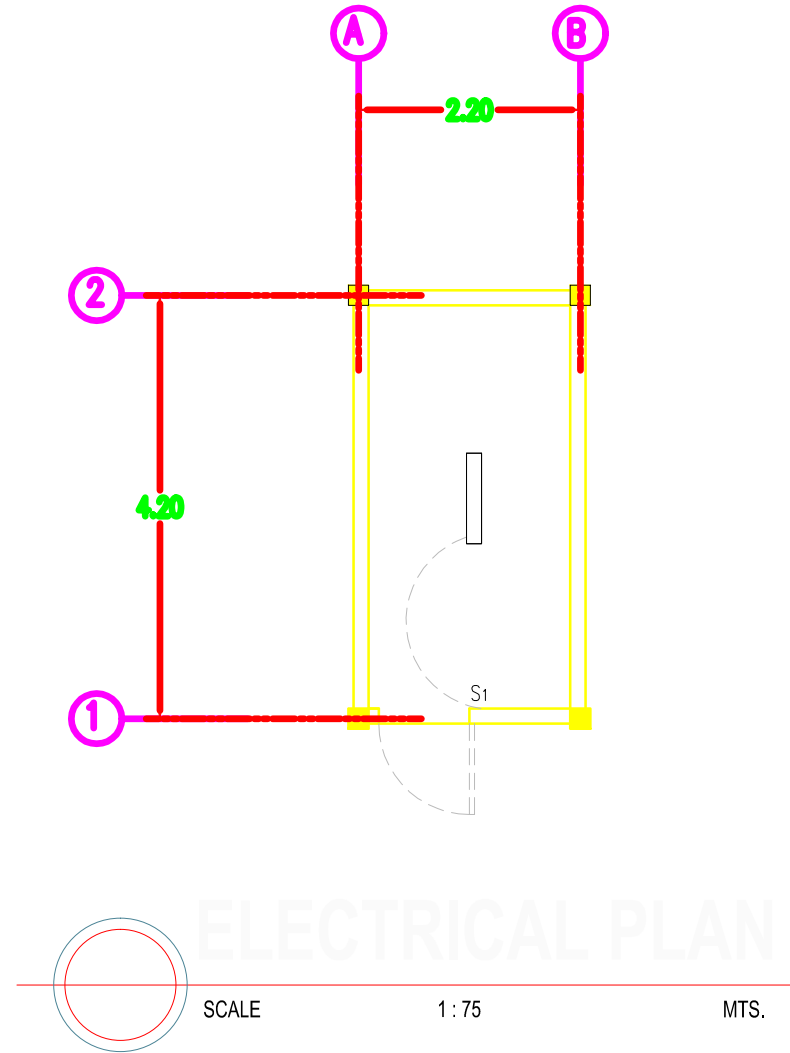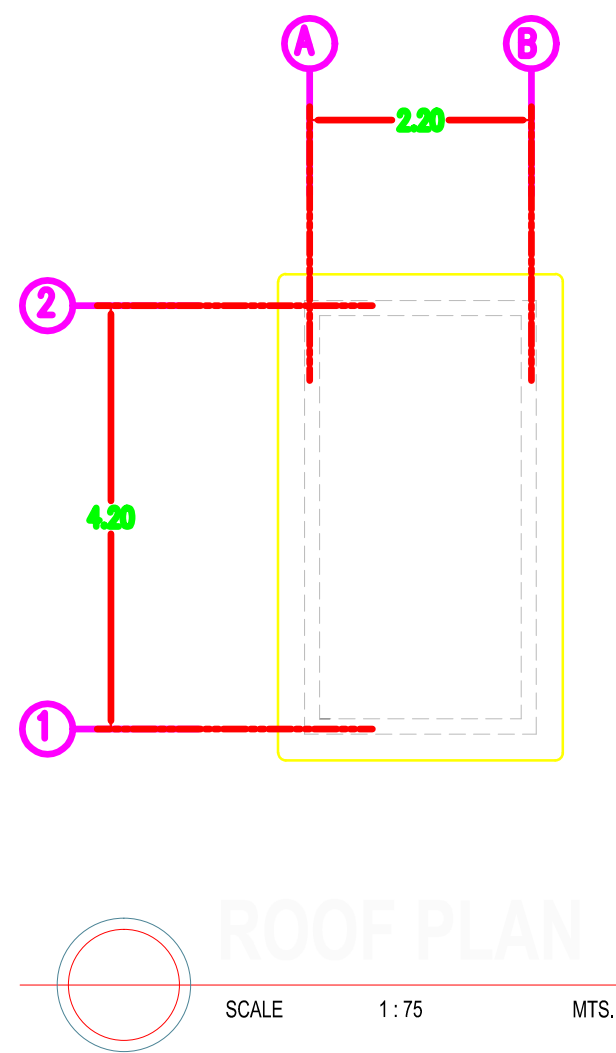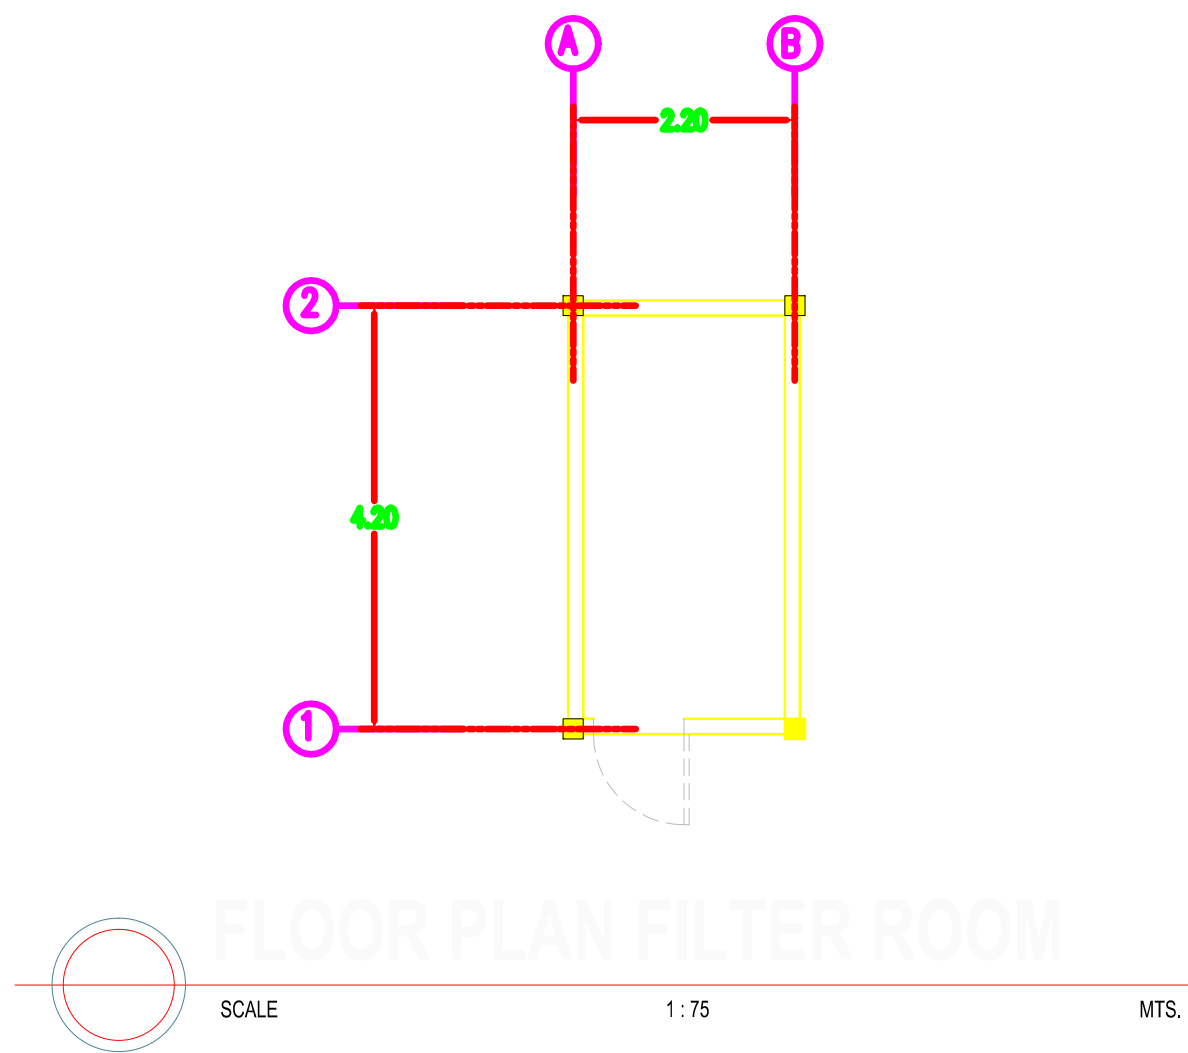

 OWNER	PROJECT TITLE :	SUBMITTED BY :	RECOMMENDING APPROVAL :	APPROVED BY :	SHEET CONTENTS :	DESIGN BY :		SHEET NO :
 PHILIPPINE SPORTS COMMISSION RMSC, PABLO OCAMPO SR. ST., MALATE, MANILA	UPGRADING OF SWIMMING POOL, DIVING POOL, AND CONSTRUCTION OF NEW BLEACHERS, WARM UP POOL AND JACUZZI LOCATION: PHILSPORTS, ULTRA, MERALCO AVE., PASIG CITY	ENGR. PEDRO I. PINEDA JR. HEAD - ENGINEERING UNIT	DIR. MERLITA R. IBAY DEPUTY EXECUTIVE DIRECTOR	HON. WILLIAM I. RAMIREZ CHAIRMAN	AS SHOWN	DRAWN BY :		A 22
						CHECKED BY :		
						DATE :		
						APPROVED BY :		